

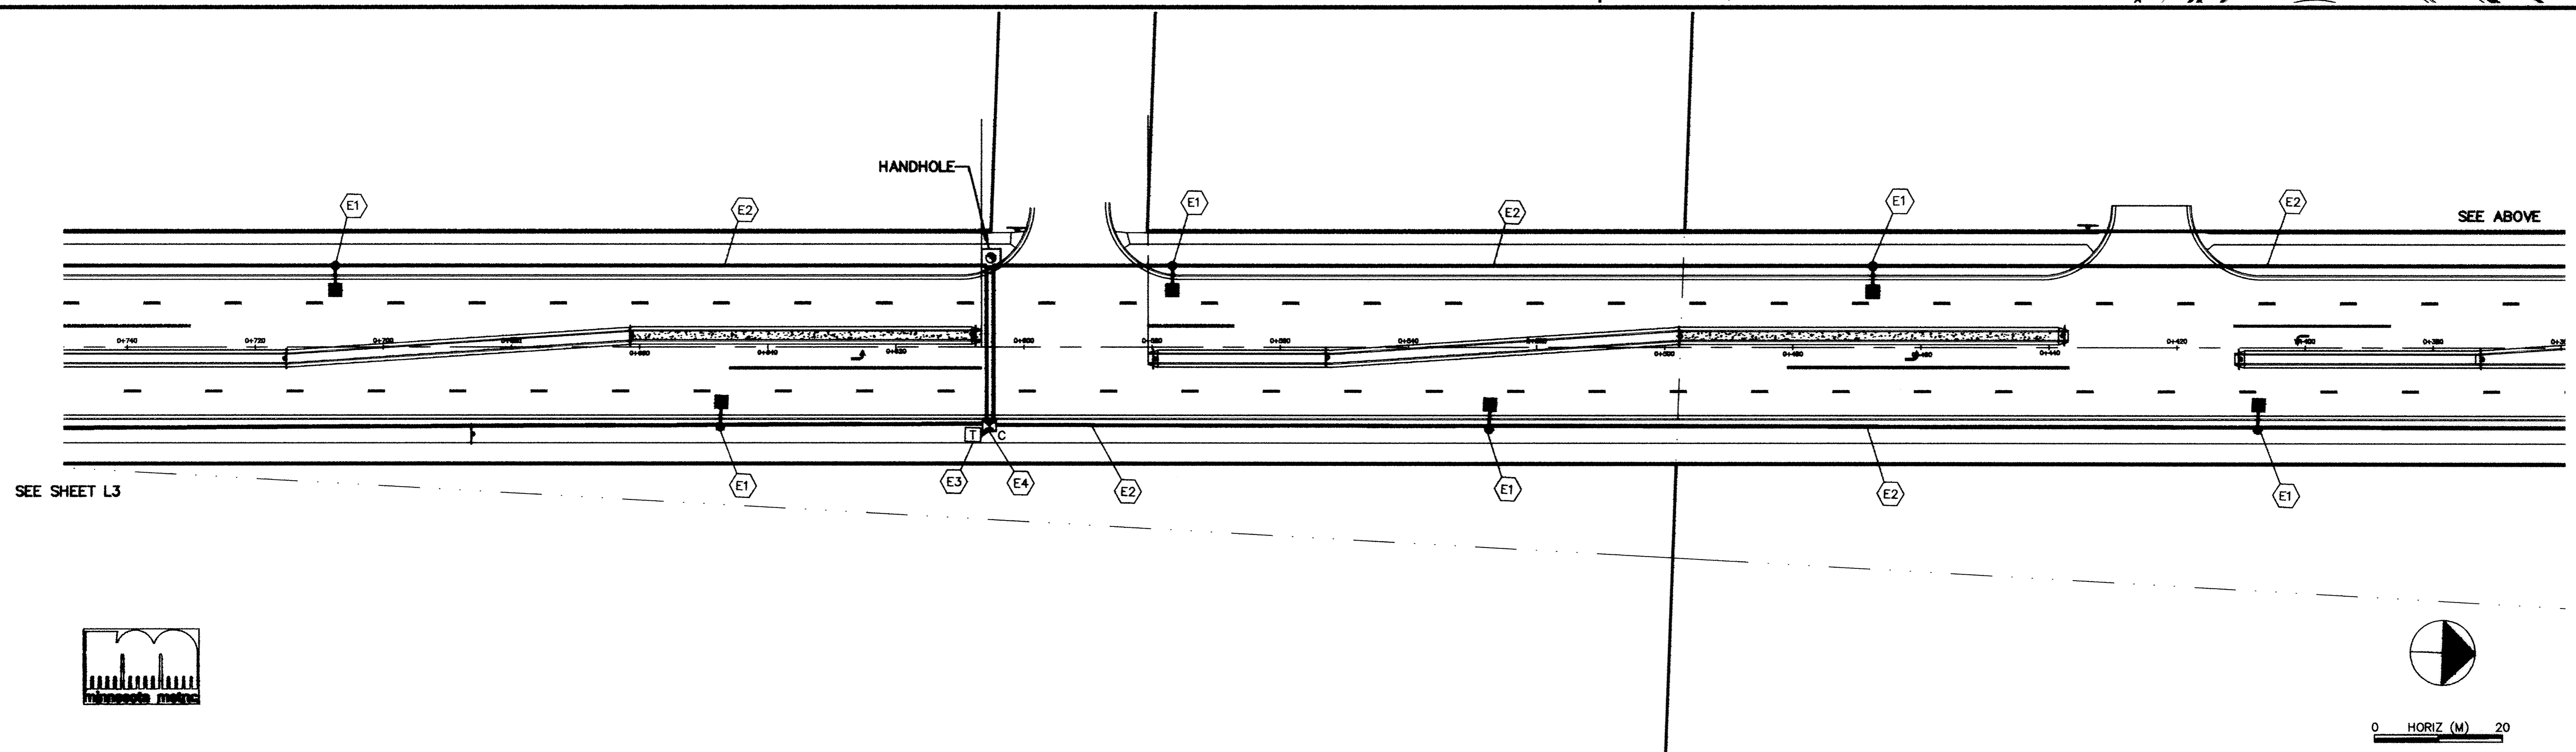
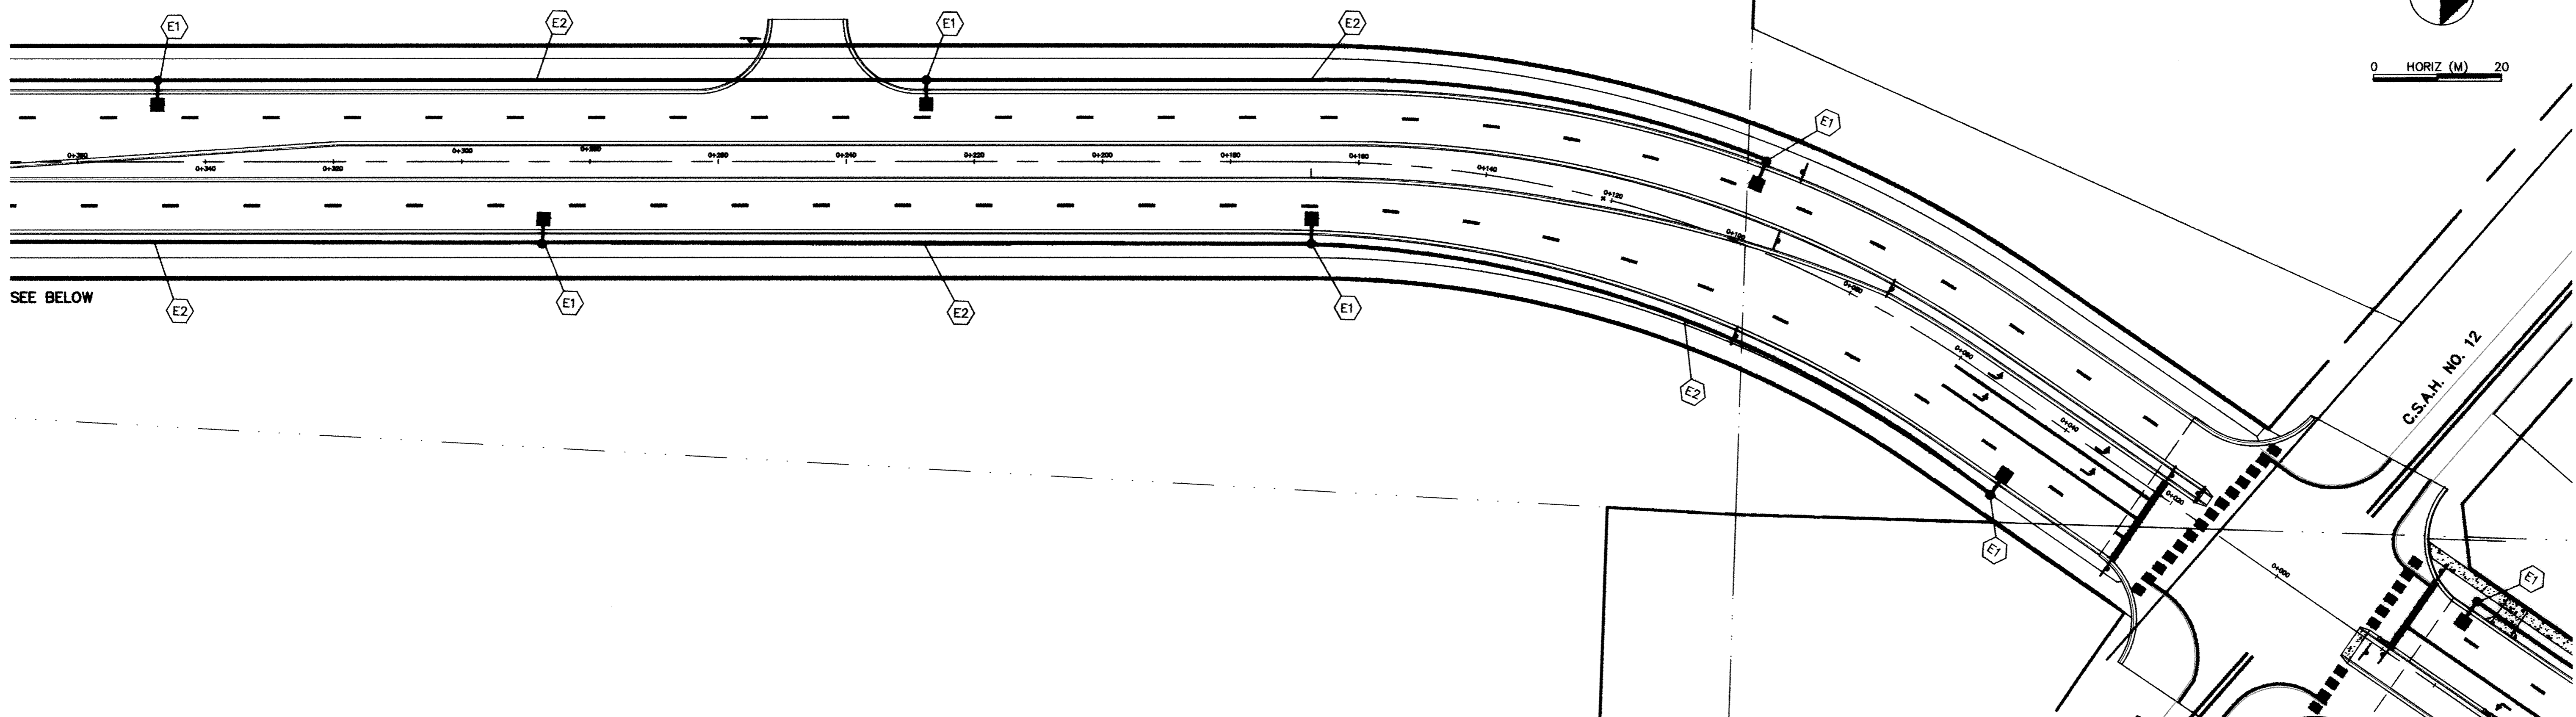


TYLER STREET

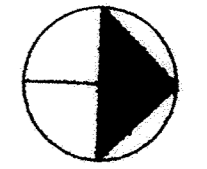

0 HORIZ (M) 20

0 HORIZ (M) 20

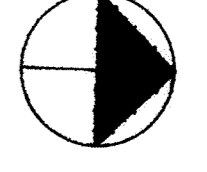


C.S.A.H. NO. 12

SEE ABOVE

SEE BELOW

SEE SHEET L3

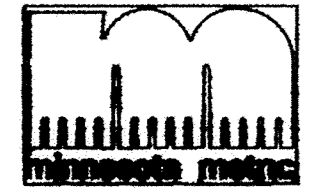

DESIGNED BY: AB JOB DATE: MARCH 1998
 DRAWN BY: [Signature] JOB NUMBER: 800110J
 APPROVED: _____ CAD DATE: _____
 CAD FILE: January 08, 2003 9:39:04 a.m.
 800110T\800110J\DWGS\TYLER_LIGHTING\TYLER-LITE.DWG

I HEREBY CERTIFY THAT THIS PLAN, SPECIFICATION,
 OR REPORT WAS PREPARED BY ME OR UNDER MY DIRECT
 SUPERVISION AND THAT I AM A DULY REGISTERED
 PROFESSIONAL ENGINEER UNDER THE LAWS OF THE
 STATE OF MINNESOTA.
 _____ REG. NO. _____

NO.	DATE	BY	REVISION DESCRIPTION



1326 ENERGY PARK DRIVE
 ST. PAUL, MINNESOTA 55108
 (612) 644-4389
Howard R. Green Company
 CONSULTING ENGINEERS

CITY OF ELK RIVER
 EASTERN AREA
 TYLER STREET IMPROVEMENTS

LIGHTING PLAN
 TYLER STREET S. OF C.S.A.H. 12
 S.P. 204-133-01
 0+000 TO 0+740

SHEET NO.
L2

DRAWING NUMBER
 DRAWING NUMBER
 DRAWING NUMBER
 DRAWING NUMBER
 DRAWING NUMBER
 DRAWING NUMBER
 EAST 01
 102
 DRAWING NUMBER