
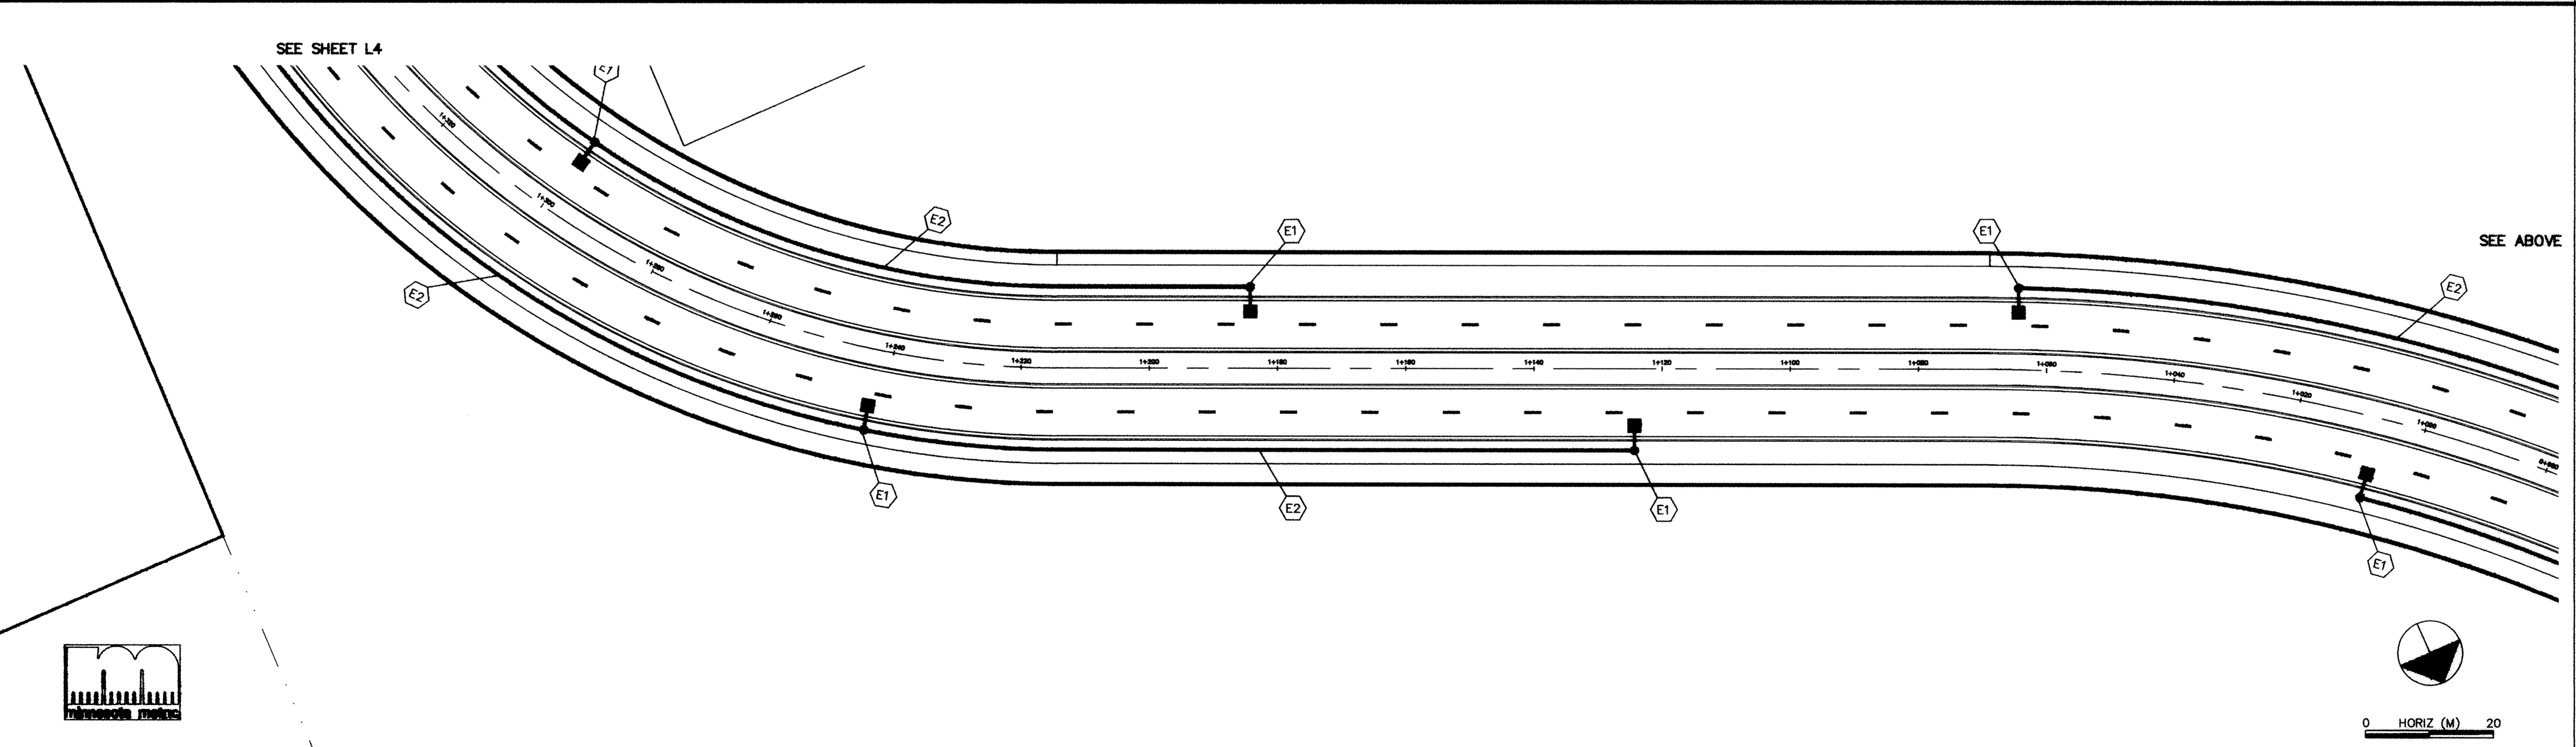


TYLER STREET

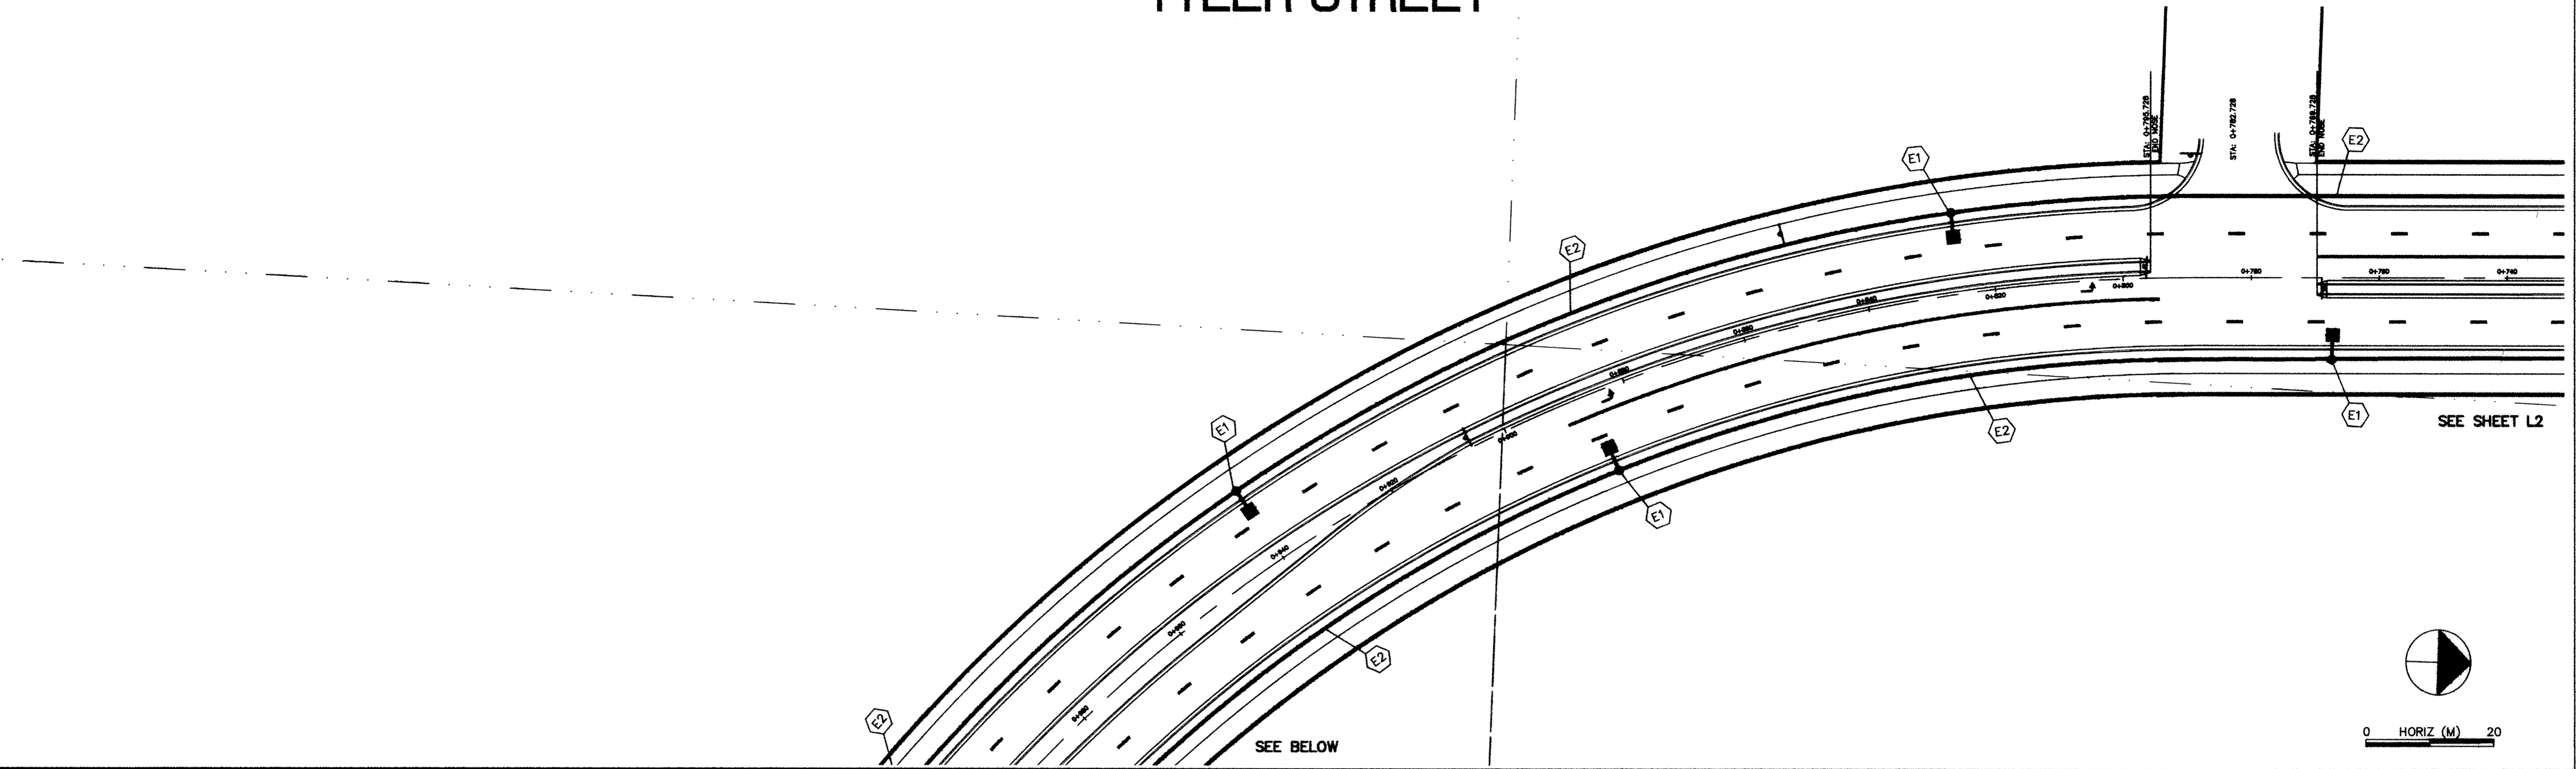

DESIGNED BY: AB JOB DATE: MARCH 1998
 DRAWN BY: *ag* JOB NUMBER: 800110J
 APPROVED: _____ CAD DATE: _____
 CAD FILE: January 06, 2003 9:40:01 a.m.
 800110T\800110J\DWGS\TYLER_LIGHTING\TYLER-LITE2.DWG

I HEREBY CERTIFY THAT THIS PLAN, SPECIFICATION,
 OR REPORT WAS PREPARED BY ME OR UNDER MY DIRECT
 SUPERVISION AND THAT I AM A DULY REGISTERED
 PROFESSIONAL ENGINEER UNDER THE LAWS OF THE
 STATE OF MINNESOTA.

DATE: _____ REG. NO. _____

NO.	DATE	BY	REVISION DESCRIPTION



Howard R. Green Company
 CONSULTING ENGINEERS

1326 ENERGY PARK DRIVE
 ST. PAUL, MINNESOTA 55108
 (612) 644-4389

CITY OF ELK RIVER
 EASTERN AREA
 TYLER STREET IMPROVEMENTS

LIGHTING PLAN
 TYLER STREET S. OF C.S.A.H. 12
 S.P. 204-133-01 0+740 TO 1+320

SHEET NO.
L3

DRAWING NUMBER EASTE.01 103 DRAWING NUMBER DRAWING NUMBER DRAWING NUMBER DRAWING NUMBER
 CO. PRODUCTS • NEW HOPE, MINNESOTA
 REVISION BY PART NUMBER 8552
 SAIACO PRODUCTS • NEW HOPE, MINNESOTA
 REVISION BY PART NUMBER 8552
 SAIACO PRODUCTS • NEW HOPE, MINNESOTA
 REVISION BY PART NUMBER 8552
 SAIACO PRODUCTS • NEW HOPE, MINNESOTA
 REVISION BY PART NUMBER 8552