
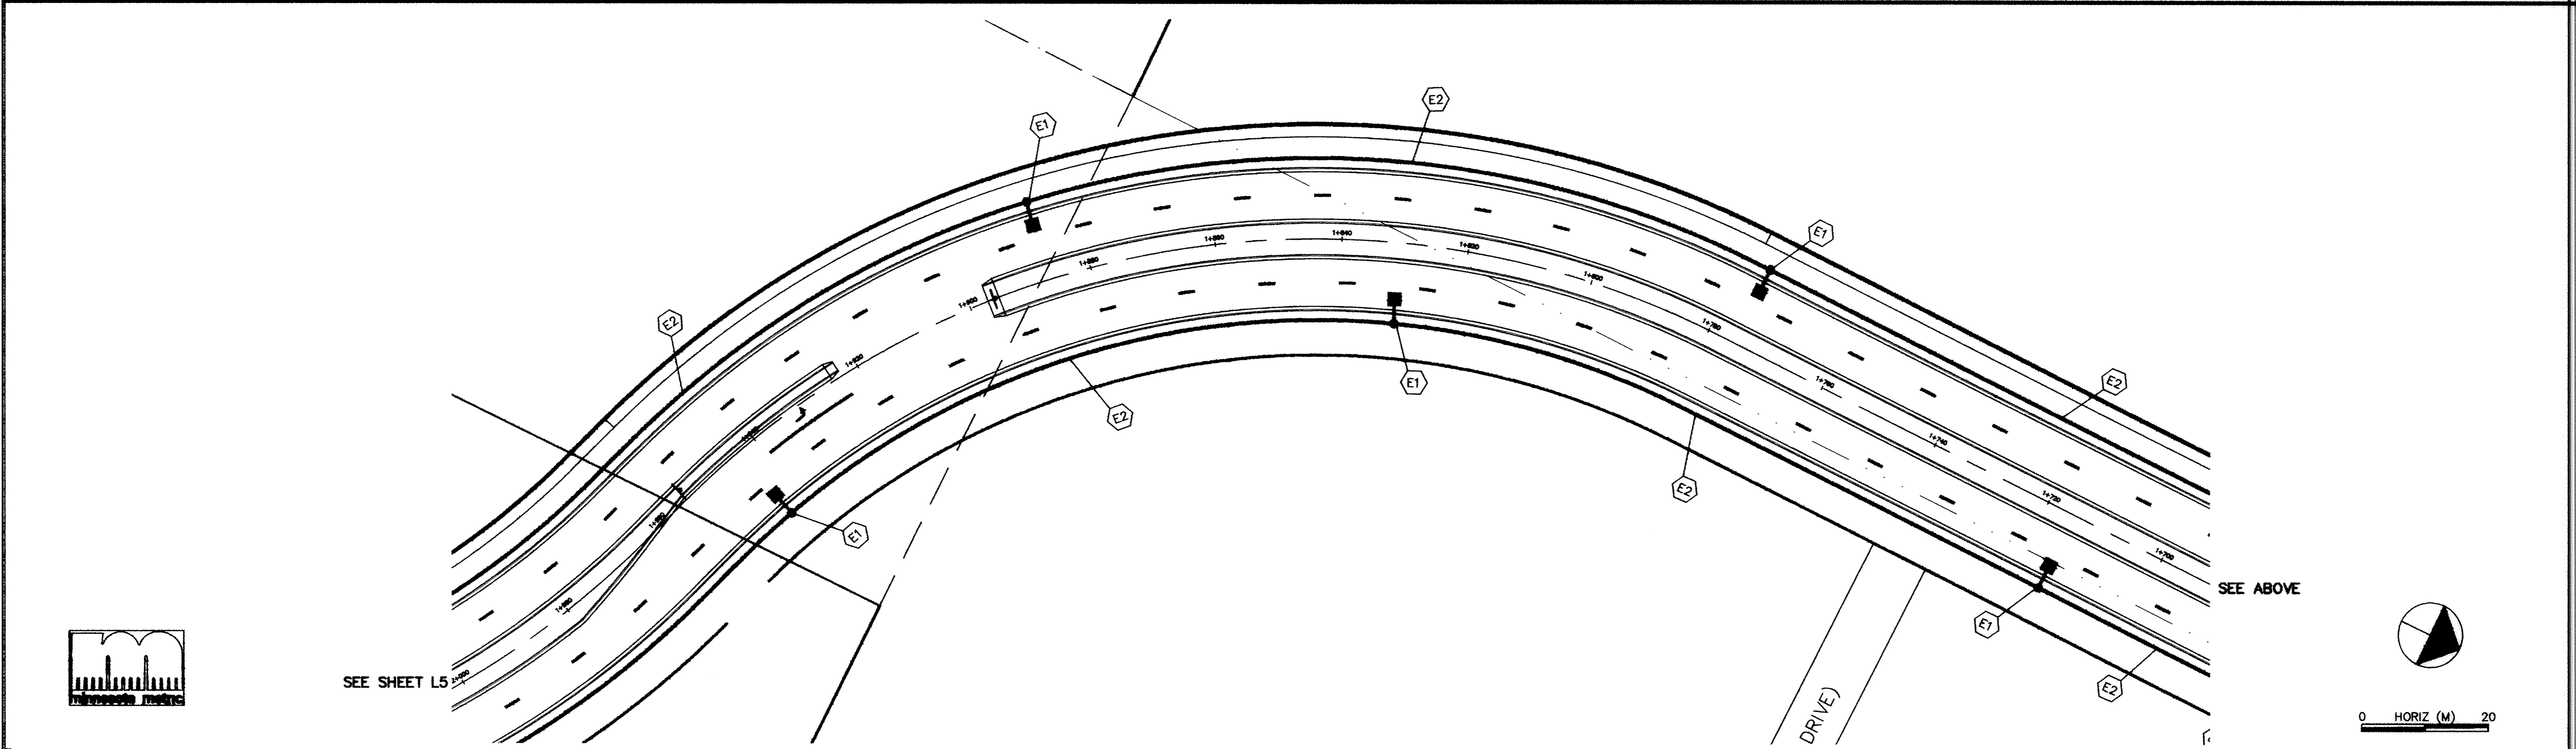


TYLER STREET

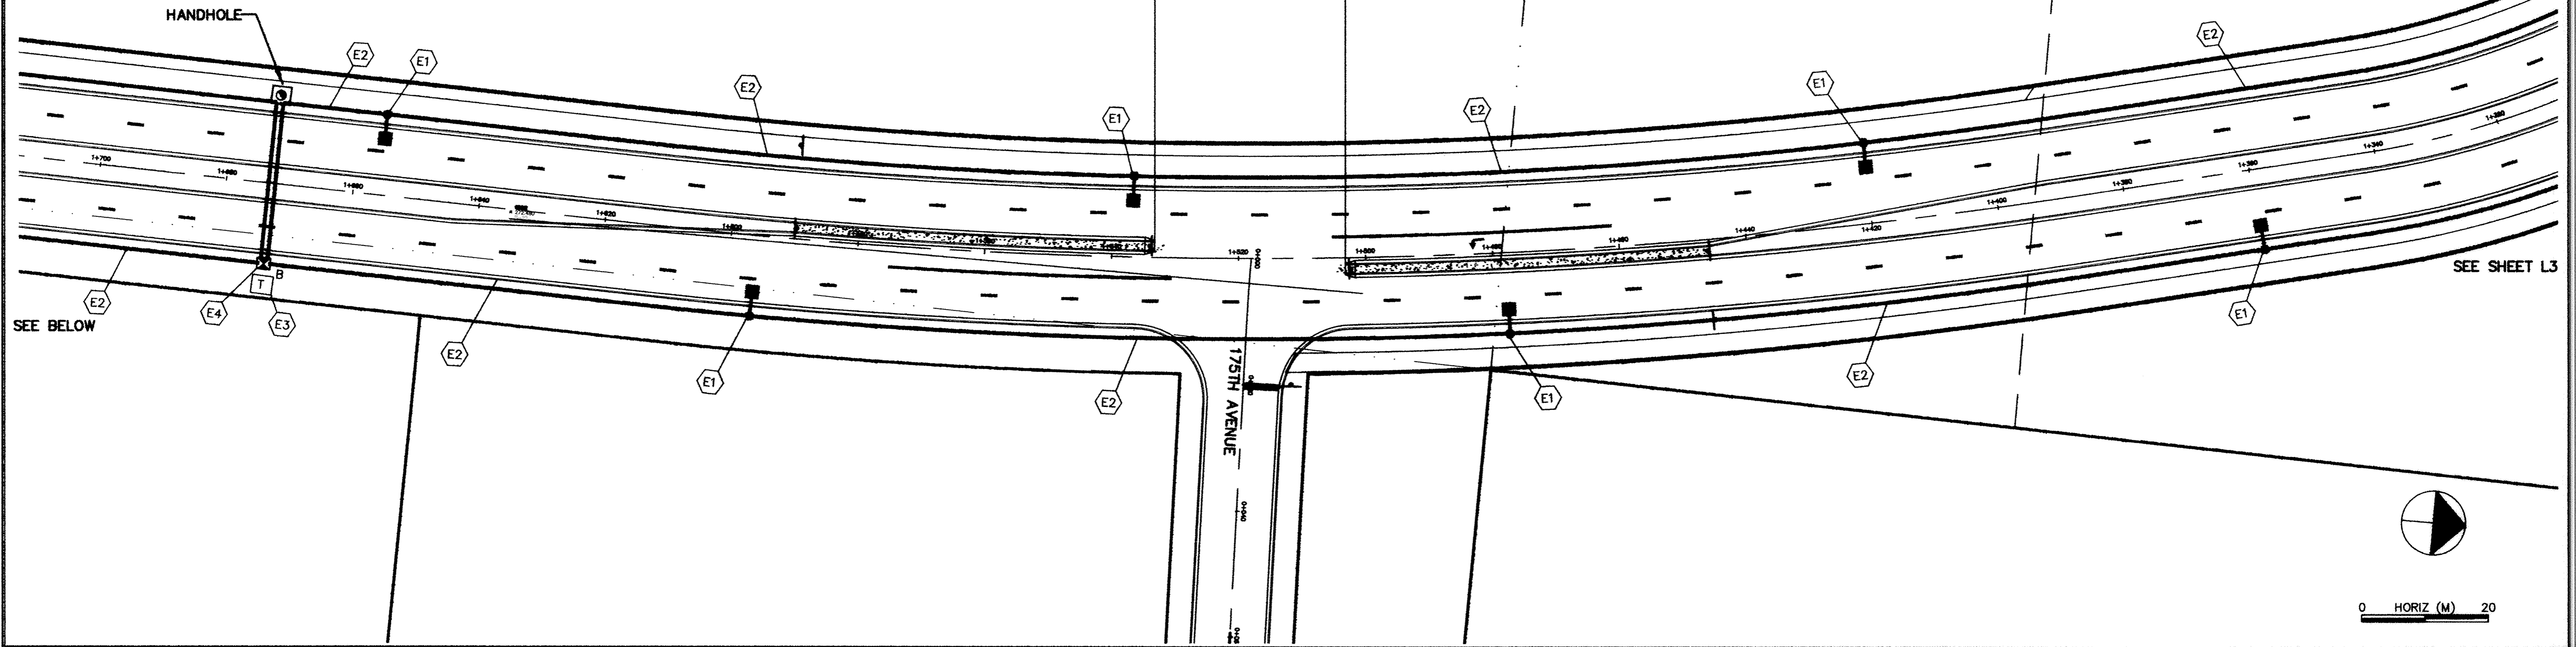

DESIGNED BY: AB JOB DATE: MARCH 1998
 DRAWN BY: *agl* JOB NUMBER: 800110J
 APPROVED: _____ CAD DATE: _____
 CAD FILE: January 06, 2003 9:43:06 a.m.
 800110T\800110J\DWGS\TYLER_LIGHTING\TYLER-LITE3.DWG

I HEREBY CERTIFY THAT THIS PLAN, SPECIFICATION, OR REPORT WAS PREPARED BY ME OR UNDER MY DIRECT SUPERVISION AND THAT I AM A DULY REGISTERED PROFESSIONAL ENGINEER UNDER THE LAWS OF THE STATE OF MINNESOTA.
 DATE: _____ REG. NO. _____

NO.	DATE	BY	REVISION DESCRIPTION

Howard R. Green Company
 CONSULTING ENGINEERS
 1326 ENERGY PARK DRIVE
 ST. PAUL, MINNESOTA 55108
 (612) 644-4369

CITY OF ELK RIVER
 EASTERN AREA
 TYLER STREET IMPROVEMENTS

LIGHTING PLAN
 TYLER STREET S. OF C.S.A.H. 12
 S.P. 204-133-01
 11-320 TO 11-900

SHEET NO.
L4

DRAWING NUMBER
 EASTE 01
 104
 DRAWING NUMBER