


TYLER STREET


SEE SHEET L4

SEE BELOW

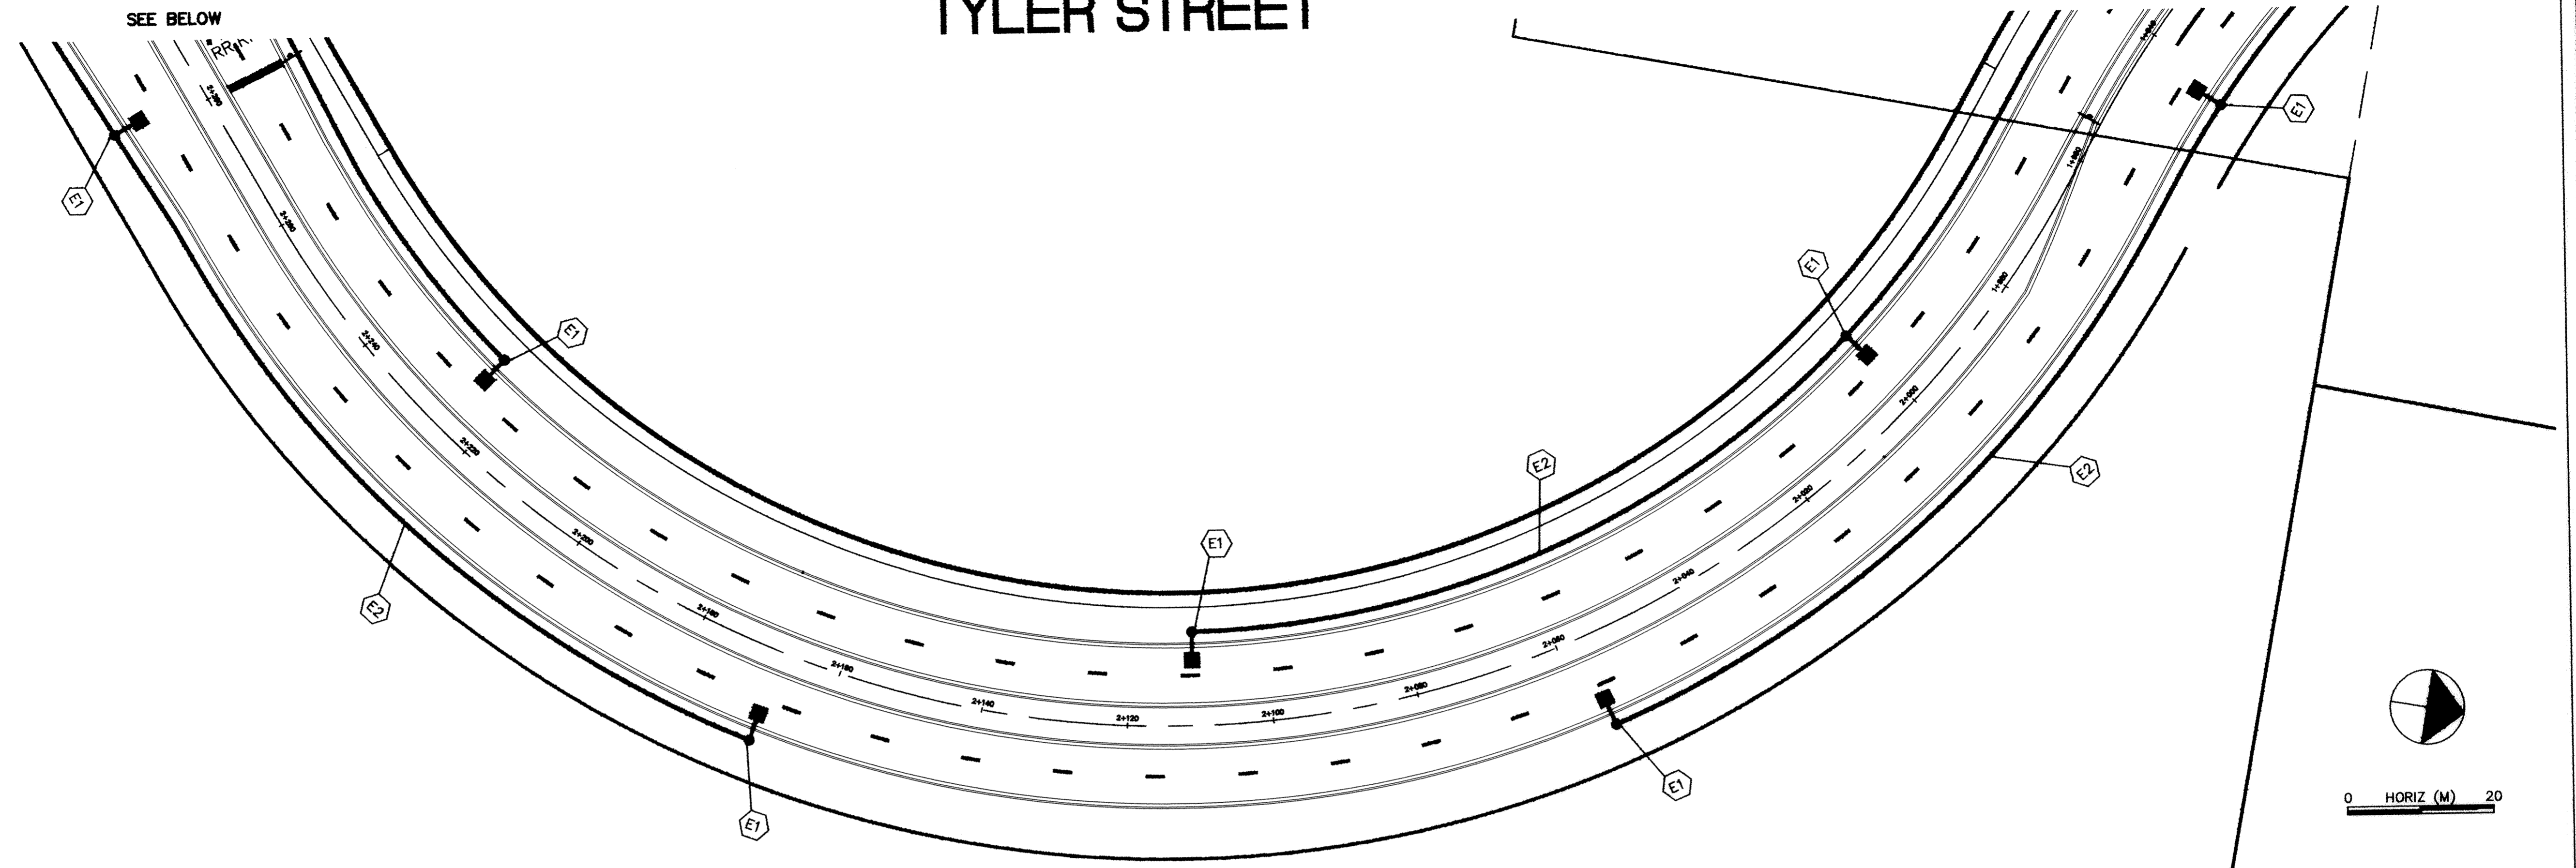

SEE SHEET L6

SEE ABOVE

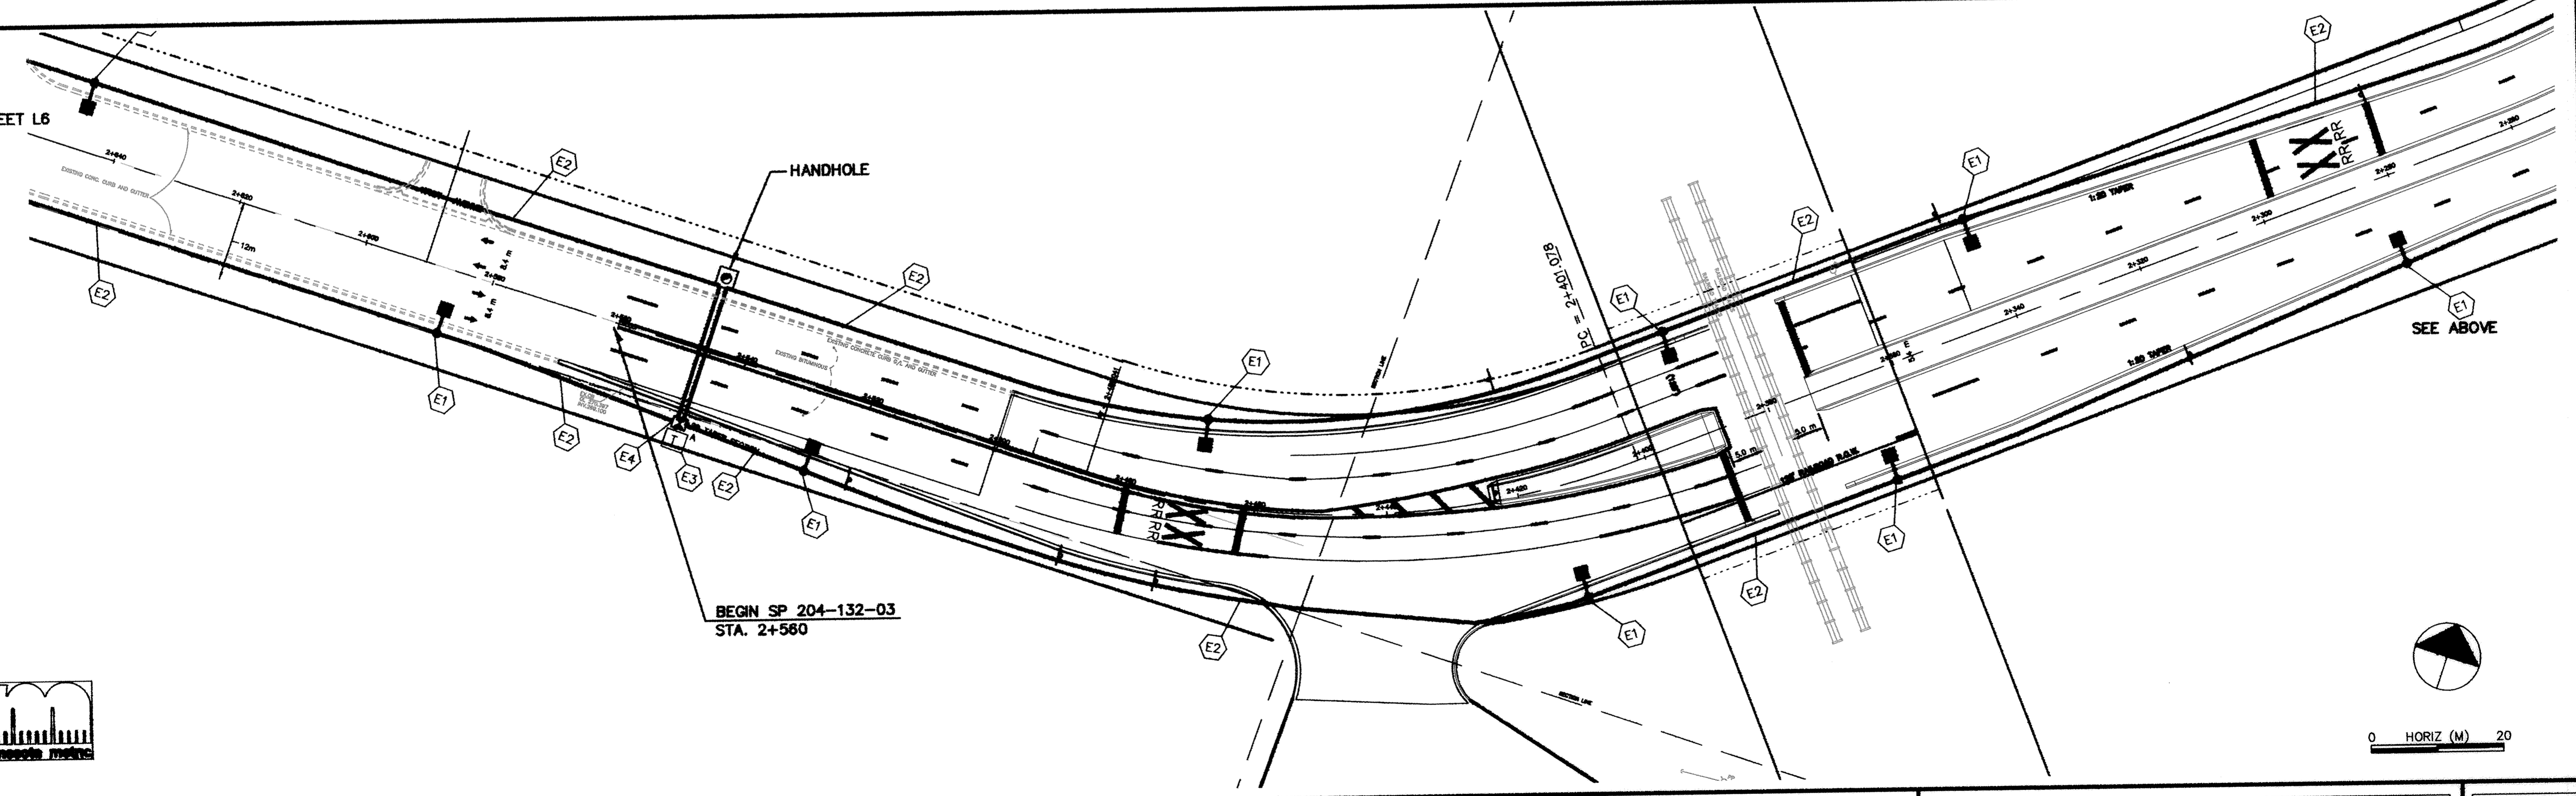

DESIGNED BY: AB JOB DATE: MARCH 1998
 DRAWN BY: [Signature] JOB NUMBER: 800110J
 APPROVED: _____ CAD DATE: _____
 CAD FILE: January 06, 2003 9:54:27 a.m.
 800110J\800110J\DWGS\TYLER_LIGHTING\TYLER-LITE4.DWG

I HEREBY CERTIFY THAT THIS PLAN, SPECIFICATION, OR REPORT WAS PREPARED BY ME OR UNDER MY DIRECT SUPERVISION AND THAT I AM A DULY REGISTERED PROFESSIONAL ENGINEER UNDER THE LAWS OF THE STATE OF MINNESOTA.
 _____ REG. NO. _____

NO.	DATE	BY	REVISION DESCRIPTION

Howard R. Green Company
 CONSULTING ENGINEERS
 1326 ENERGY PARK DRIVE
 ST. PAUL, MINNESOTA 55108
 (612) 644-4388

CITY OF ELK RIVER
 EASTERN AREA
 TYLER STREET IMPROVEMENTS

LIGHTING PLAN
 TYLER STREET AND 171ST AVE.
 S.P. 204-133-01, S.P. 204-132-03
 1+980 TO 2+640

SHEET NO.
L5