
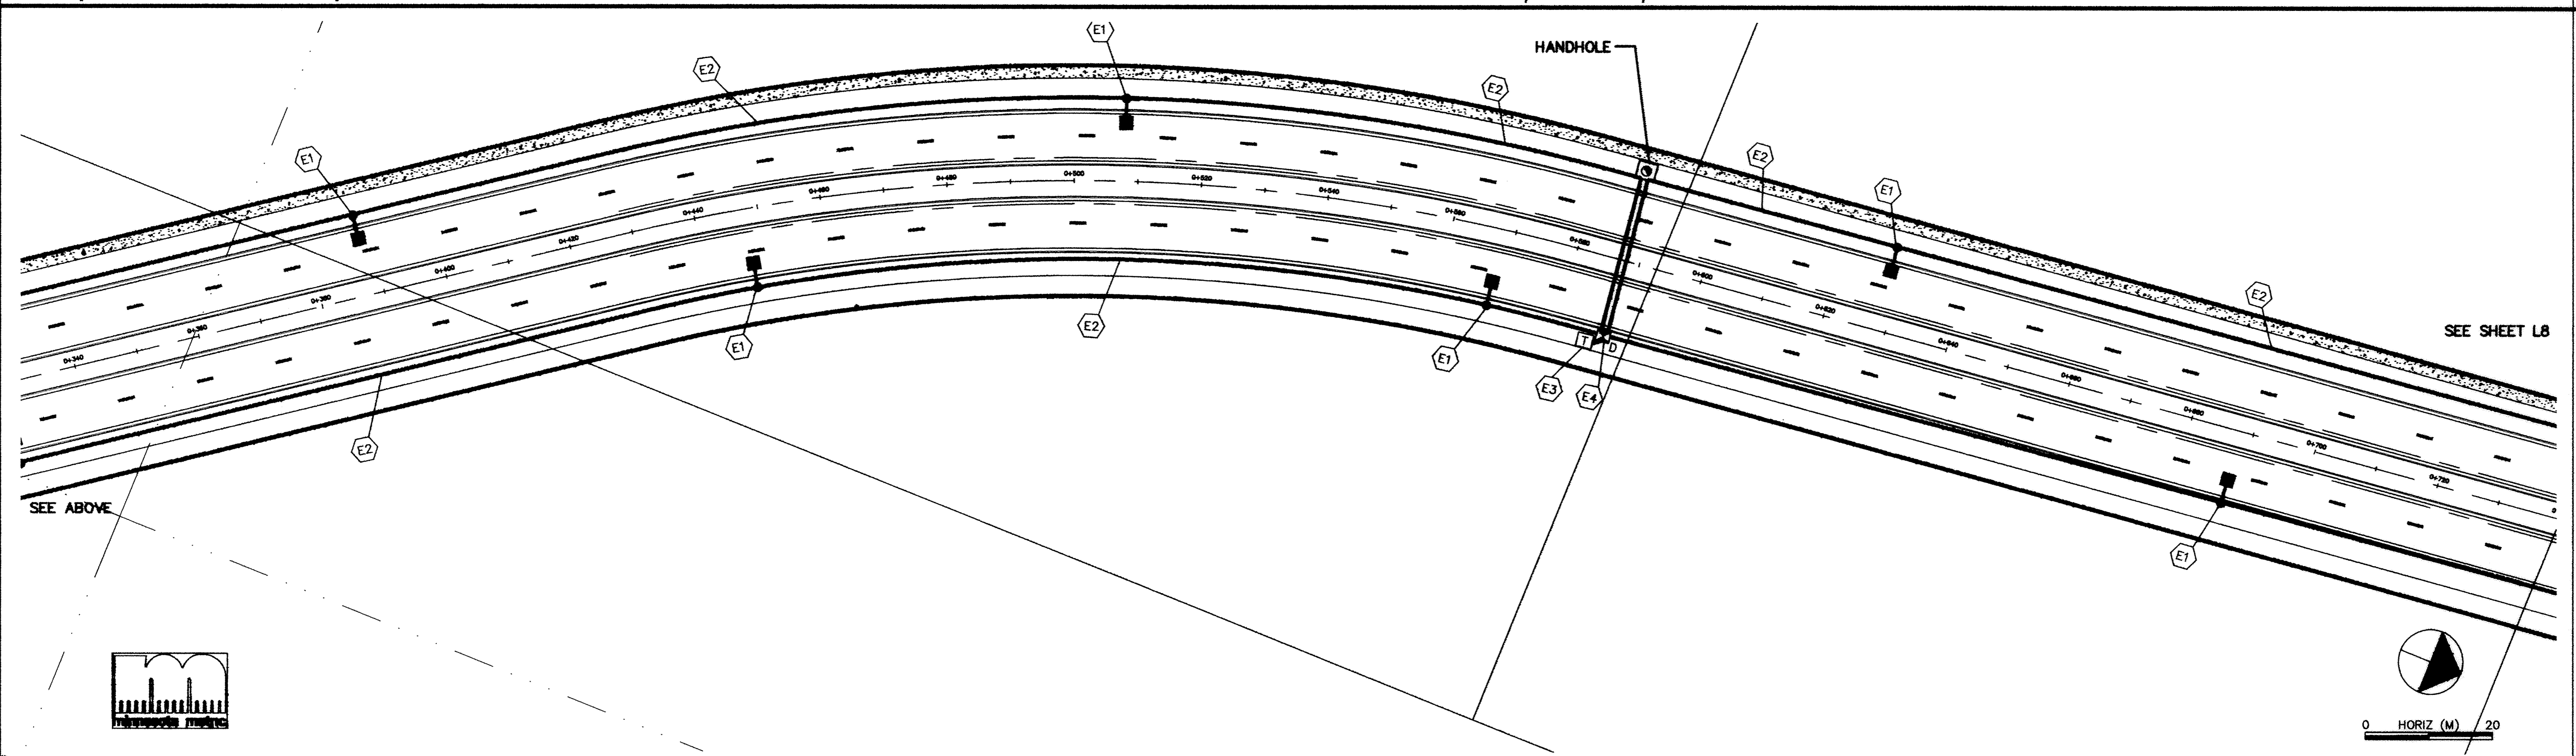


# TYLER STREET

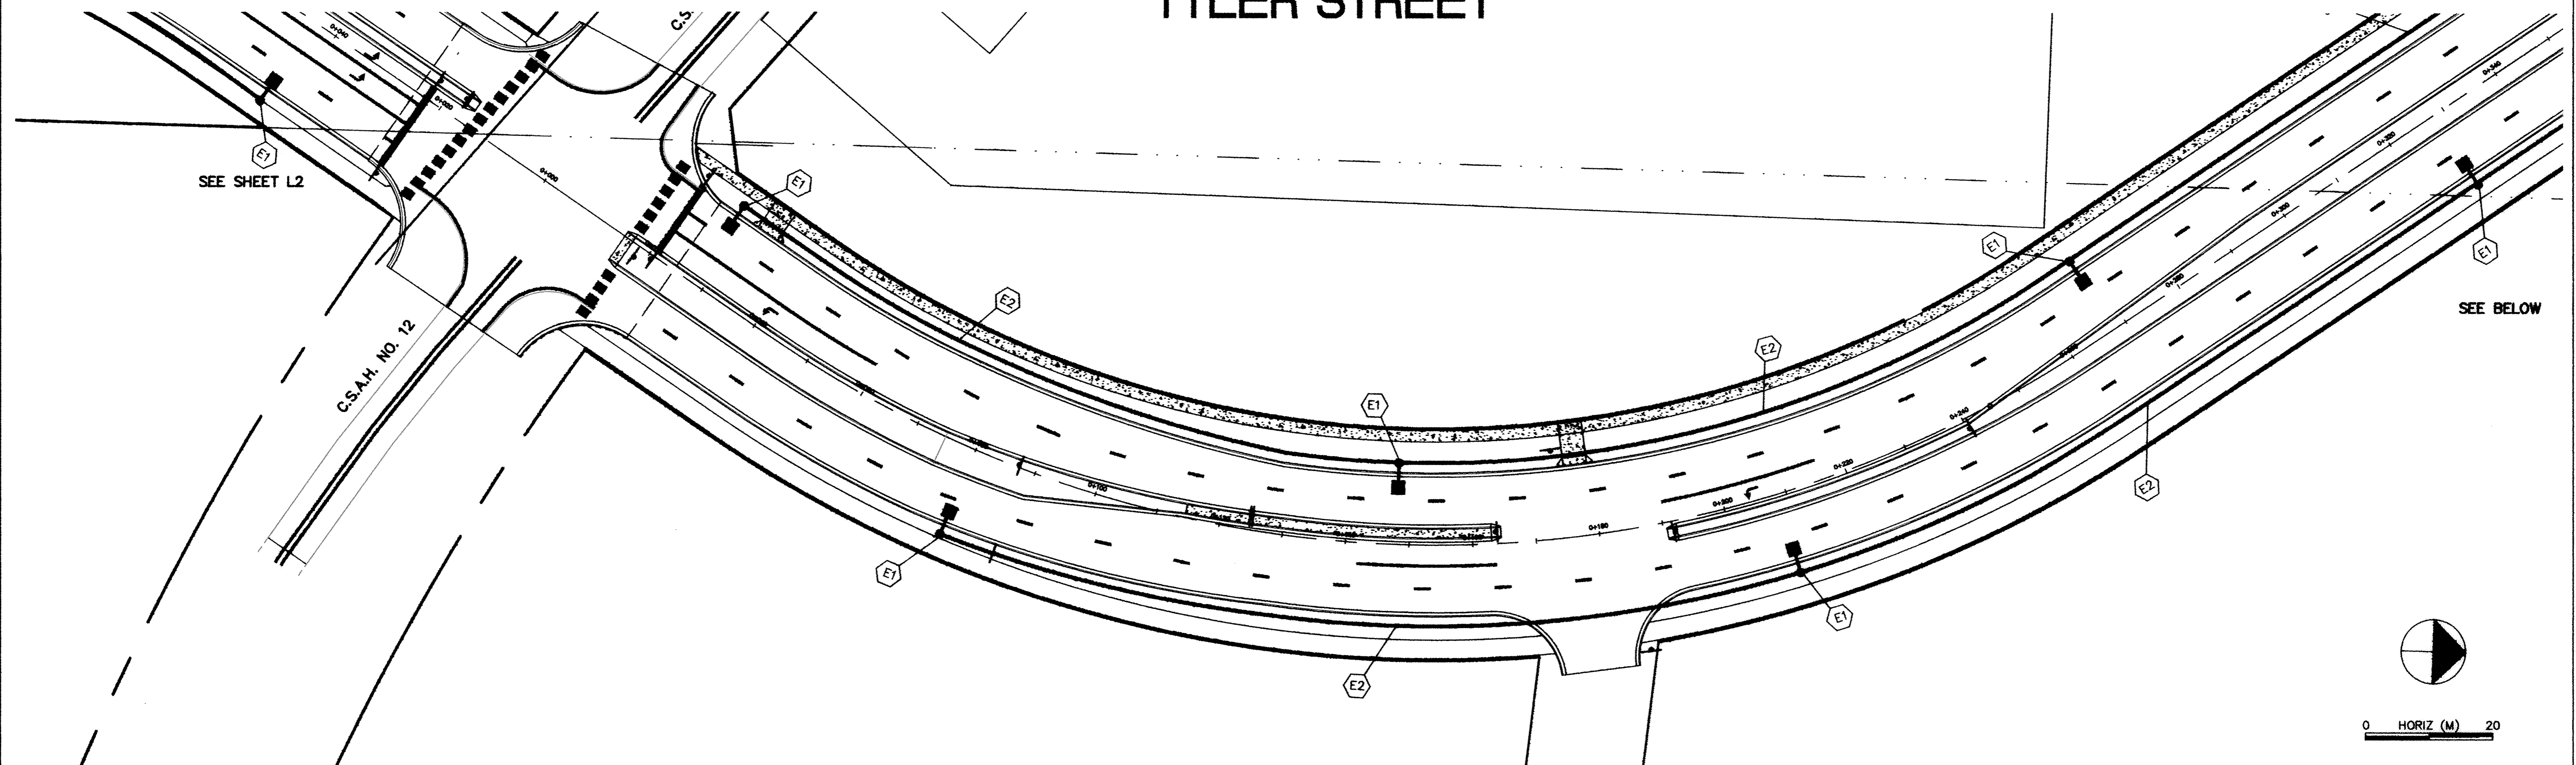

DESIGNED BY: AB JOB DATE: MARCH 1998  
 DRAWN BY: *afj* JOB NUMBER: 800110J  
 APPROVED: \_\_\_\_\_ CAD DATE: \_\_\_\_\_  
 CAD FILE: January 06, 2003 10:03:05 a.m.  
 800110J\800110J\DWGS\TYLER\_LIGHTING\TYLER-LITE6.DWG

I HEREBY CERTIFY THAT THIS PLAN, SPECIFICATION, OR REPORT WAS PREPARED BY ME OR UNDER MY DIRECT SUPERVISION AND THAT I AM A DULY REGISTERED PROFESSIONAL ENGINEER UNDER THE LAWS OF THE STATE OF MINNESOTA.

DATE: \_\_\_\_\_ REG. NO. \_\_\_\_\_

NO.	DATE	BY	REVISION DESCRIPTION



**Howard R. Green Company**  
 CONSULTING ENGINEERS

1326 ENERGY PARK DRIVE  
 ST. PAUL, MINNESOTA 55108  
 (612) 644-4389

**CITY OF ELK RIVER**  
 EASTERN AREA  
 TYLER STREET IMPROVEMENTS

**LIGHTING PLAN**  
 TYLER STREET N. OF C.S.A.H. 12  
 S.P. 204-020-03 04:000 TO 04:720

SHEET NO.  
**L7**