
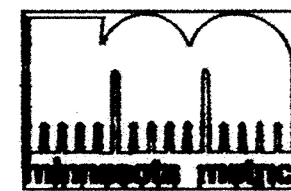


# TYLER STREET

SEE SHEET L6

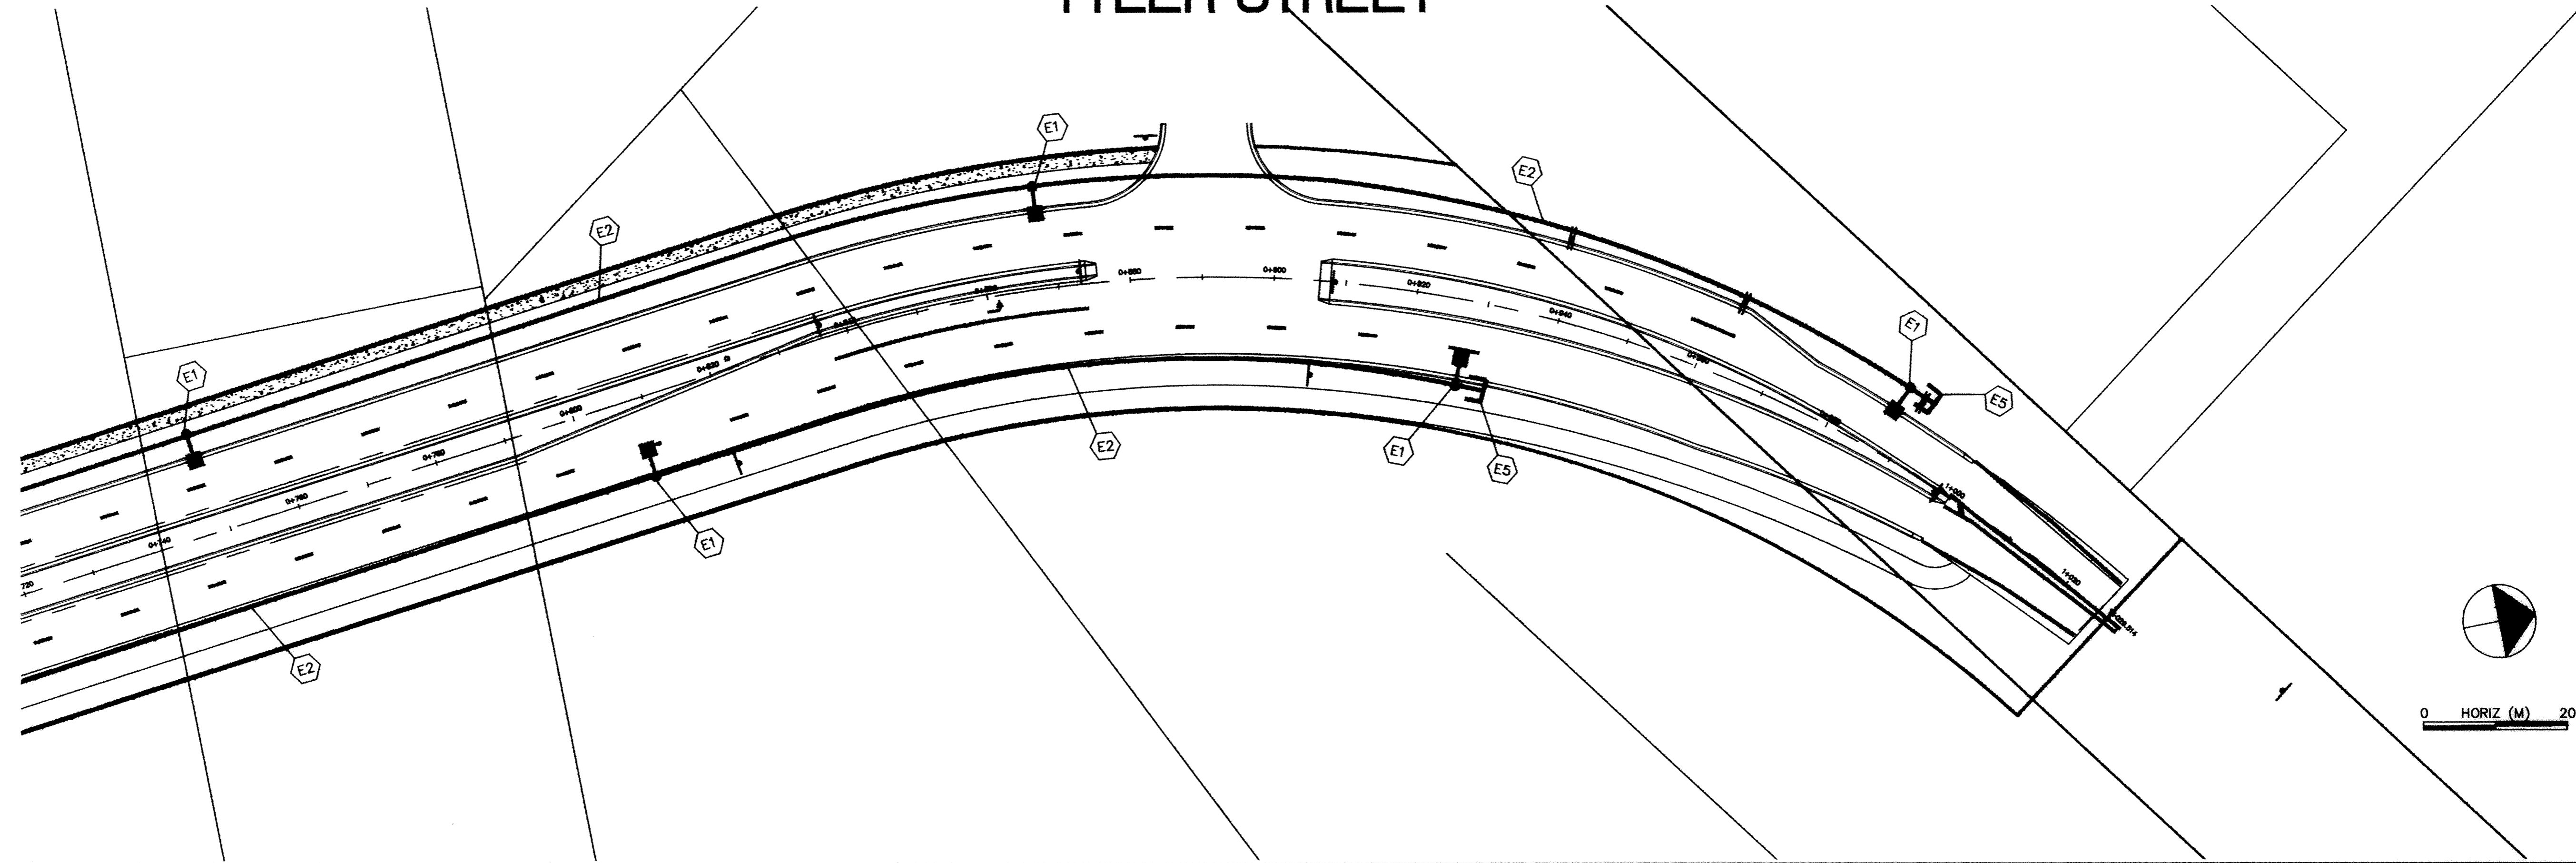

DESIGNED BY: AB JOB DATE: MARCH 1998  
 DRAWN BY: *CH* JOB NUMBER: 800110J  
 APPROVED: \_\_\_\_\_ CAD DATE: \_\_\_\_\_  
 CAD FILE: January 08, 2003 10:05:01 a.m.  
 800110T\800110J\DWGS\TYLER\_LIGHTING\TYLER-LITE7.DWG

I HEREBY CERTIFY THAT THIS PLAN, SPECIFICATION, OR REPORT WAS PREPARED BY ME OR UNDER MY DIRECT SUPERVISION AND THAT I AM A DULY REGISTERED PROFESSIONAL ENGINEER UNDER THE LAWS OF THE STATE OF MINNESOTA.

DATE: \_\_\_\_\_ REG. NO. \_\_\_\_\_

NO.	DATE	BY	REVISION DESCRIPTION



1326 ENERGY PARK DRIVE  
 ST. PAUL, MINNESOTA 55108  
 (612) 644-4389  
**Howard R. Green Company**  
 CONSULTING ENGINEERS

**CITY OF ELK RIVER**  
**EASTERN AREA**  
**TYLER STREET IMPROVEMENTS**

**LIGHTING PLAN**  
**TYLER STREET N. OF C.S.A.H.12**  
 S.P. 204-020-03 0+720 TO 1+021.527

SHEET NO.  
**L8**

DRAWING NUMBER: EASTE.01  
 SHEET NO.: 108  
 PROJECT: TYLER STREET IMPROVEMENTS  
 LOCATION: EASTERN AREA, CITY OF ELK RIVER, MN  
 DATE: MARCH 1998  
 DRAWN BY: CH  
 CHECKED BY: AB  
 APPROVED BY: \_\_\_\_\_  
 LICENSE NO.: \_\_\_\_\_  
 REG. NO.: \_\_\_\_\_