


TYLER STREET

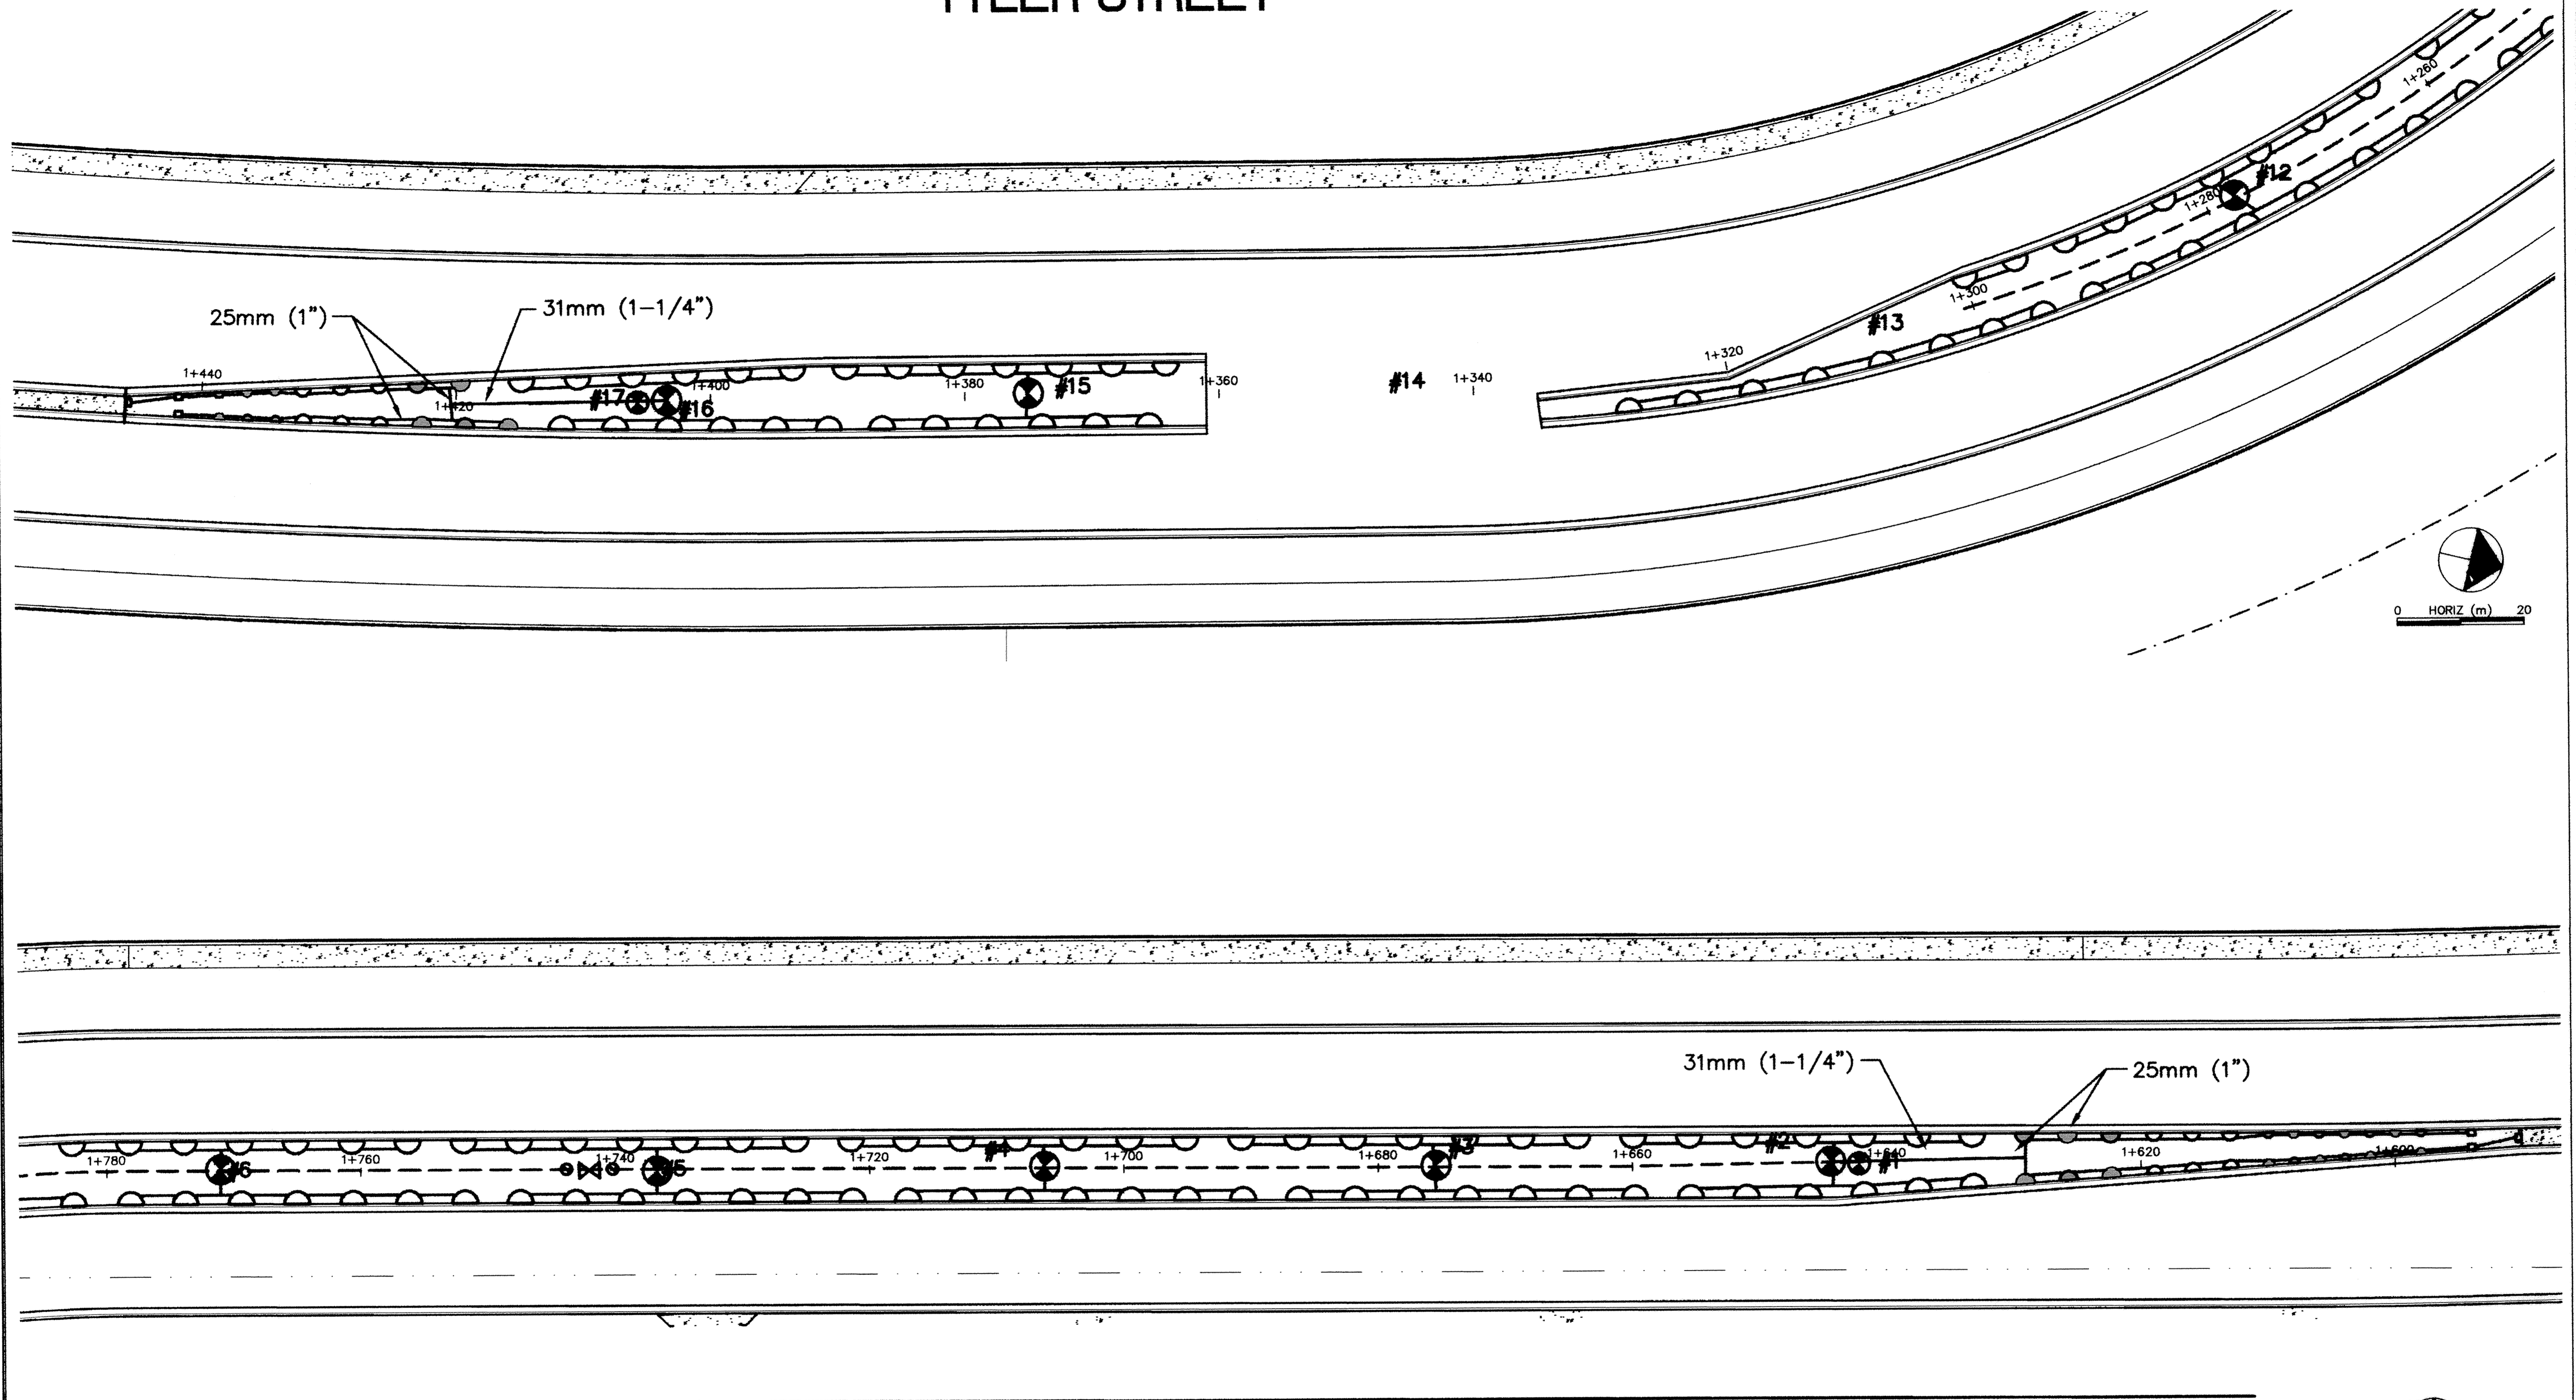


DRAWING NUMBER 112 EAST E.01

DRAWING NUMBER 112 EAST E.01

DRAWING NUMBER 112 EAST E.01

DRAWING NUMBER 112 EAST E.01

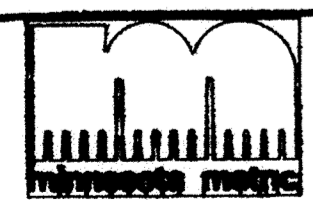

DESIGNED BY: AB JOB DATE: DECEMBER 1998
 DRAWN BY: [signature] JOB NUMBER 800110J
 APPROVED: _____ CAD DATE: _____
 CAD FILE: January 06, 2003 10:07:58 a.m.
 800110T\800110J\DWGS\TYLER_SPRINKLER\CHANGED_SPRINKLERS.DWG (GLAZEN)

I HEREBY CERTIFY THAT THIS PLAN, SPECIFICATION, OR REPORT WAS PREPARED BY ME OR UNDER MY DIRECT SUPERVISION AND THAT I AM A DULY REGISTERED PROFESSIONAL ENGINEER UNDER THE LAWS OF THE STATE OF MINNESOTA.

NO.	DATE	BY	REVISION DESCRIPTION
1	7-28-00	TSN	ADDED LEFT TURN LANE FROM 1+300-361

1326 ENERGY PARK DRIVE
 ST. PAUL, MINNESOTA 55108
 (651) 644-4388



Howard R Green Company
 CONSULTING ENGINEERS

CITY OF ELK RIVER
 EASTERN AREA
 TYLER STREET IMPROVEMENTS

SPRINKLER PLAN

1+260 TO 1+460
 1+580 TO 1+780

SP 71-613-08, SP 204-020-03, SP 204-133-01, SP 204-132-03

SHEET NO.
M4