
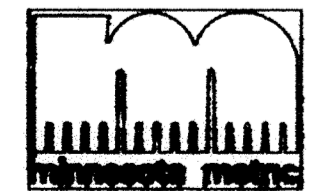
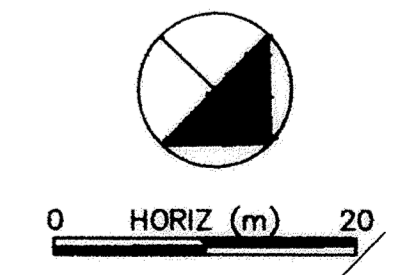
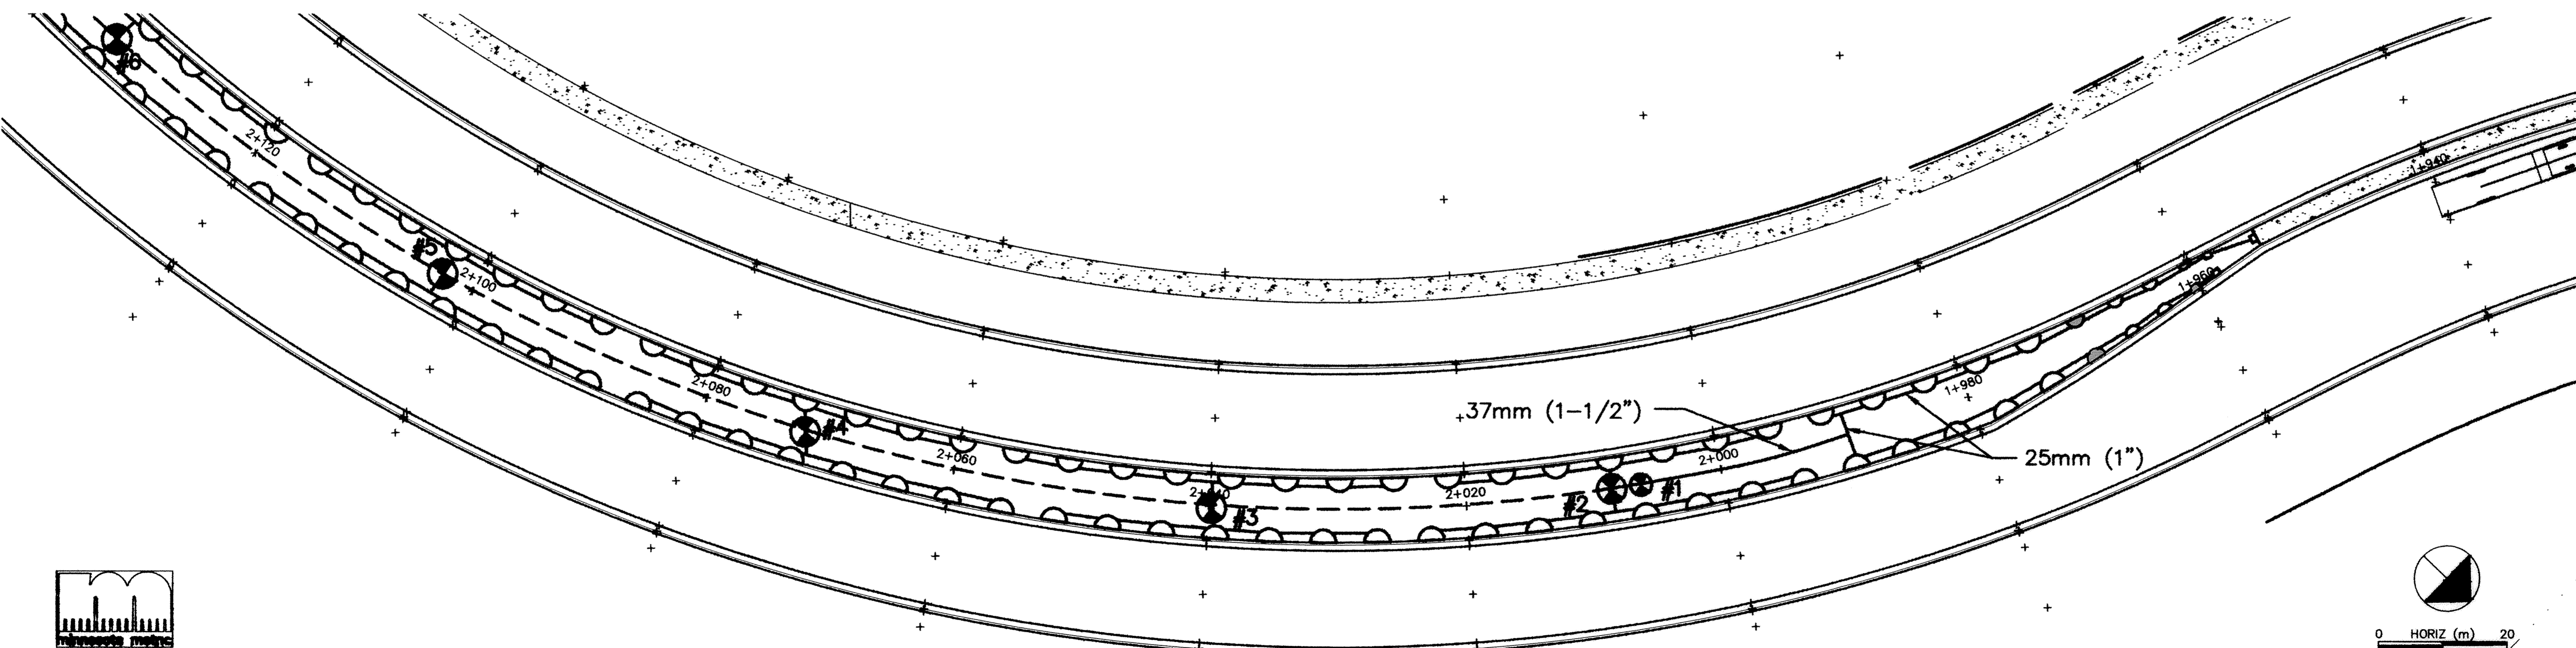
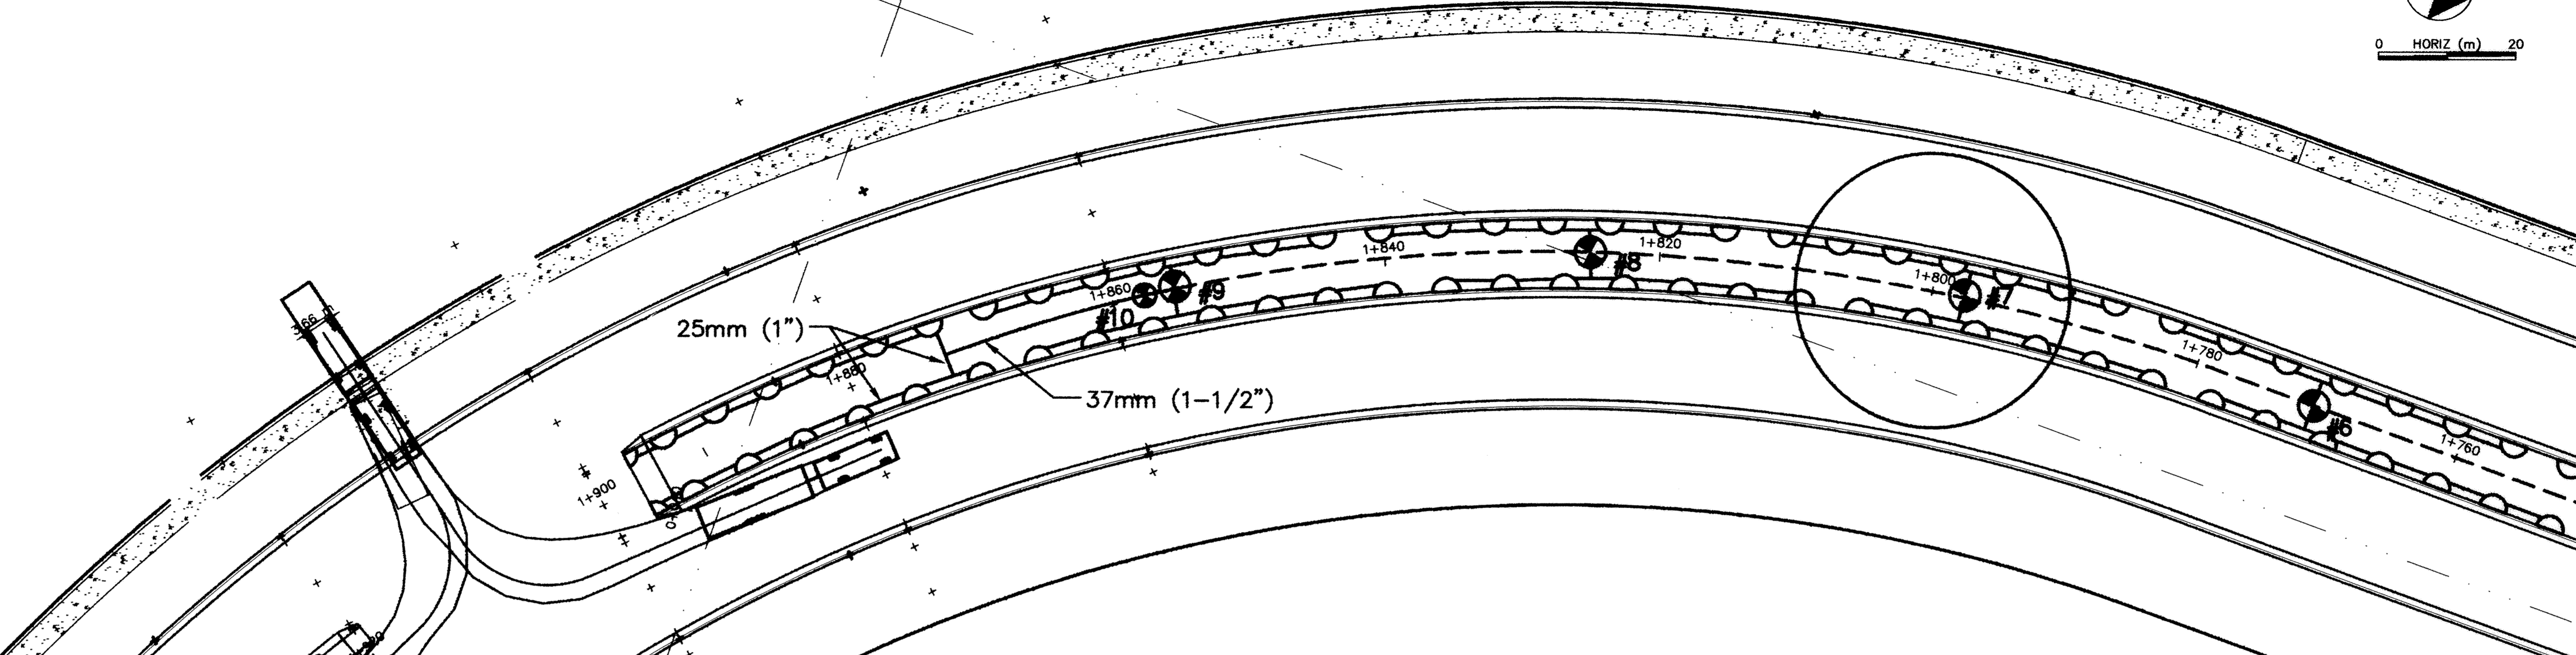


TYLER STREET

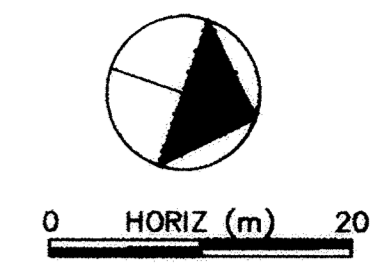

DESIGNED BY: AB JOB DATE: DECEMBER 1998
 DRAWN BY: JGJ JOB NUMBER: 800110J
 APPROVED: _____ CAD DATE: _____
 CAD FILE: January 08, 2003 10:49:47 a.m.
 800110J\800110J\DWGS\TYLER_SPRINKLER\M5.DWG (JLALLEN)

I HEREBY CERTIFY THAT THIS PLAN, SPECIFICATION, OR REPORT WAS PREPARED BY ME OR UNDER MY DIRECT SUPERVISION AND THAT I AM A DULY REGISTERED PROFESSIONAL ENGINEER UNDER THE LAWS OF THE STATE OF MINNESOTA.

DATE _____ REG. NO. _____

NO.	DATE	BY	REVISION DESCRIPTION

1326 ENERGY PARK DRIVE
 ST. PAUL, MINNESOTA 55108
 (651) 644-4388



Howard R. Green Company
 CONSULTING ENGINEERS

CITY OF ELK RIVER
EASTERN AREA
TYLER STREET IMPROVEMENTS

SPRINKLER PLAN

1+780 TO 1+900
 1+940 TO 2+120

SP 71-613-08, SP 204-020-03, SP 204-133-01, SP 204-132-03

SHEET NO.
M5

DRAWING NUMBER

DRAWING NUMBER

DRAWING NUMBER

DRAWING NUMBER

EAST E 01

DRAWING NUMBER

SDCO PRODUCTS • NEW HOPE, MINNESOTA
 PREPARED BY: PAUL HAMBER (651) 656-6388