


TYLER STREET

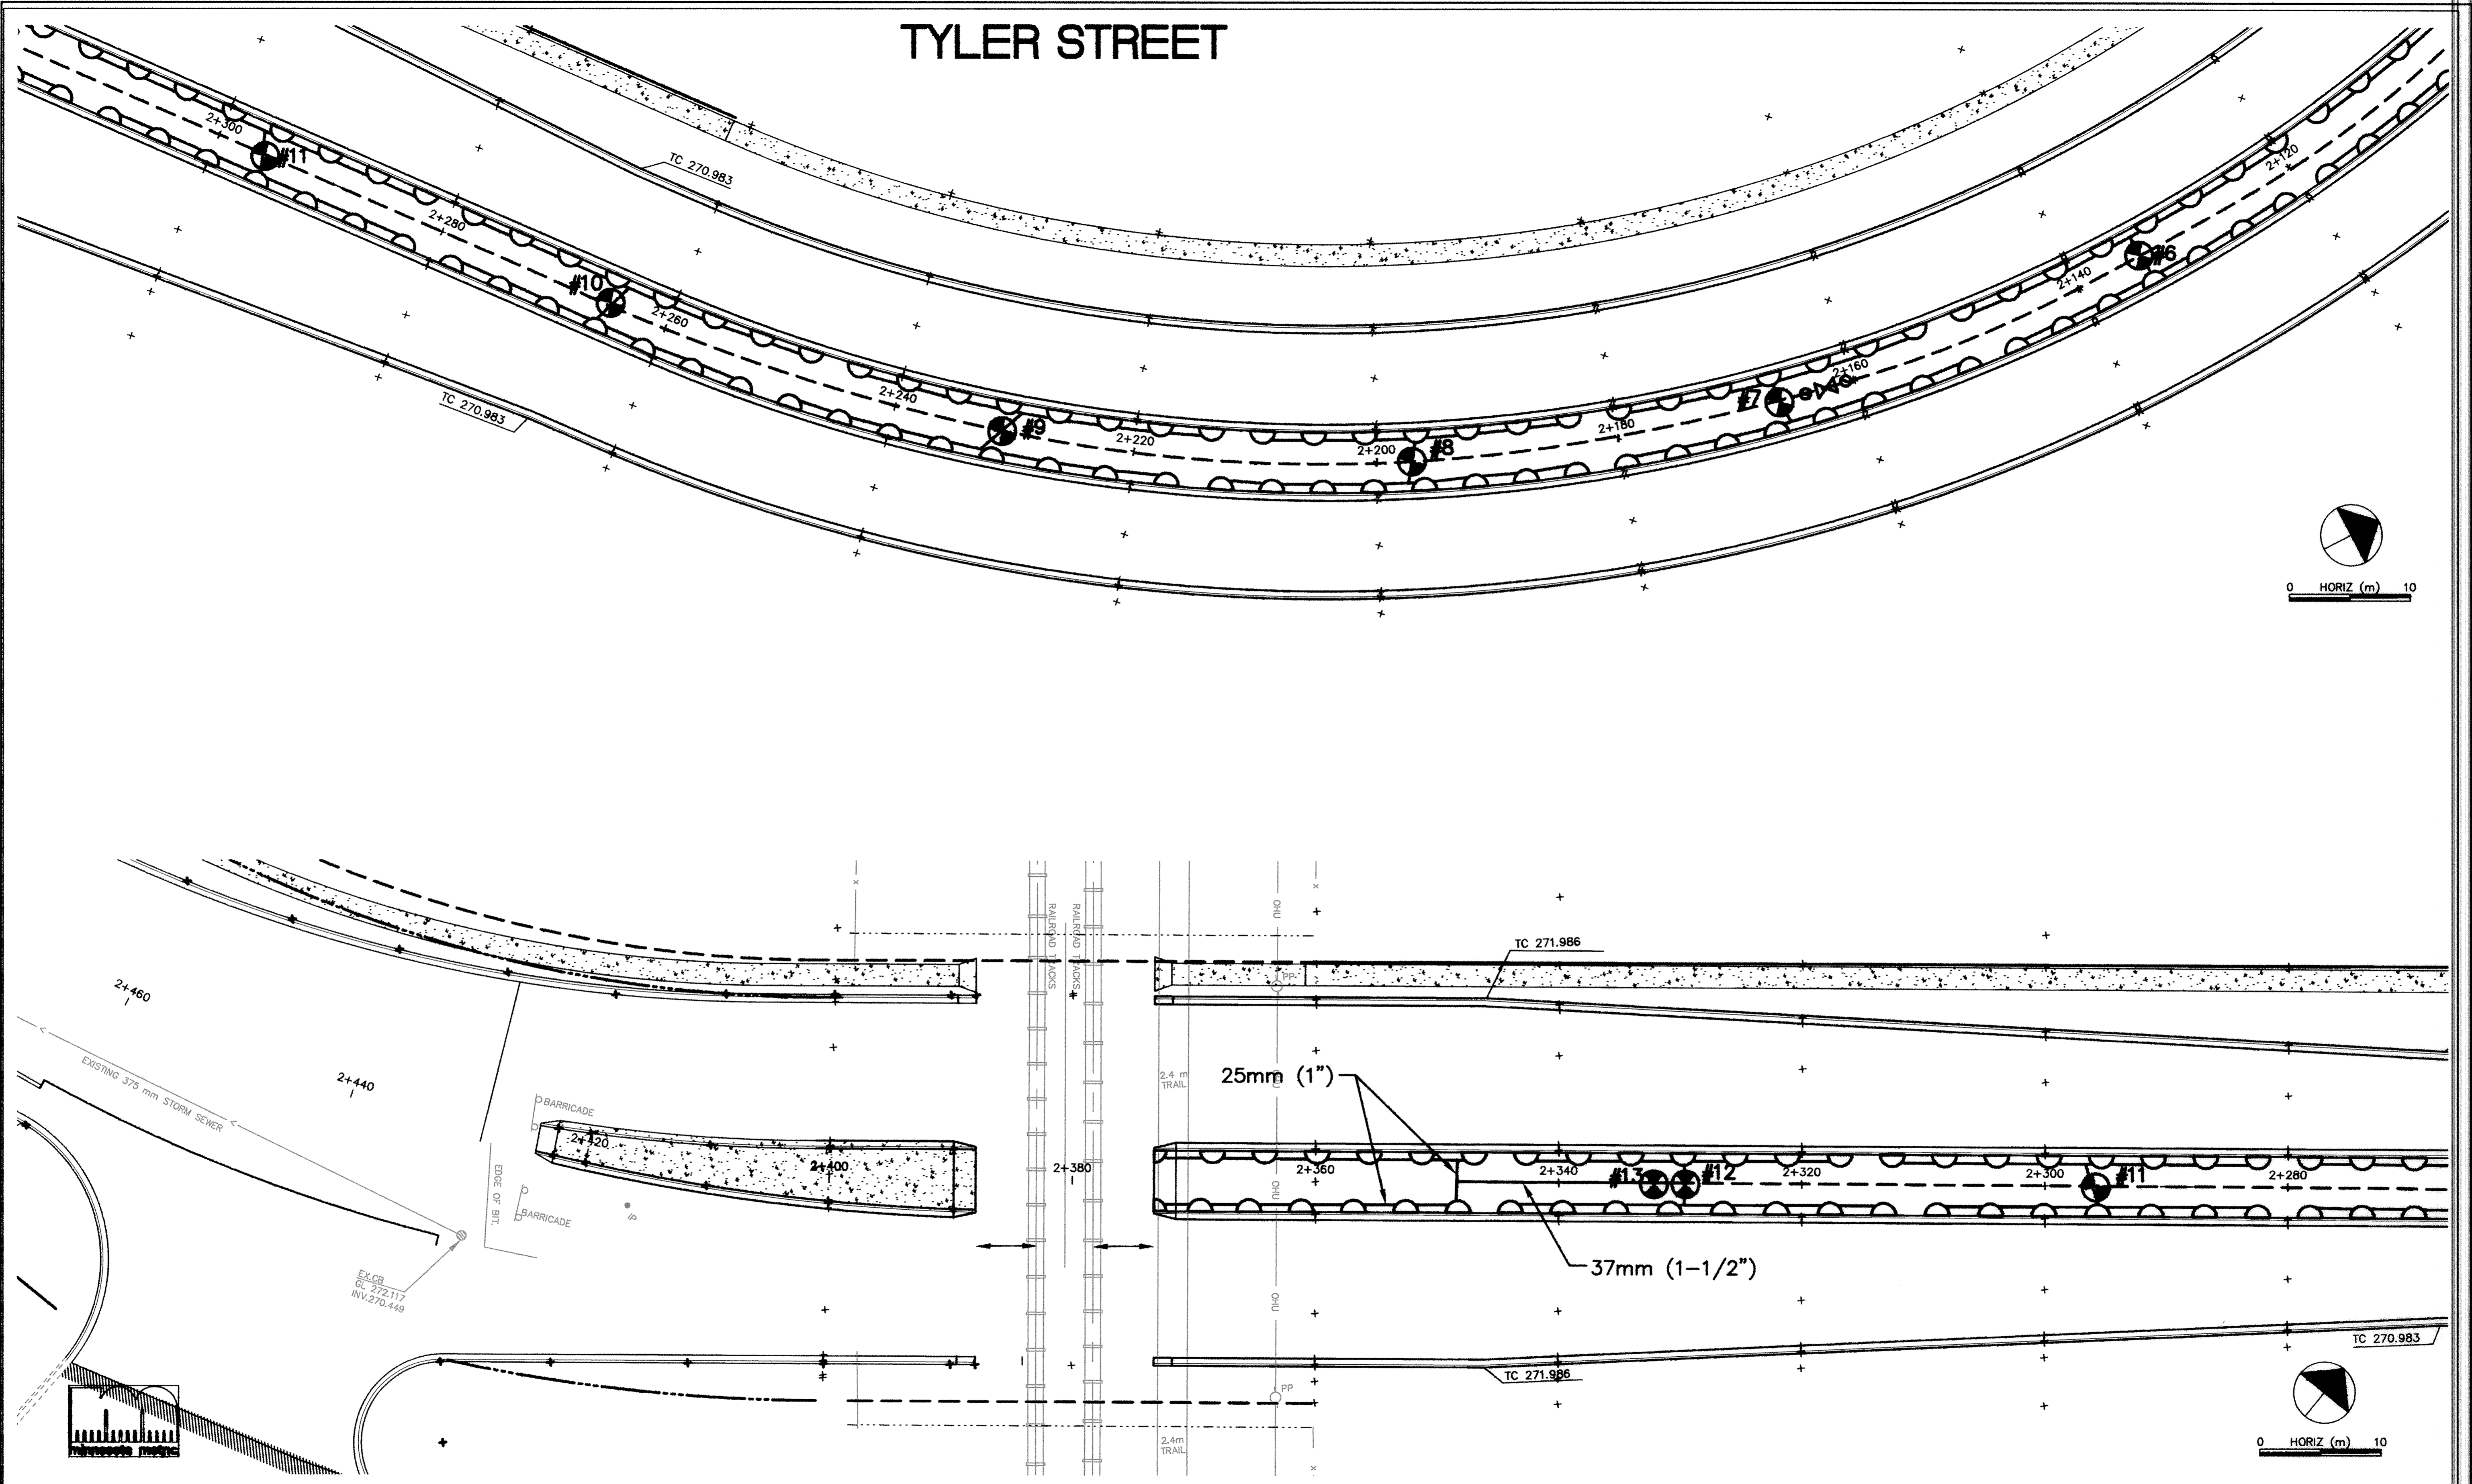

DESIGNED BY: AB JOB DATE: DECEMBER 1998
 DRAWN BY: *[Signature]* JOB NUMBER 800110J
 APPROVED: _____ CAD DATE: _____
 CAD FILE: January 08, 2003 7:44:47 a.m.
 800110T\800110J\DWGS\TYLER_SPRINKLER\M6.DWG (JLLEN)

I HEREBY CERTIFY THAT THIS PLAN, SPECIFICATION, OR REPORT WAS PREPARED BY ME OR UNDER MY DIRECT SUPERVISION AND THAT I AM A DULY REGISTERED PROFESSIONAL ENGINEER UNDER THE LAWS OF THE STATE OF MINNESOTA.
 DATE _____ REG. NO. _____

NO.	DATE	BY	REVISION DESCRIPTION

Howard R. Green Company
 CONSULTING ENGINEERS
 1326 ENERGY PARK DRIVE
 ST. PAUL, MINNESOTA 55106
 (651) 644-4389

CITY OF ELK RIVER
 EASTERN AREA
 TYLER STREET IMPROVEMENTS

SPRINKLER PLAN
 2+120 TO 2+380
 SP 71-613-08, SP 204-020-03, SP 204-133-01, SP 204-132-03

SHEET NO.
M6