
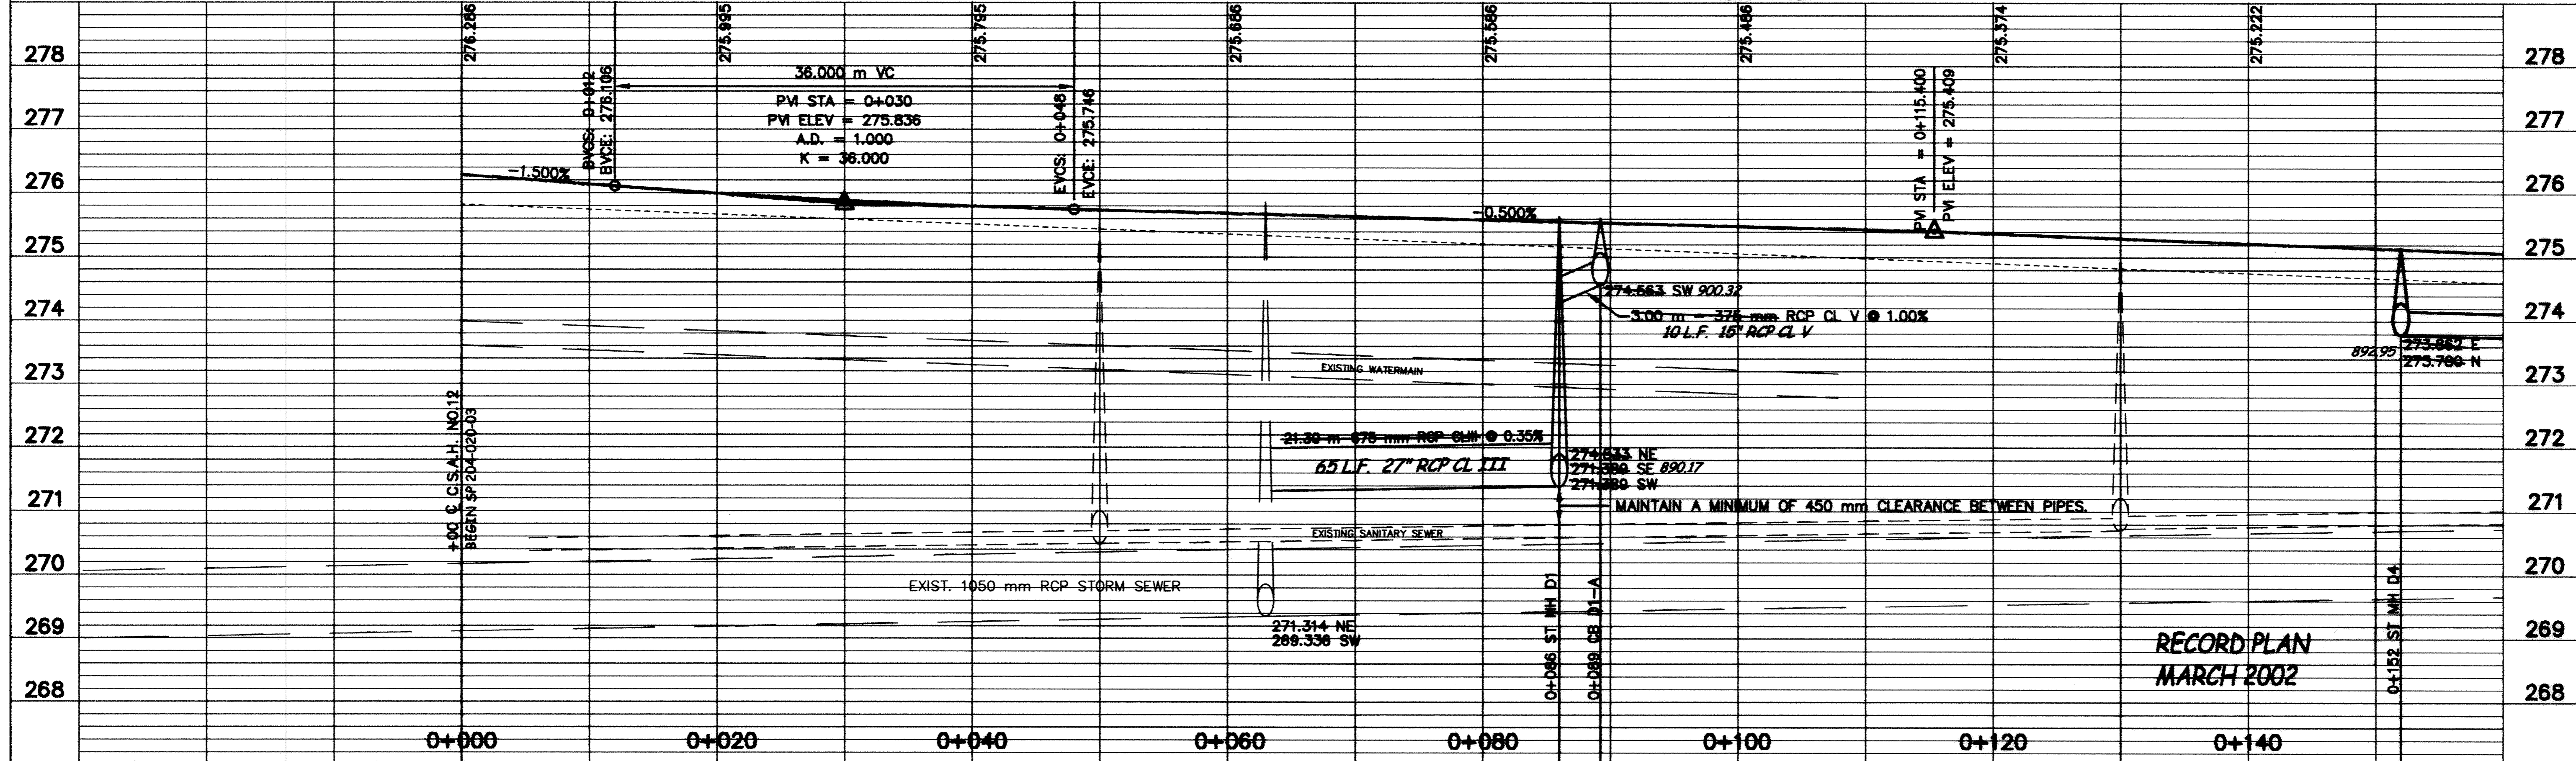
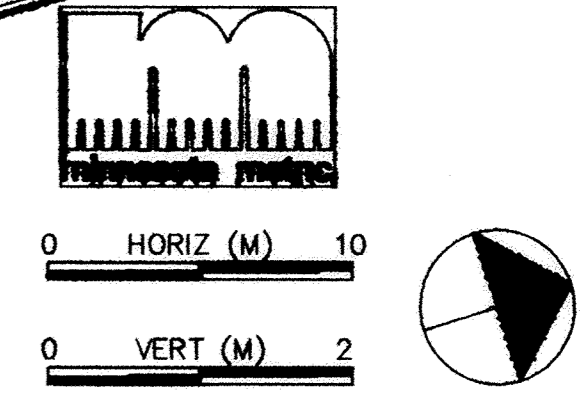


TYLER STREET

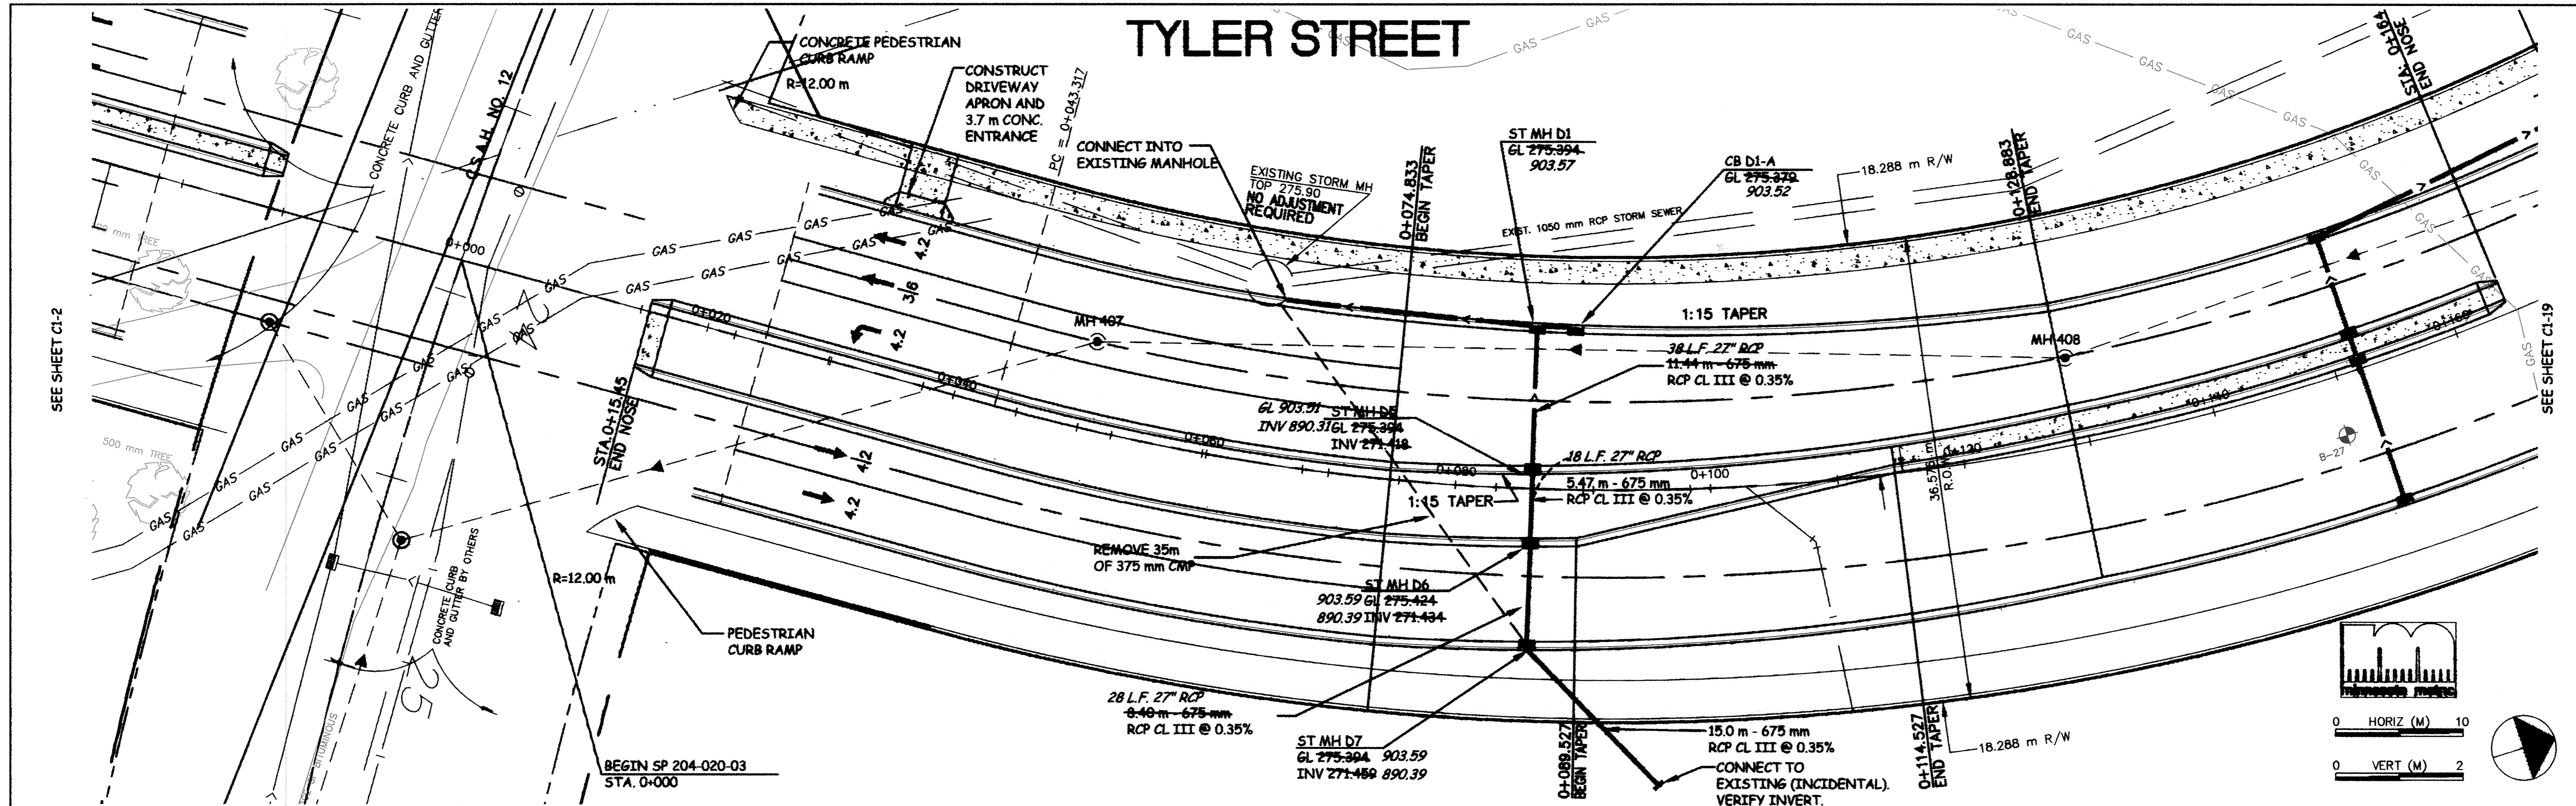

**RECORD PLAN
MARCH 2002**

DESIGNED BY: --- DRAWN BY: *WJL*
 APPROVED: --- JOB NUMBER 800110J
 CAD DATE: April 17, 2002 3:30:33 p.m.
 CAD FILE: 800110T\asbuilts\N SEGMENT_01.DWG

I HEREBY CERTIFY THAT THIS PLAN, SPECIFICATION, OR REPORT WAS PREPARED BY ME OR UNDER MY DIRECT SUPERVISION AND THAT I AM A DULY REGISTERED PROFESSIONAL ENGINEER UNDER THE LAWS OF THE STATE OF MINNESOTA.
 DATE _____ REG. NO. _____

NO.	DATE	BY	REVISION DESCRIPTION
1.	11-8-99	RM	REVISE STORM SEWER

1326 ENERGY PARK DRIVE
 ST. PAUL, MINNESOTA 55108
 (612) 644-4389

Howard R. Green Company
 CONSULTING ENGINEERS

CITY OF ELK RIVER
 EASTERN AREA
 TYLER STREET IMPROVEMENTS

PLAN AND PROFILE NORTH OF CSAH 12
 SP 71-613-08, SP 204-020-03, SP 204-133-01, SP 204-132-03
 0+000 TO 0+140

SHEET NO.
C1-18

DRAWING NUMBER EAST: 01