
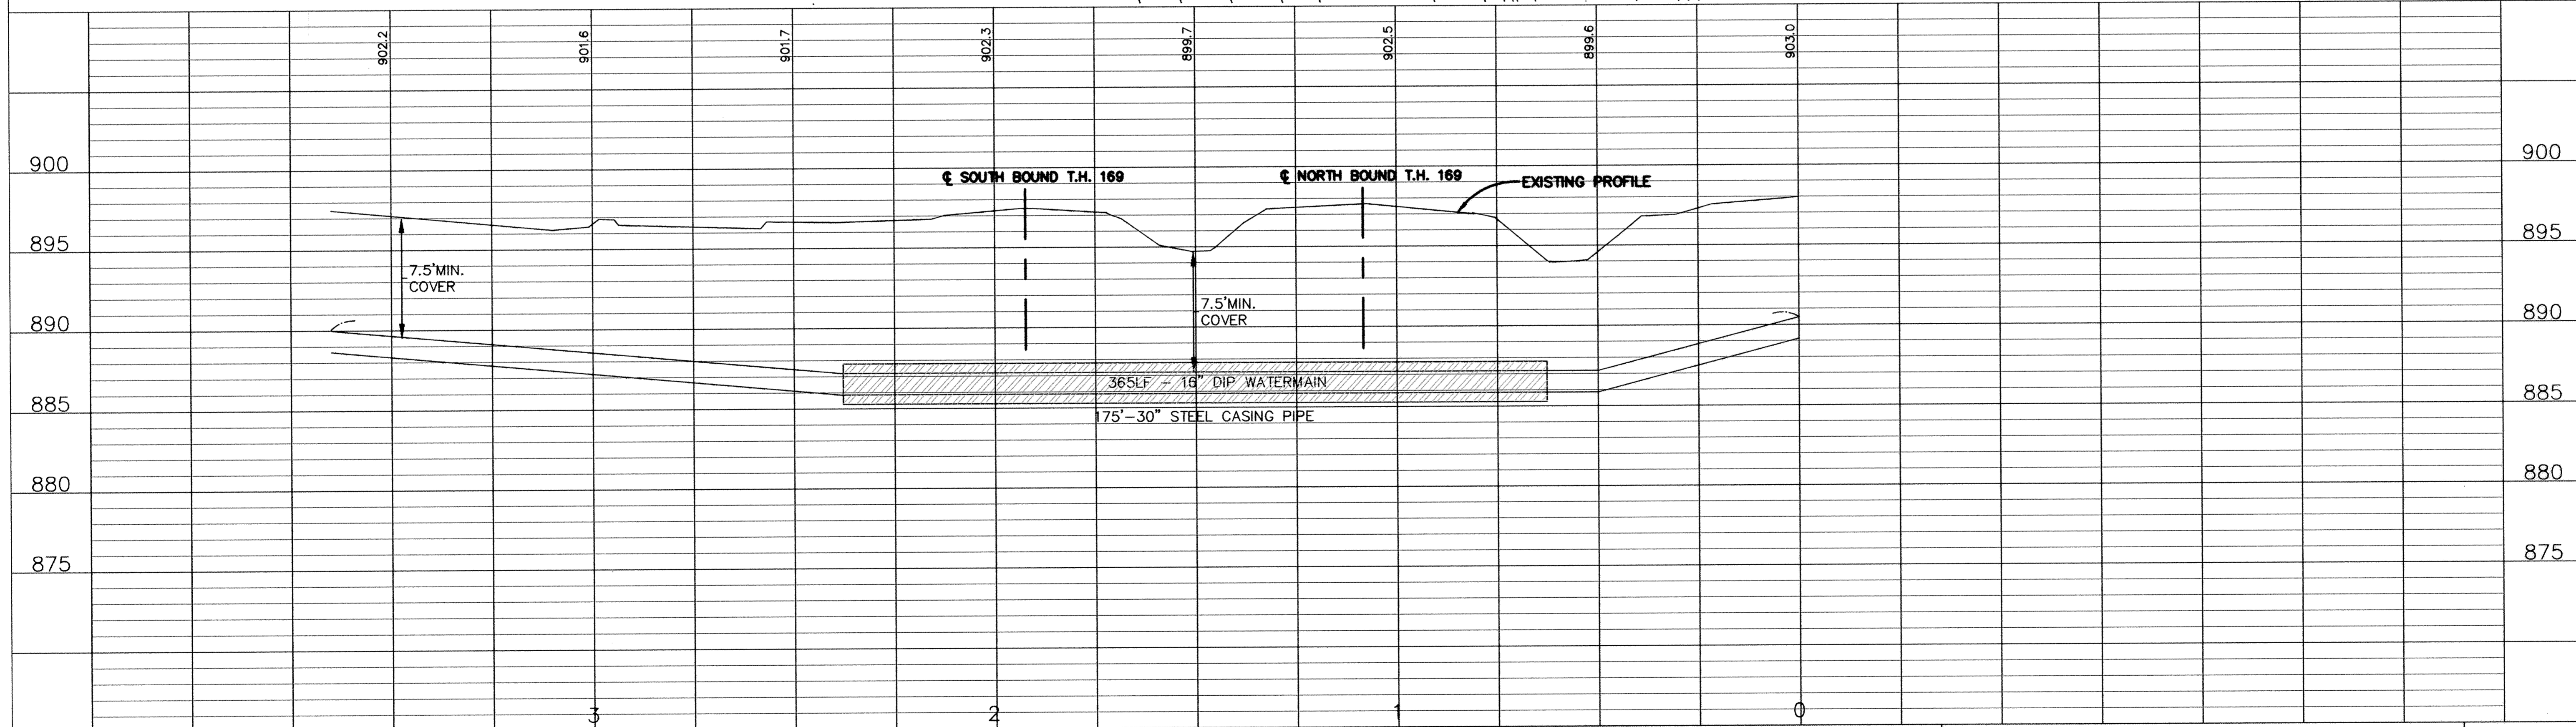
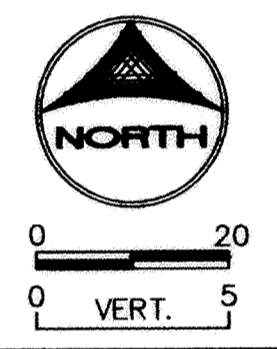


# WATERMAIN JACKING

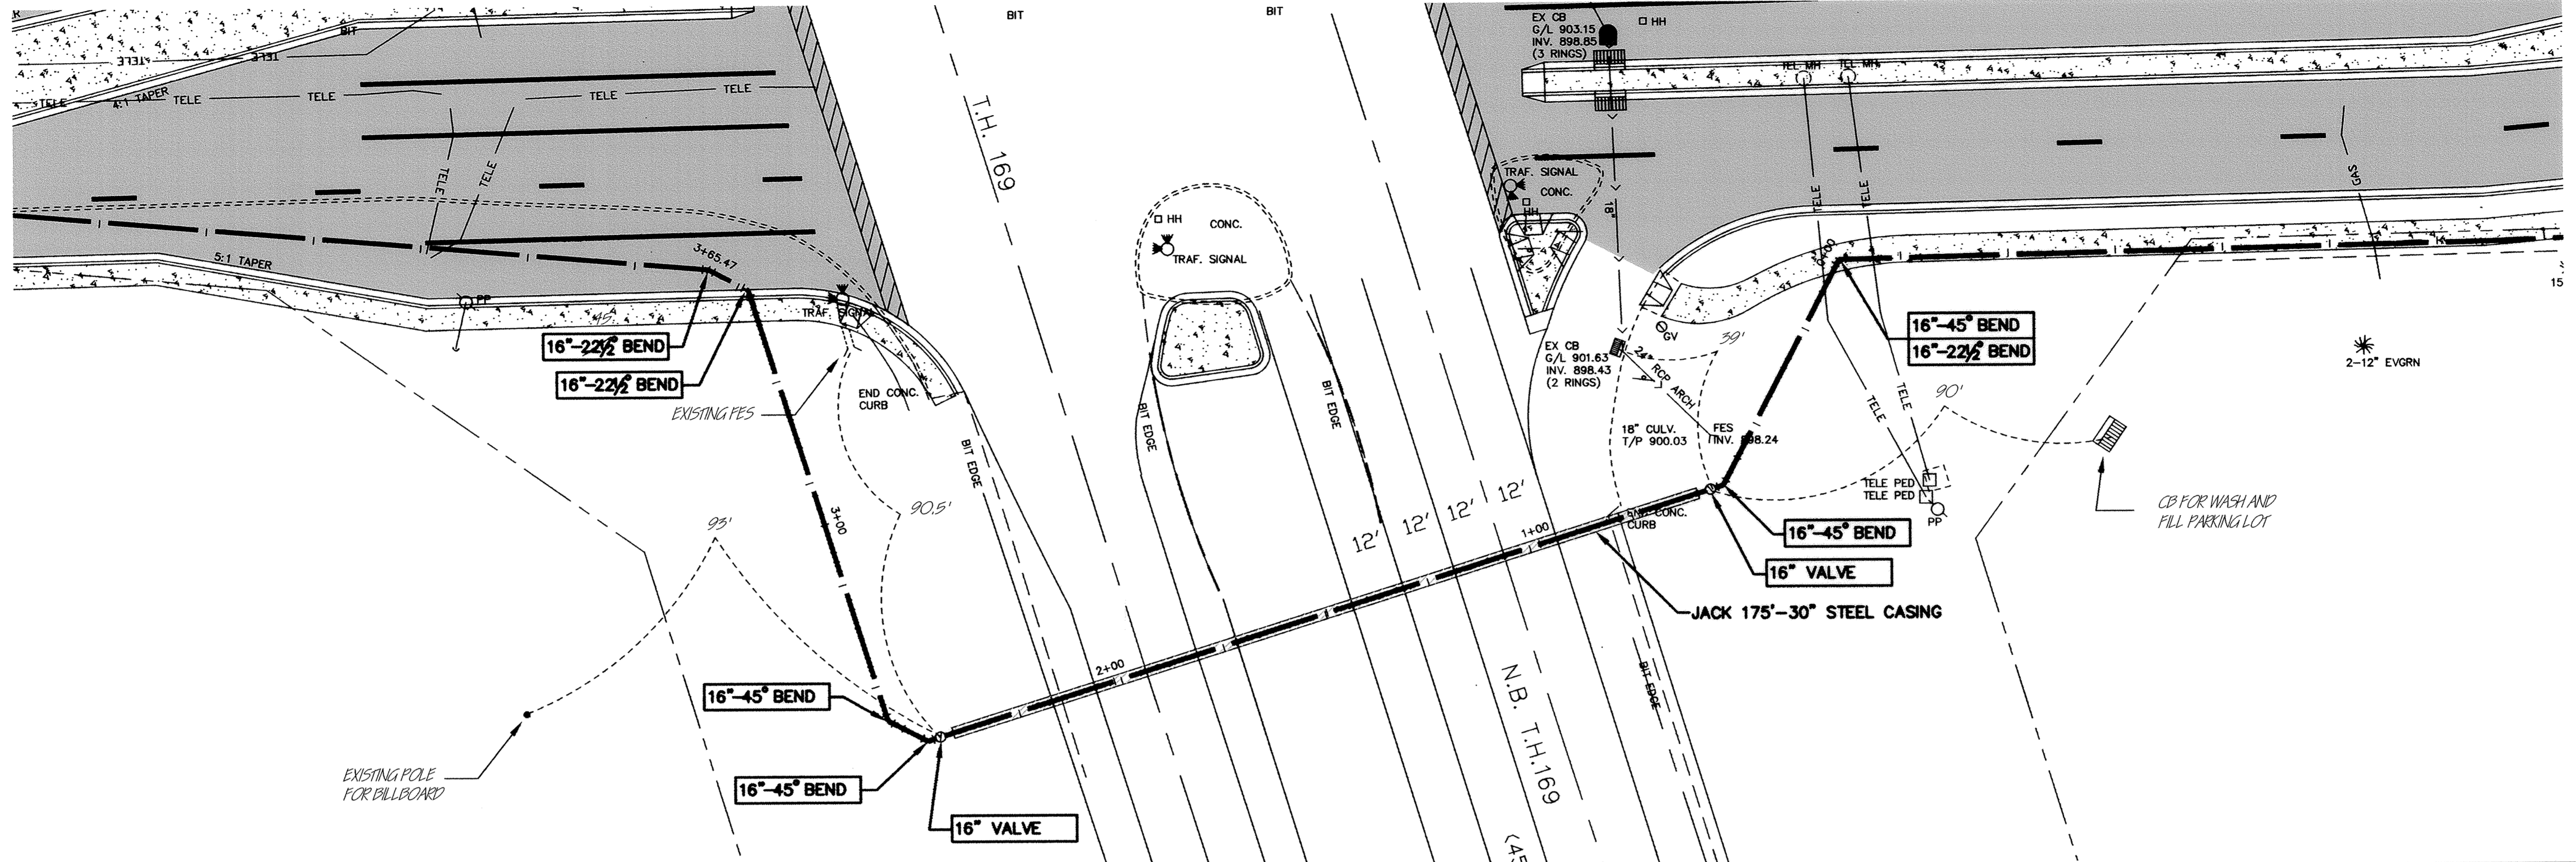

DESIGNED BY: DESIGNED\_BY DRAWN BY: EY  
 APPROVED BY: APPROVED\_BY JOB NUMBER 808200  
 CAD DATE: June 23, 2000 11:34:22 a.m.  
 CAD FILE: 808200\808200P-10.DWG

I HEREBY CERTIFY THAT THIS PLAN, SPECIFICATION,  
 OR REPORT WAS PREPARED BY ME OR UNDER MY DIRECT  
 SUPERVISION AND THAT I AM A DULY REGISTERED  
 PROFESSIONAL ENGINEER UNDER THE LAWS OF THE  
 STATE OF MINNESOTA.  
 DATE \_\_\_\_\_ REG. NO. \_\_\_\_\_

NO.	DATE	BY	REVISION DESCRIPTION

1326 ENERGY PARK DRIVE  
 ST. PAUL, MINNESOTA 55108  
 (651) 644-4389

**Howard R. Green Company**  
 CONSULTING ENGINEERS

**CITY OF ELK RIVER**  
**EASTERN AREA PHASE III**  
**STREET AND UTILITY IMPROVEMENTS**

**PLAN AND PROFILE**  
**WATERMAIN JACKING • MAIN ST./ TH 169**  
 S.A.P. 204-113-09 0+00 TO 3+65

SHEET NO.  
**18**  
 OF  
**46**

DRAWING NUMBER  
 MAINS.00  
 7