




**LIFT STATION NO. 1
ELECTRIC PLAN**


SCALE: 1/2"=1'

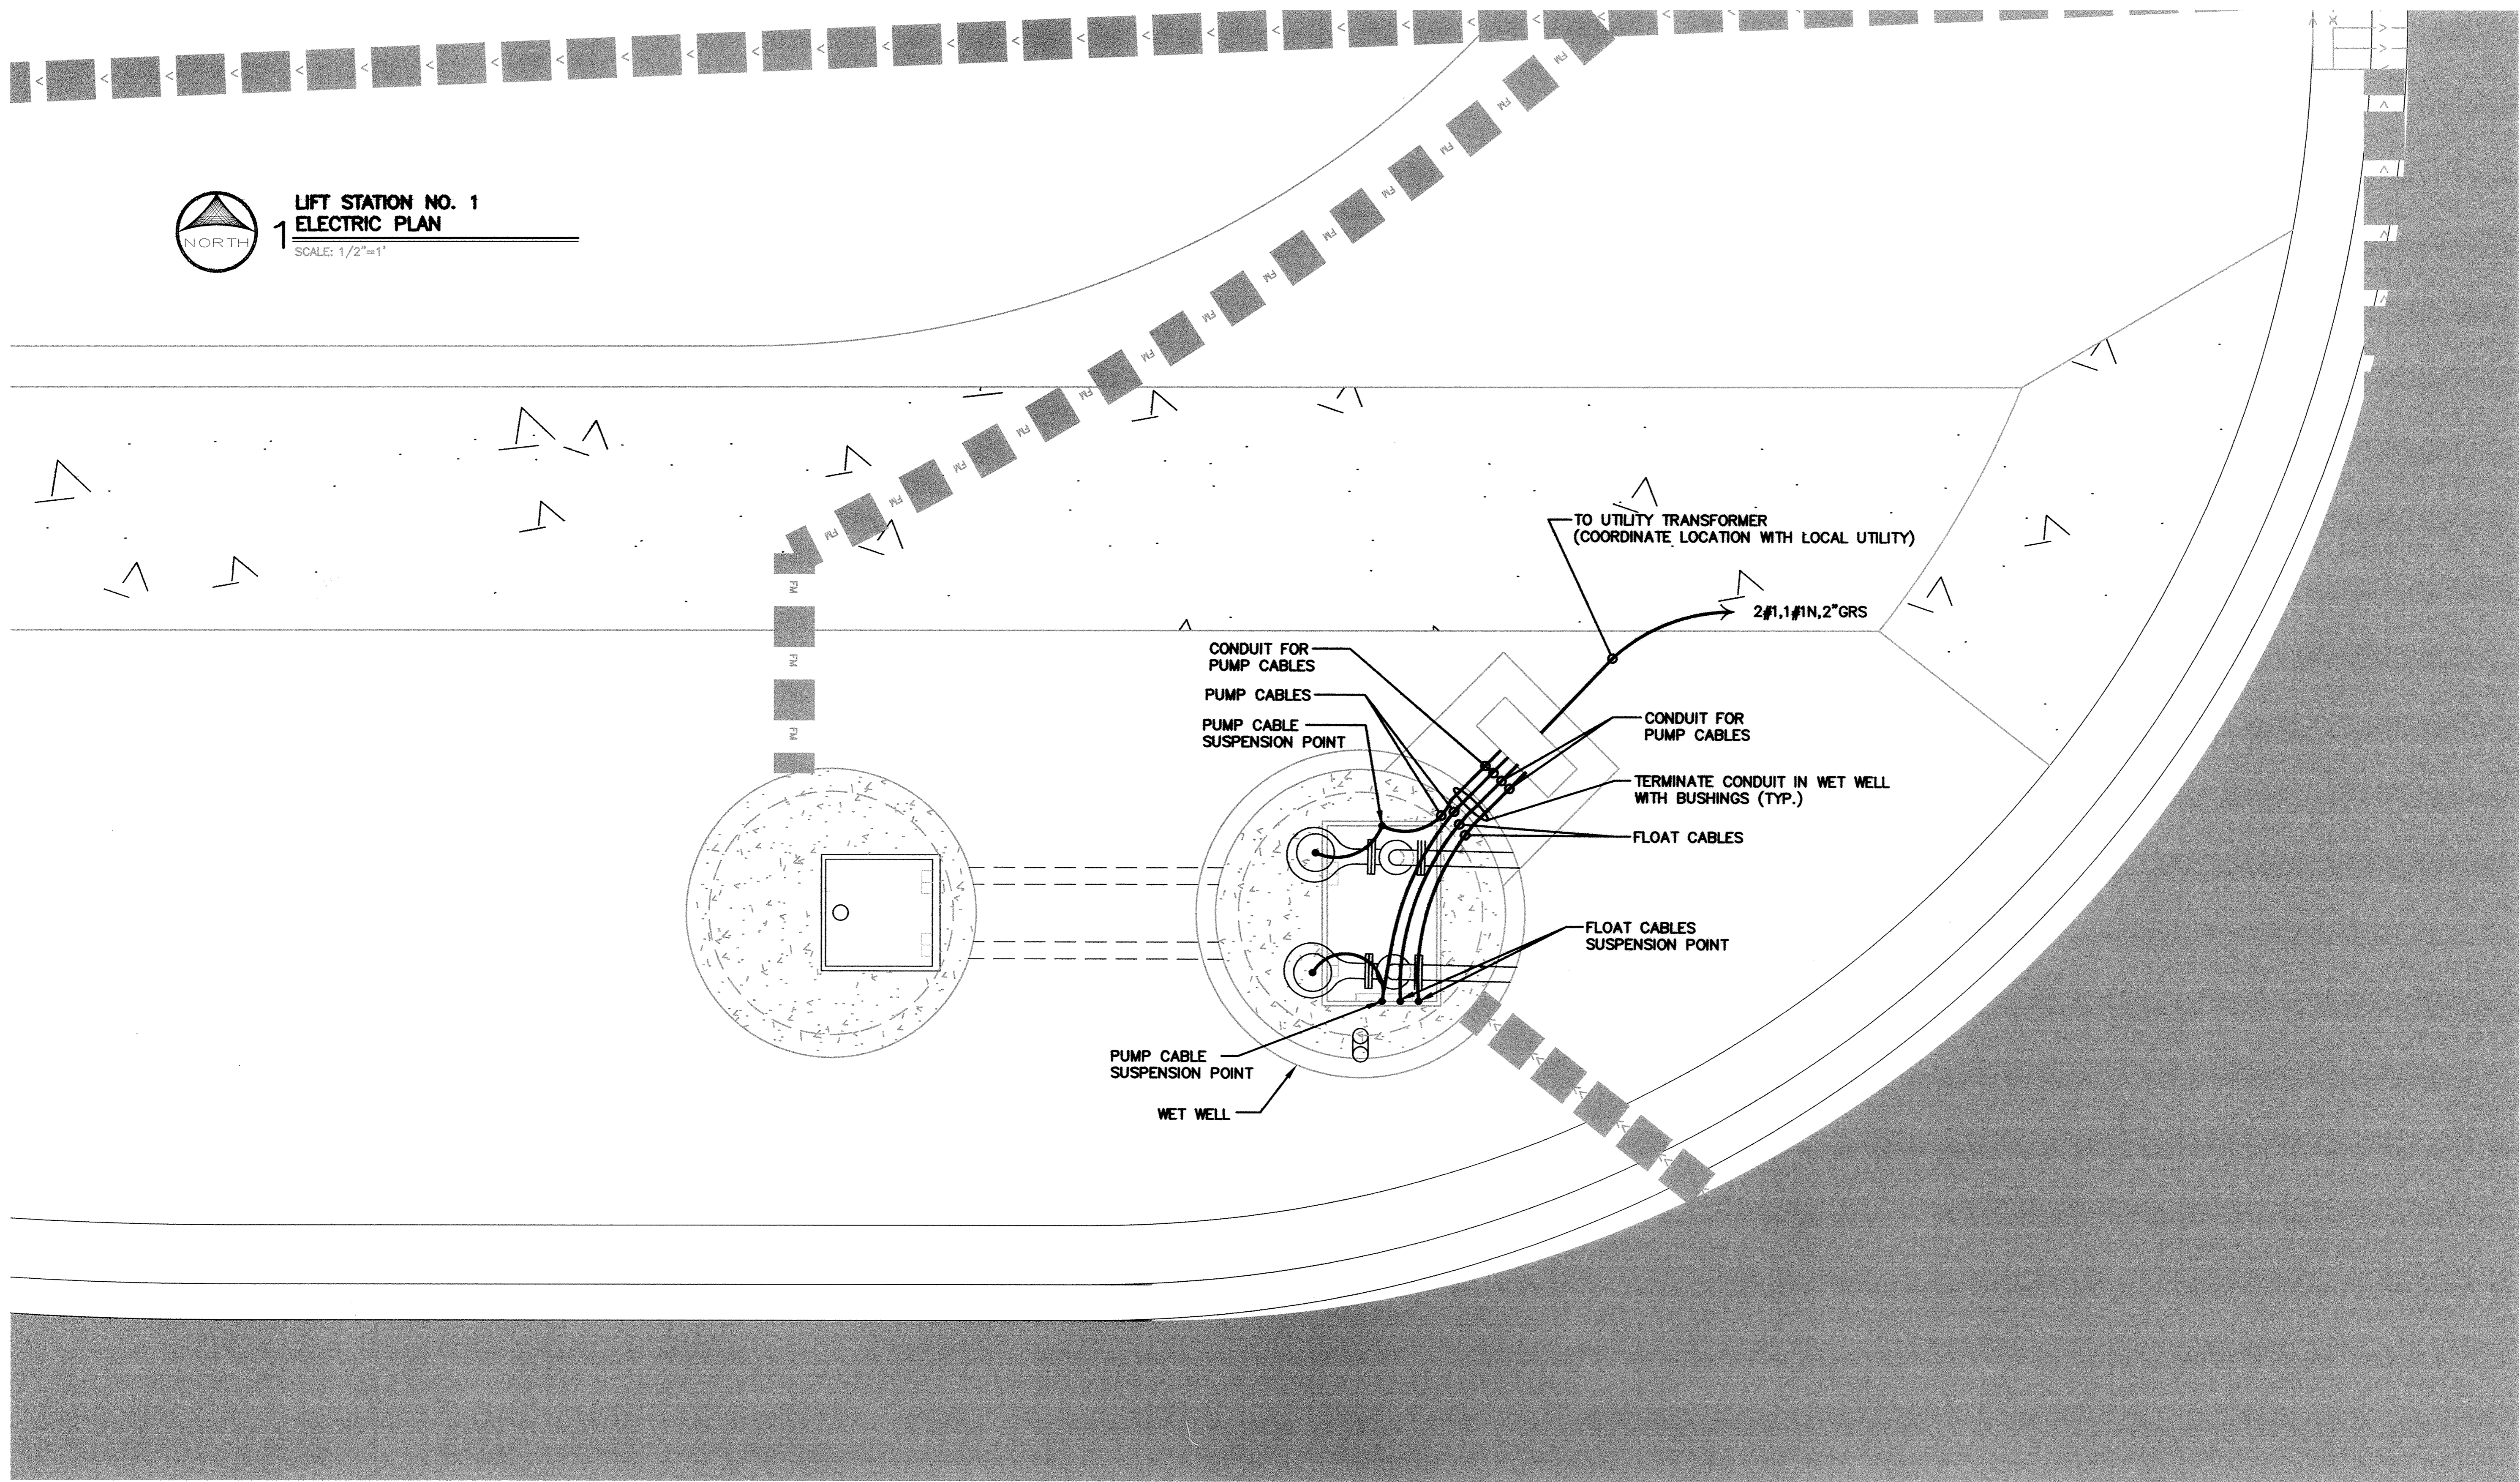

DESIGNED BY: **BJM/EY** DRAWN BY: **EY/TE**
APPROVED BY: **BJM** JOB NUMBER **815361J**
CAD DATE: **May 22, 2002 4:26:06 p.m.**
CAD FILE: **815361J.dwg\LIFT\815361J-E1.DWG (RMONJEA)**

I HEREBY CERTIFY THAT THIS PLAN, SPECIFICATION, OR REPORT WAS PREPARED BY ME OR UNDER MY DIRECT SUPERVISION AND THAT I AM A DULY LICENSED PROFESSIONAL ENGINEER UNDER THE LAWS OF THE STATE OF MINNESOTA.
SIGNATURE _____ DATE _____
PRINTED NAME **ROBERT J. MARVIN** LIC. NO. **26180**

NO.	DATE	BY	REVISION DESCRIPTION

 **Howard R. Green Company**
CONSULTING ENGINEERS
1326 ENERGY PARK DRIVE
ST. PAUL, MINNESOTA 55108
(651) 644-4389

PARK POINTE
CITY OF ELK RIVER

SANITARY LIFT STATION
ELECTRICAL PLAN

SHEET NO.
E1

DRAWING NUMBER

DRAWING NUMBER

DRAWING NUMBER

DRAWING NUMBER
PARKP.02
33

SAICO PRODUCTS • NEW HOPE, MINNESOTA
REPORT BY PART NUMBER 815361
SAICO PRODUCTS • NEW HOPE, MINNESOTA
REPORT BY PART NUMBER 815361
SAICO PRODUCTS • NEW HOPE, MINNESOTA
REPORT BY PART NUMBER 815361