
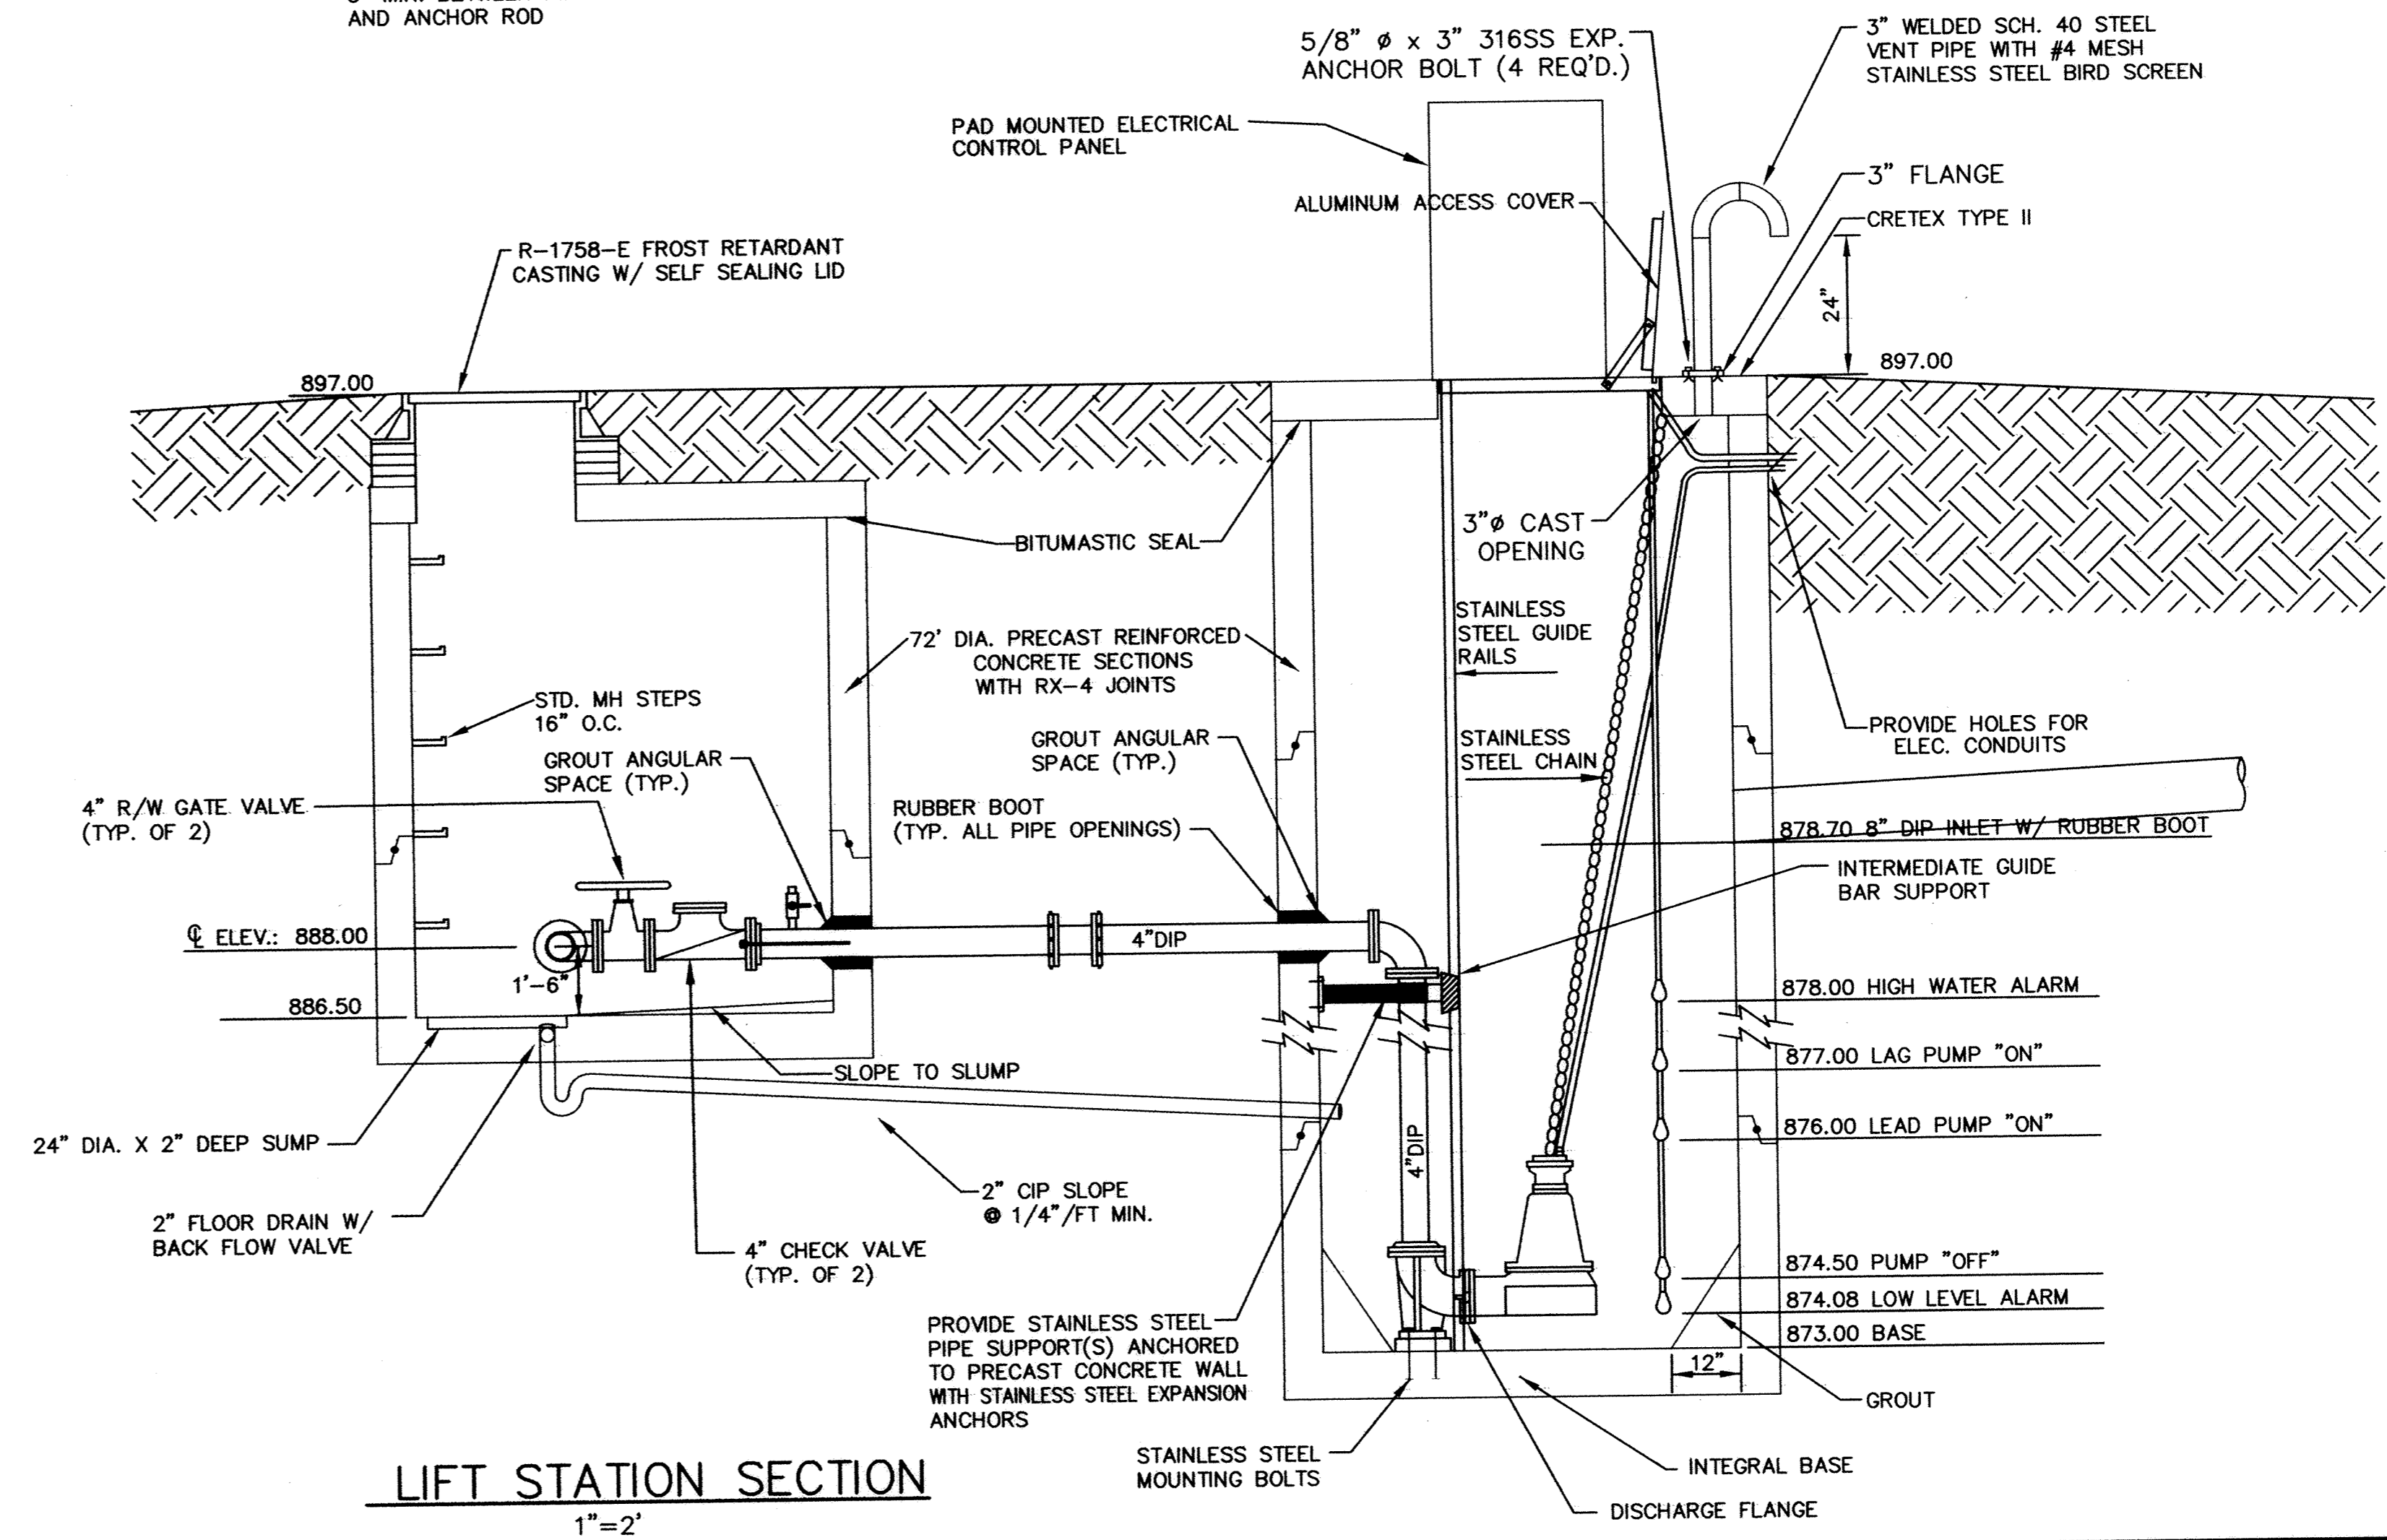
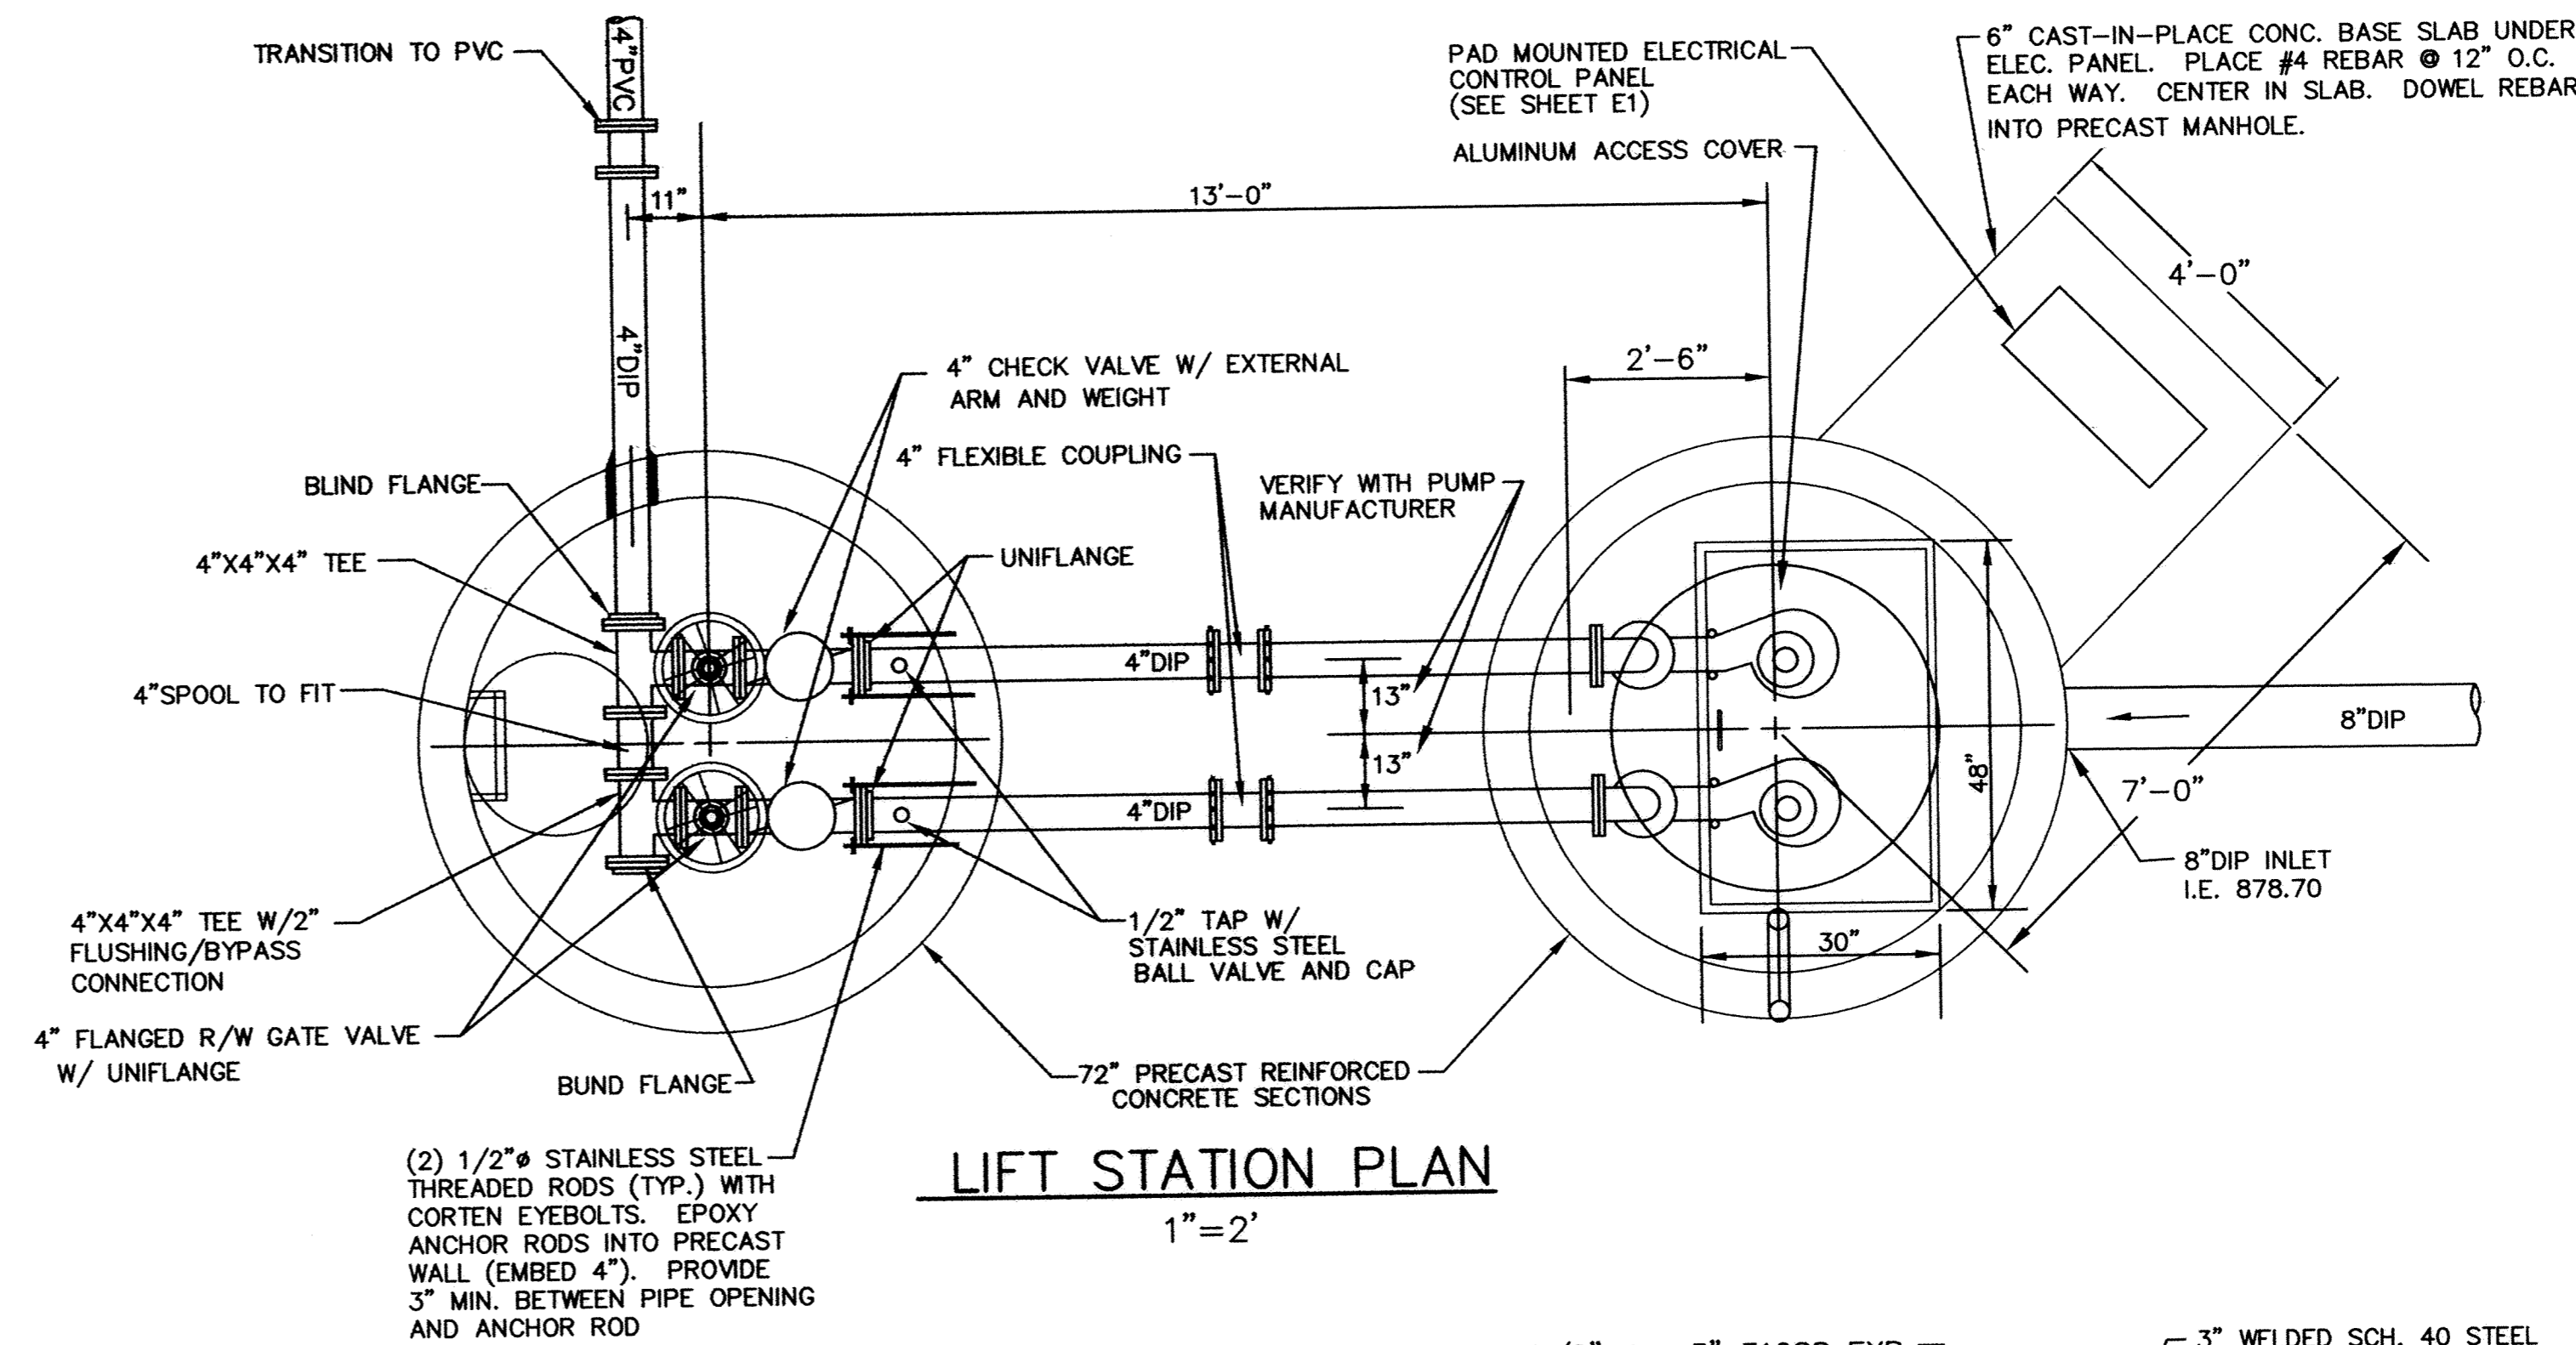


- NOTES:**
1. ALL INTERIOR PIPING SHALL BE FLANGED AND SUPPORTED AS NECESSARY TO HOLD THE PIPE AND APPURTENANCES IN A FIRM SUBSTANTIAL MANNER AT THE LINES AND GRADE SHOWN AND WITHOUT STRAIN UPON THE PIPING AND CONNECTED EQUIPMENT.
 2. ONE FULL LENGTH OF BURIED FORCEMAIN SHALL HAVE RESTRAINED JOINTS. ALL FORCEMAIN FITTINGS SHALL BE RESTRAINED JOINT DUCTILE IRON FITTINGS.

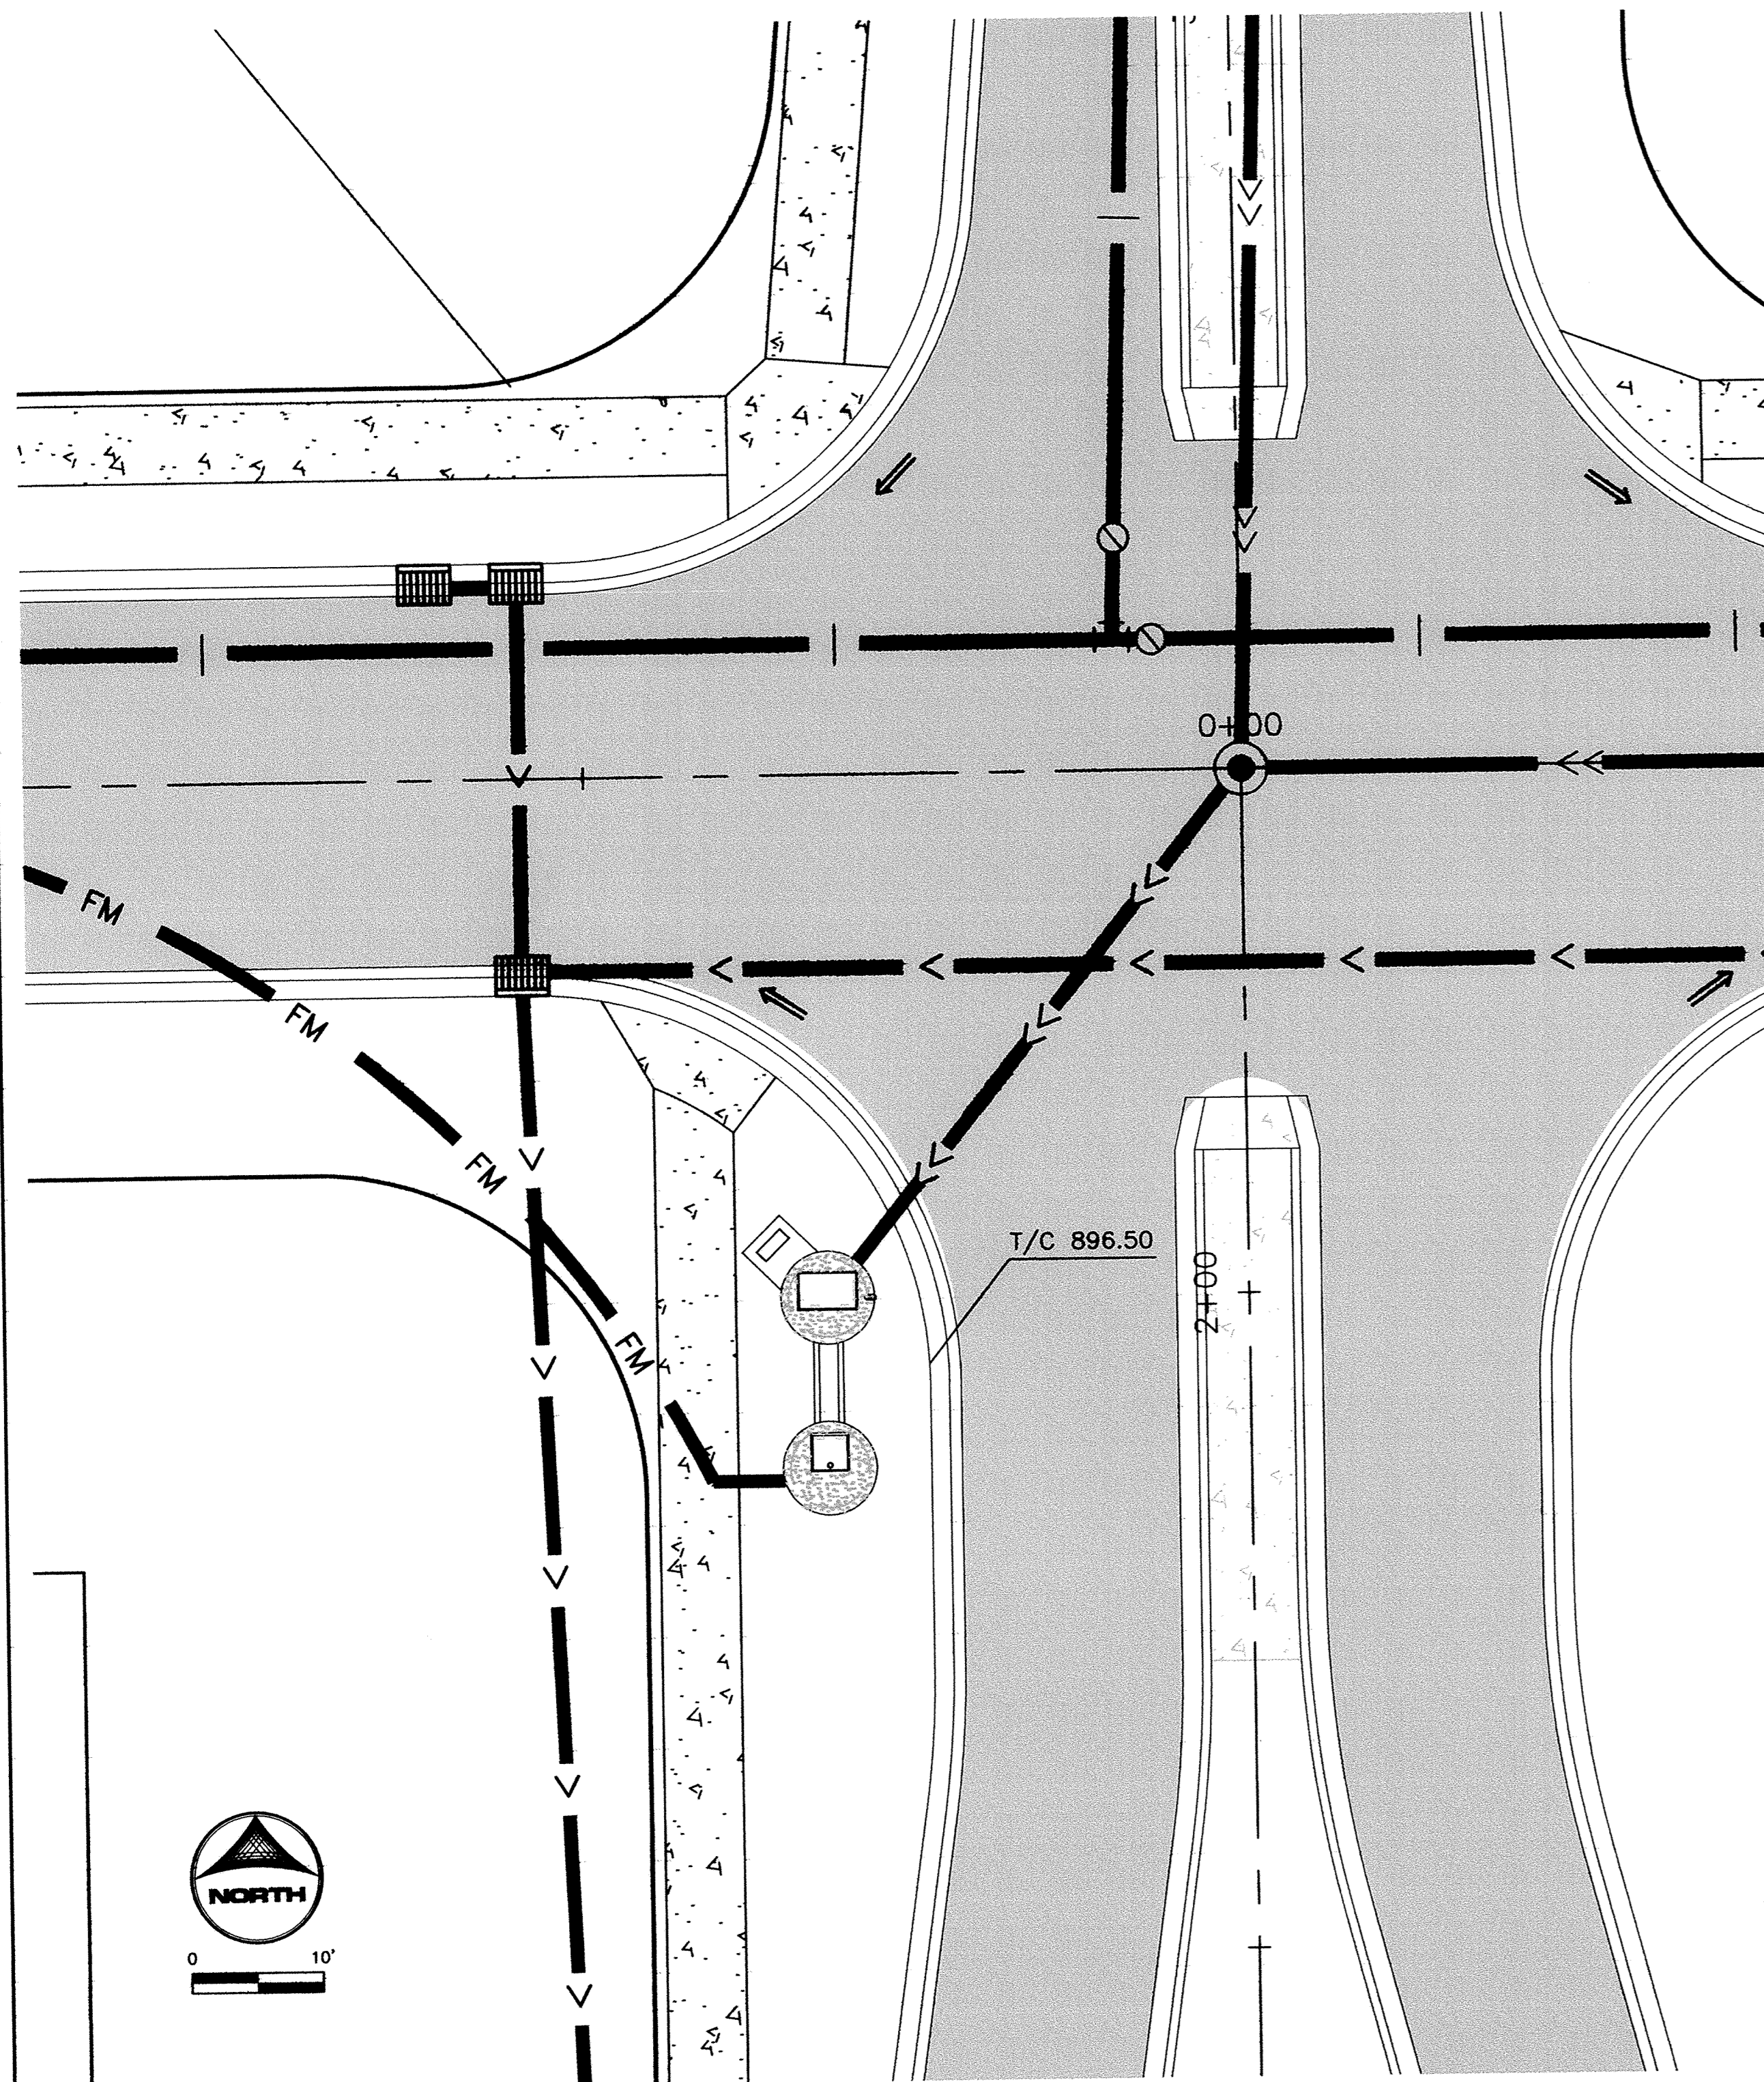

DESIGNED BY: KFN/EY DRAWN BY: TE
 APPROVED BY: KFN JOB NUMBER 8153611J
 CAD DATE: May 10, 2002 3:04:06 p.m.
 CAD FILE: 8153611J.dwg\LIFT\815361-LS.DWG (RMONJEA)

I HEREBY CERTIFY THAT THIS PLAN, SPECIFICATION, OR REPORT WAS PREPARED BY ME OR UNDER MY DIRECT SUPERVISION AND THAT I AM A DULY LICENSED PROFESSIONAL ENGINEER UNDER THE LAWS OF THE STATE OF MINNESOTA.

SIGNATURE: KEVIN F. NEWMAN DATE: _____
 PRINTED NAME: KEVIN F. NEWMAN LIC. NO. 25198

NO.	DATE	BY	REVISION DESCRIPTION

1326 ENERGY PARK DRIVE
 ST. PAUL, MINNESOTA 55108
 (612) 644-4389

Howard R Green Company
 CONSULTING ENGINEERS

PARK POINTE
 CITY OF ELK RIVER

LIFT STATION SITE PLAN
PLAN AND SECTION

SHEET NO.
L1

DRAWING NUMBER
 PARKP 02
 SHEET NO.
 L1