
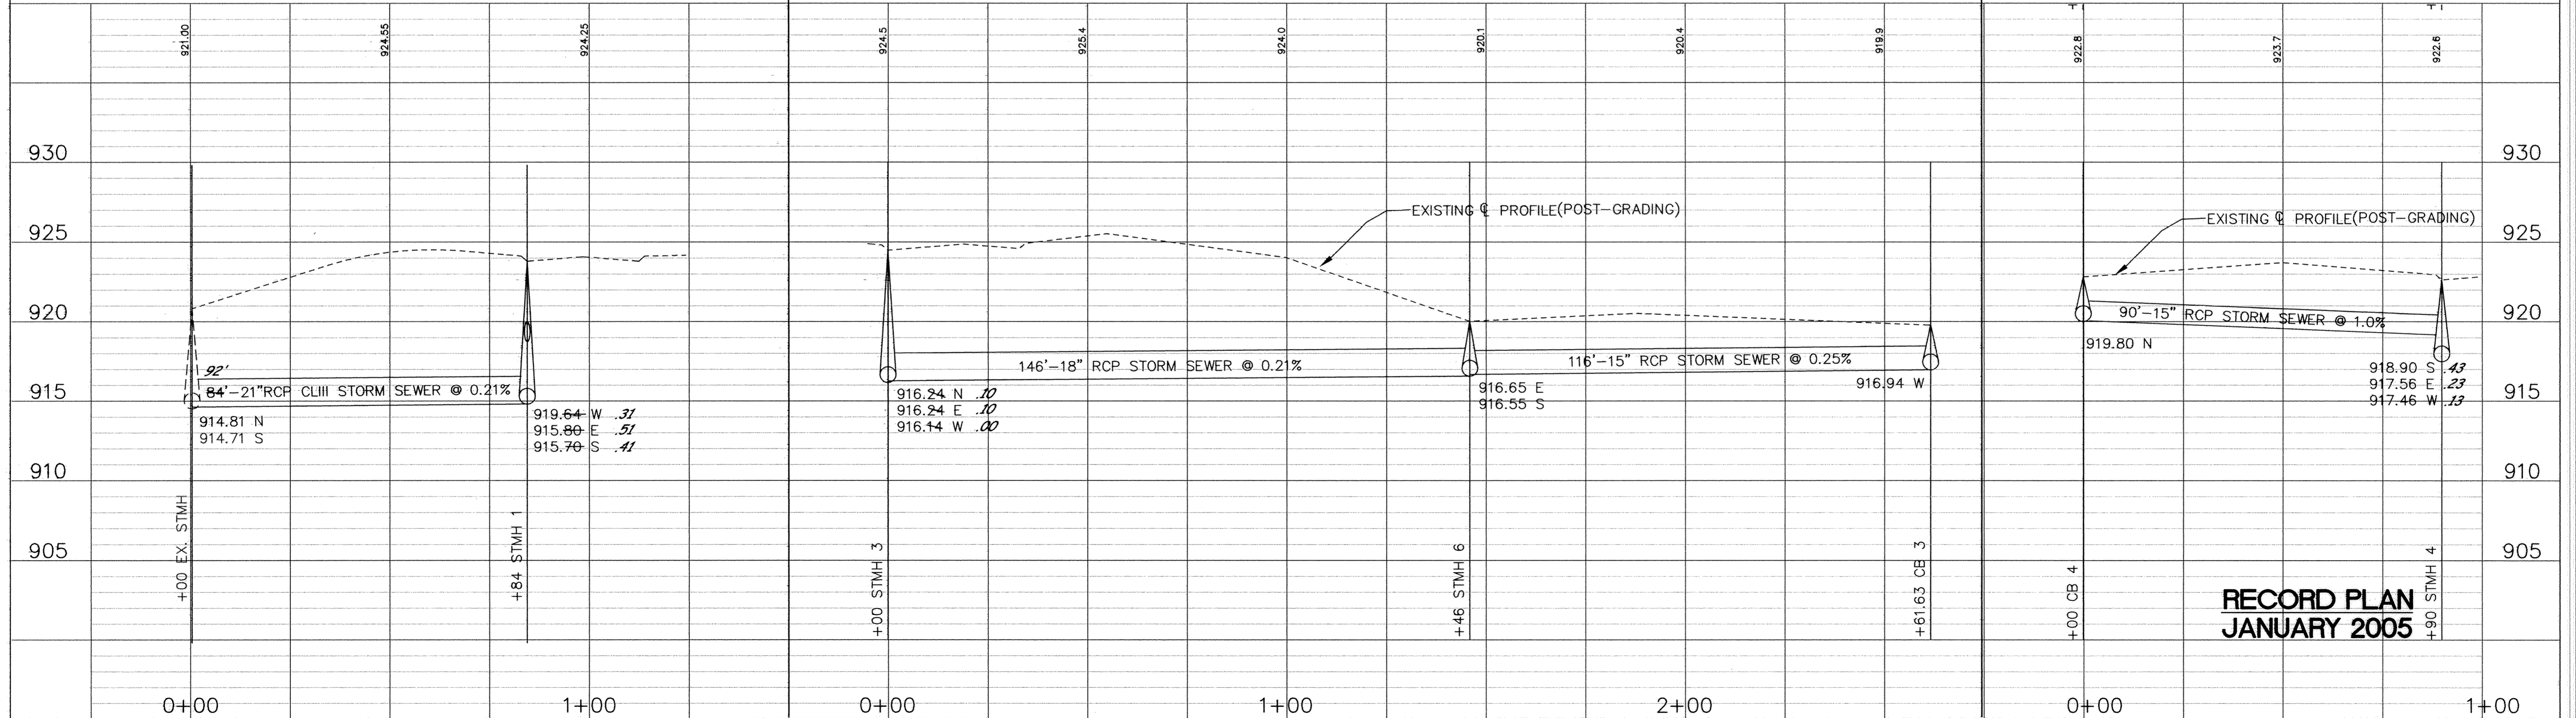
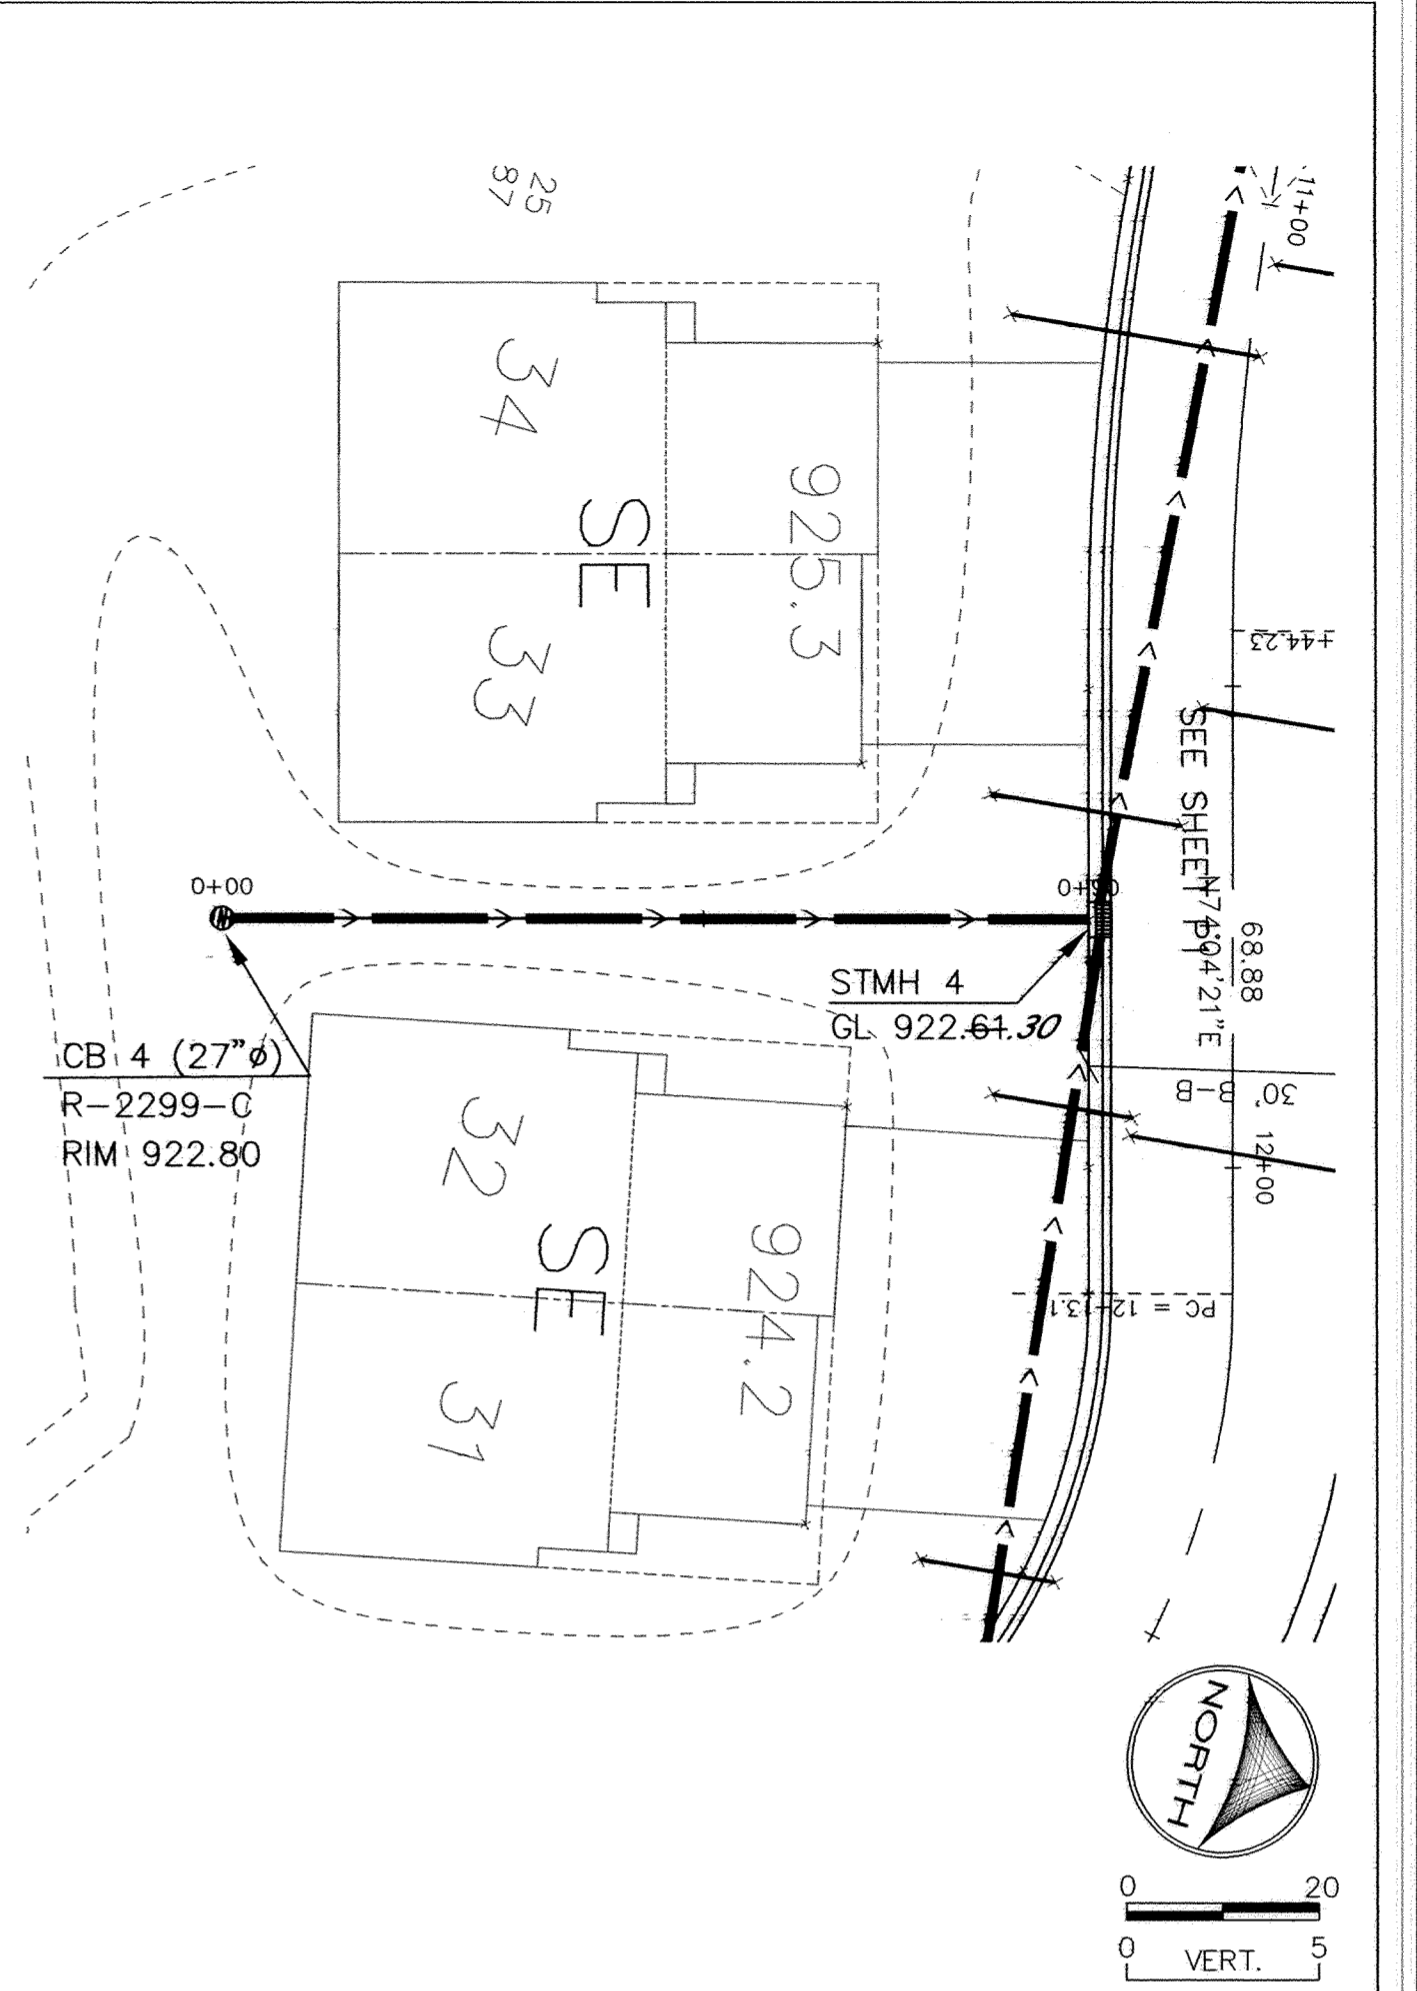
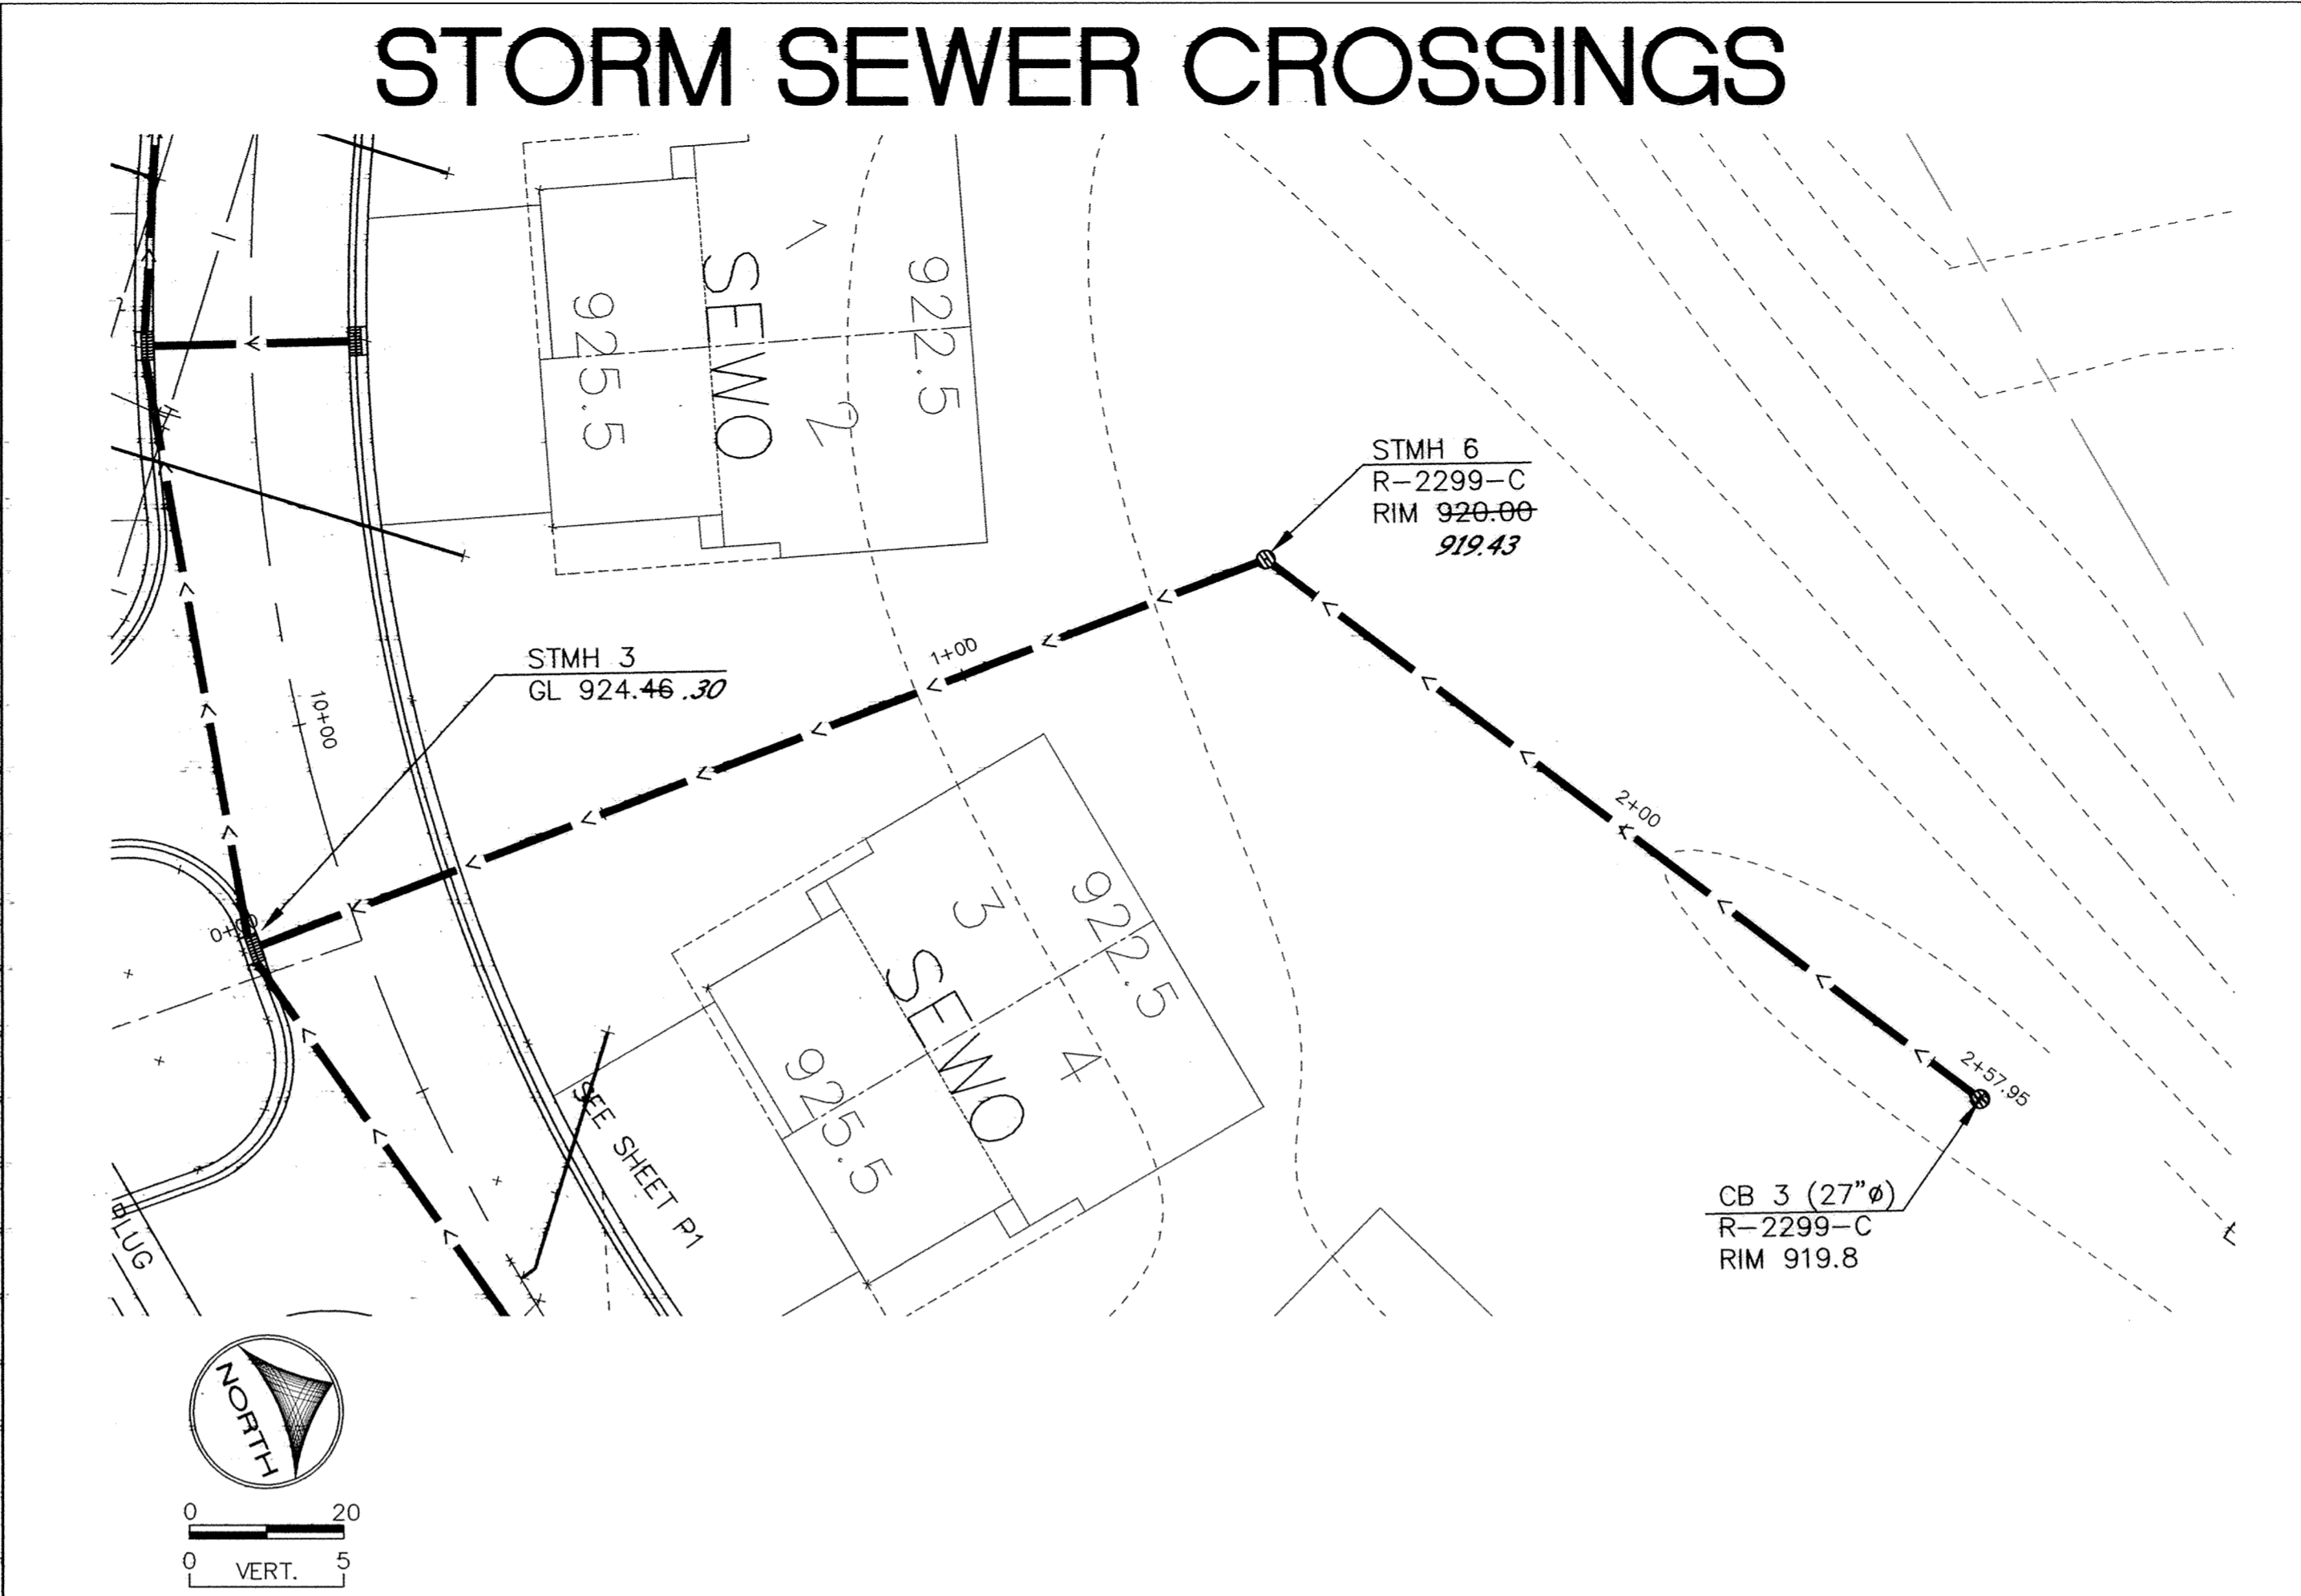


STORM SEWER CROSSINGS

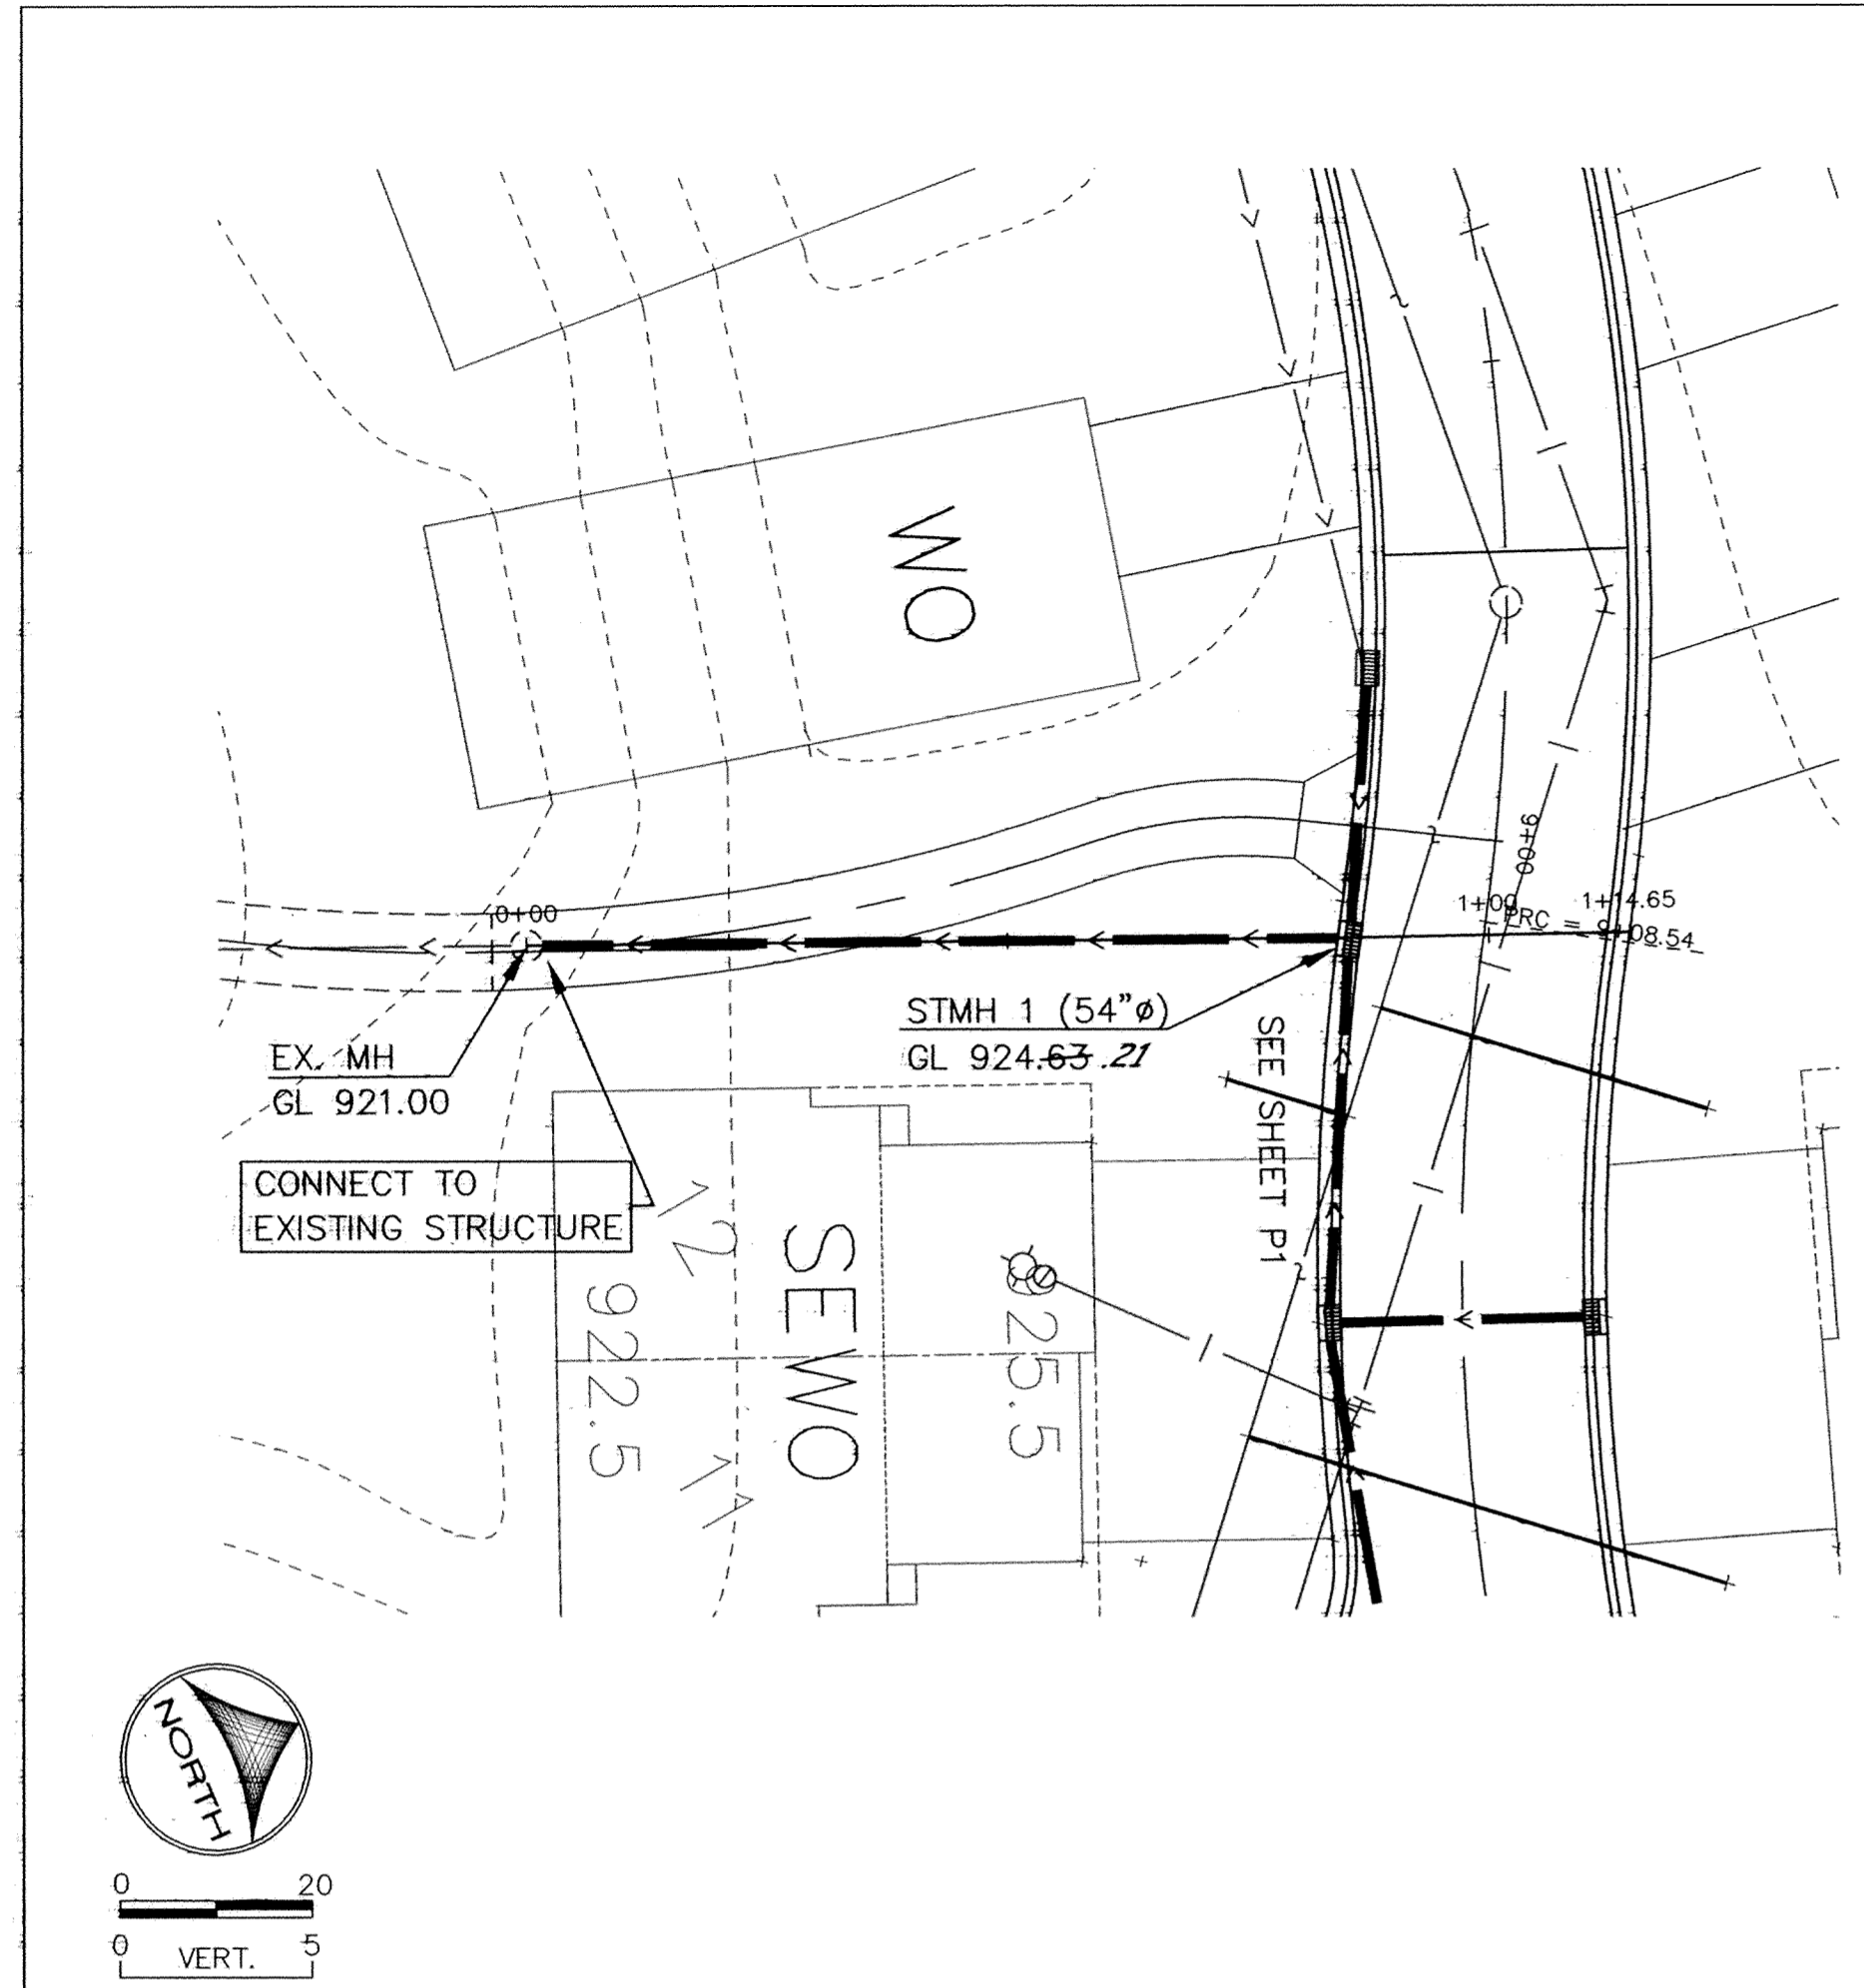

**RECORD PLAN
JANUARY 2005**

DESIGNED BY: DESIGNED_BY DRAWN BY: EY
 APPROVED BY: APPROVED_BY JOB NUMBER 809782J
 CAD DATE: January 20, 2005 11:51:13 a.m.
 CAD FILE: 809782\ASBUILT\Phase2\809782-P3.DWG

I HEREBY CERTIFY THAT THIS PLAN, SPECIFICATION,
 OR REPORT WAS PREPARED BY ME OR UNDER MY DIRECT
 SUPERVISION AND THAT I AM A DULY REGISTERED
 PROFESSIONAL ENGINEER UNDER THE LAWS OF THE
 STATE OF MINNESOTA.
 DATE 2/2/05 REG. NO. 25889

NO.	DATE	BY	REVISION DESCRIPTION

1326 ENERGY PARK DRIVE
 ST. PAUL, MINNESOTA 55108
 (651) 644-4389

Howard R. Green Company
 CONSULTING ENGINEERS

CITY OF ELK RIVER
TWIN LAKES TOWNHOMES 2ND ADDITION
STREET AND UTILITY IMPROVEMENTS

STORM SEWER CROSSING
PLAN AND PROFILE

SHEET NO.
P3