
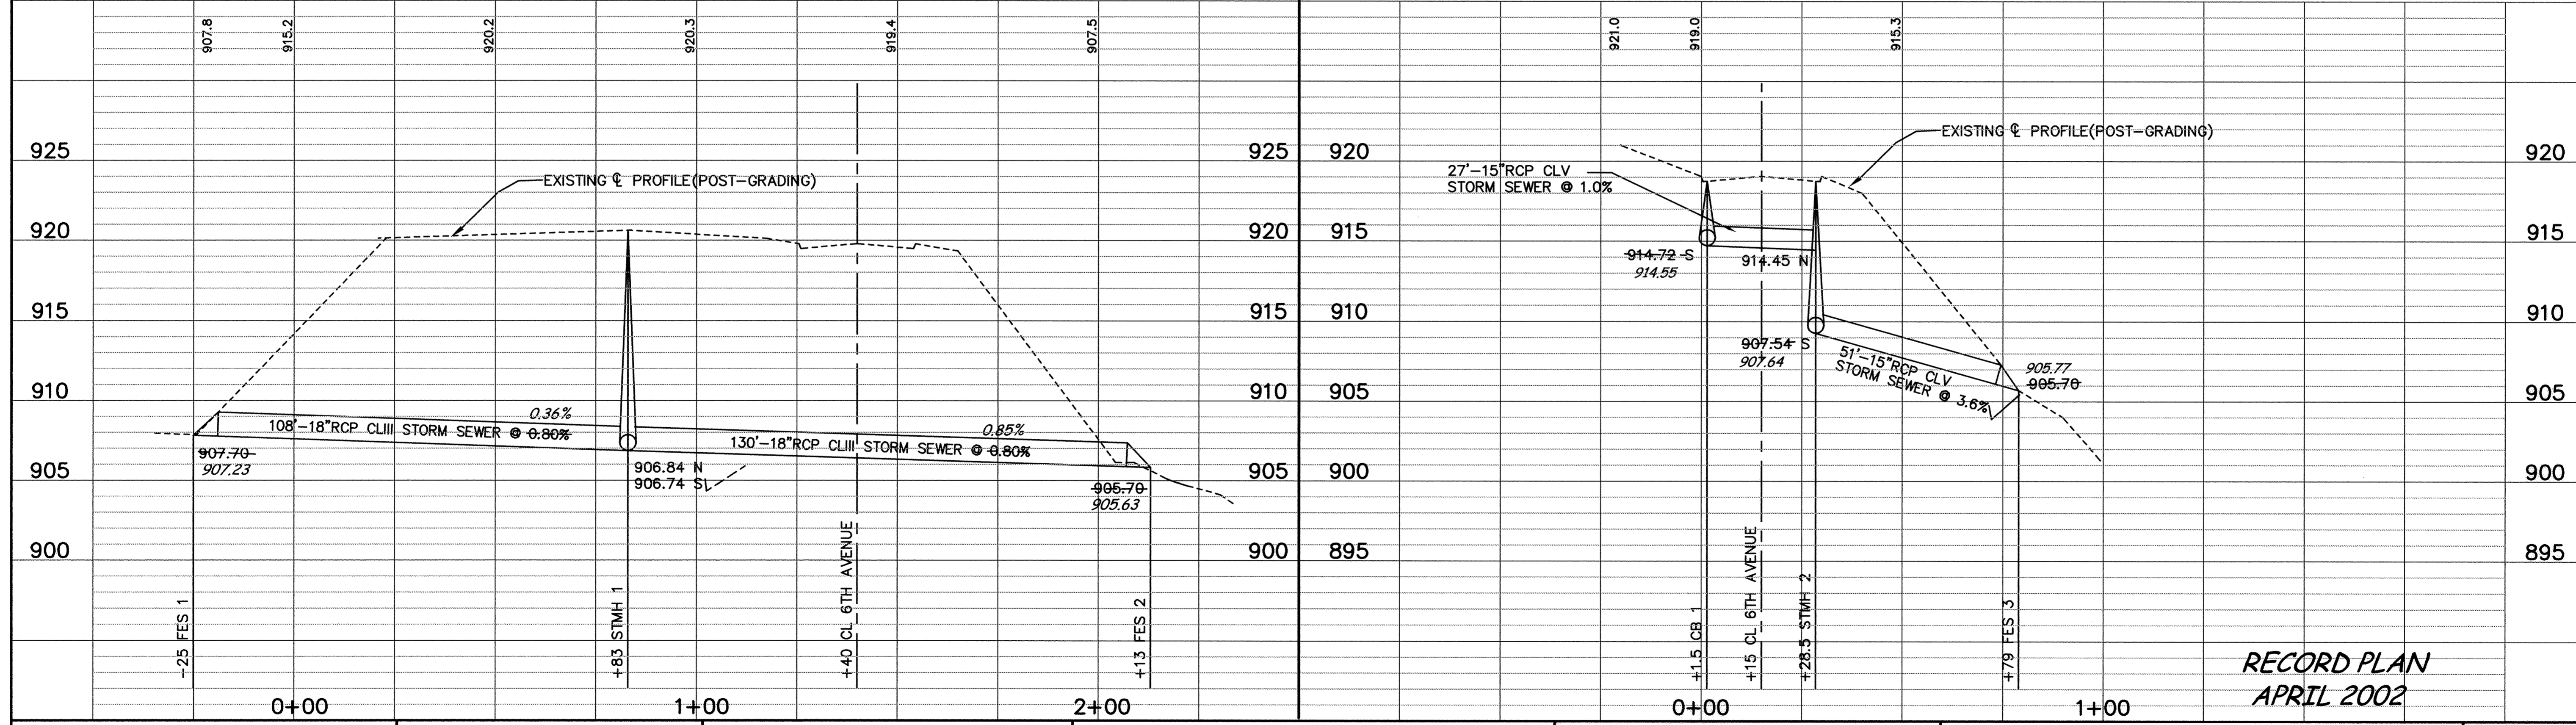
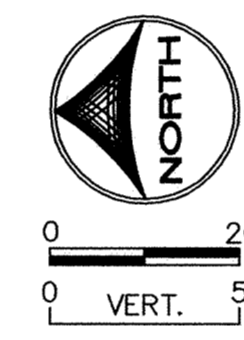
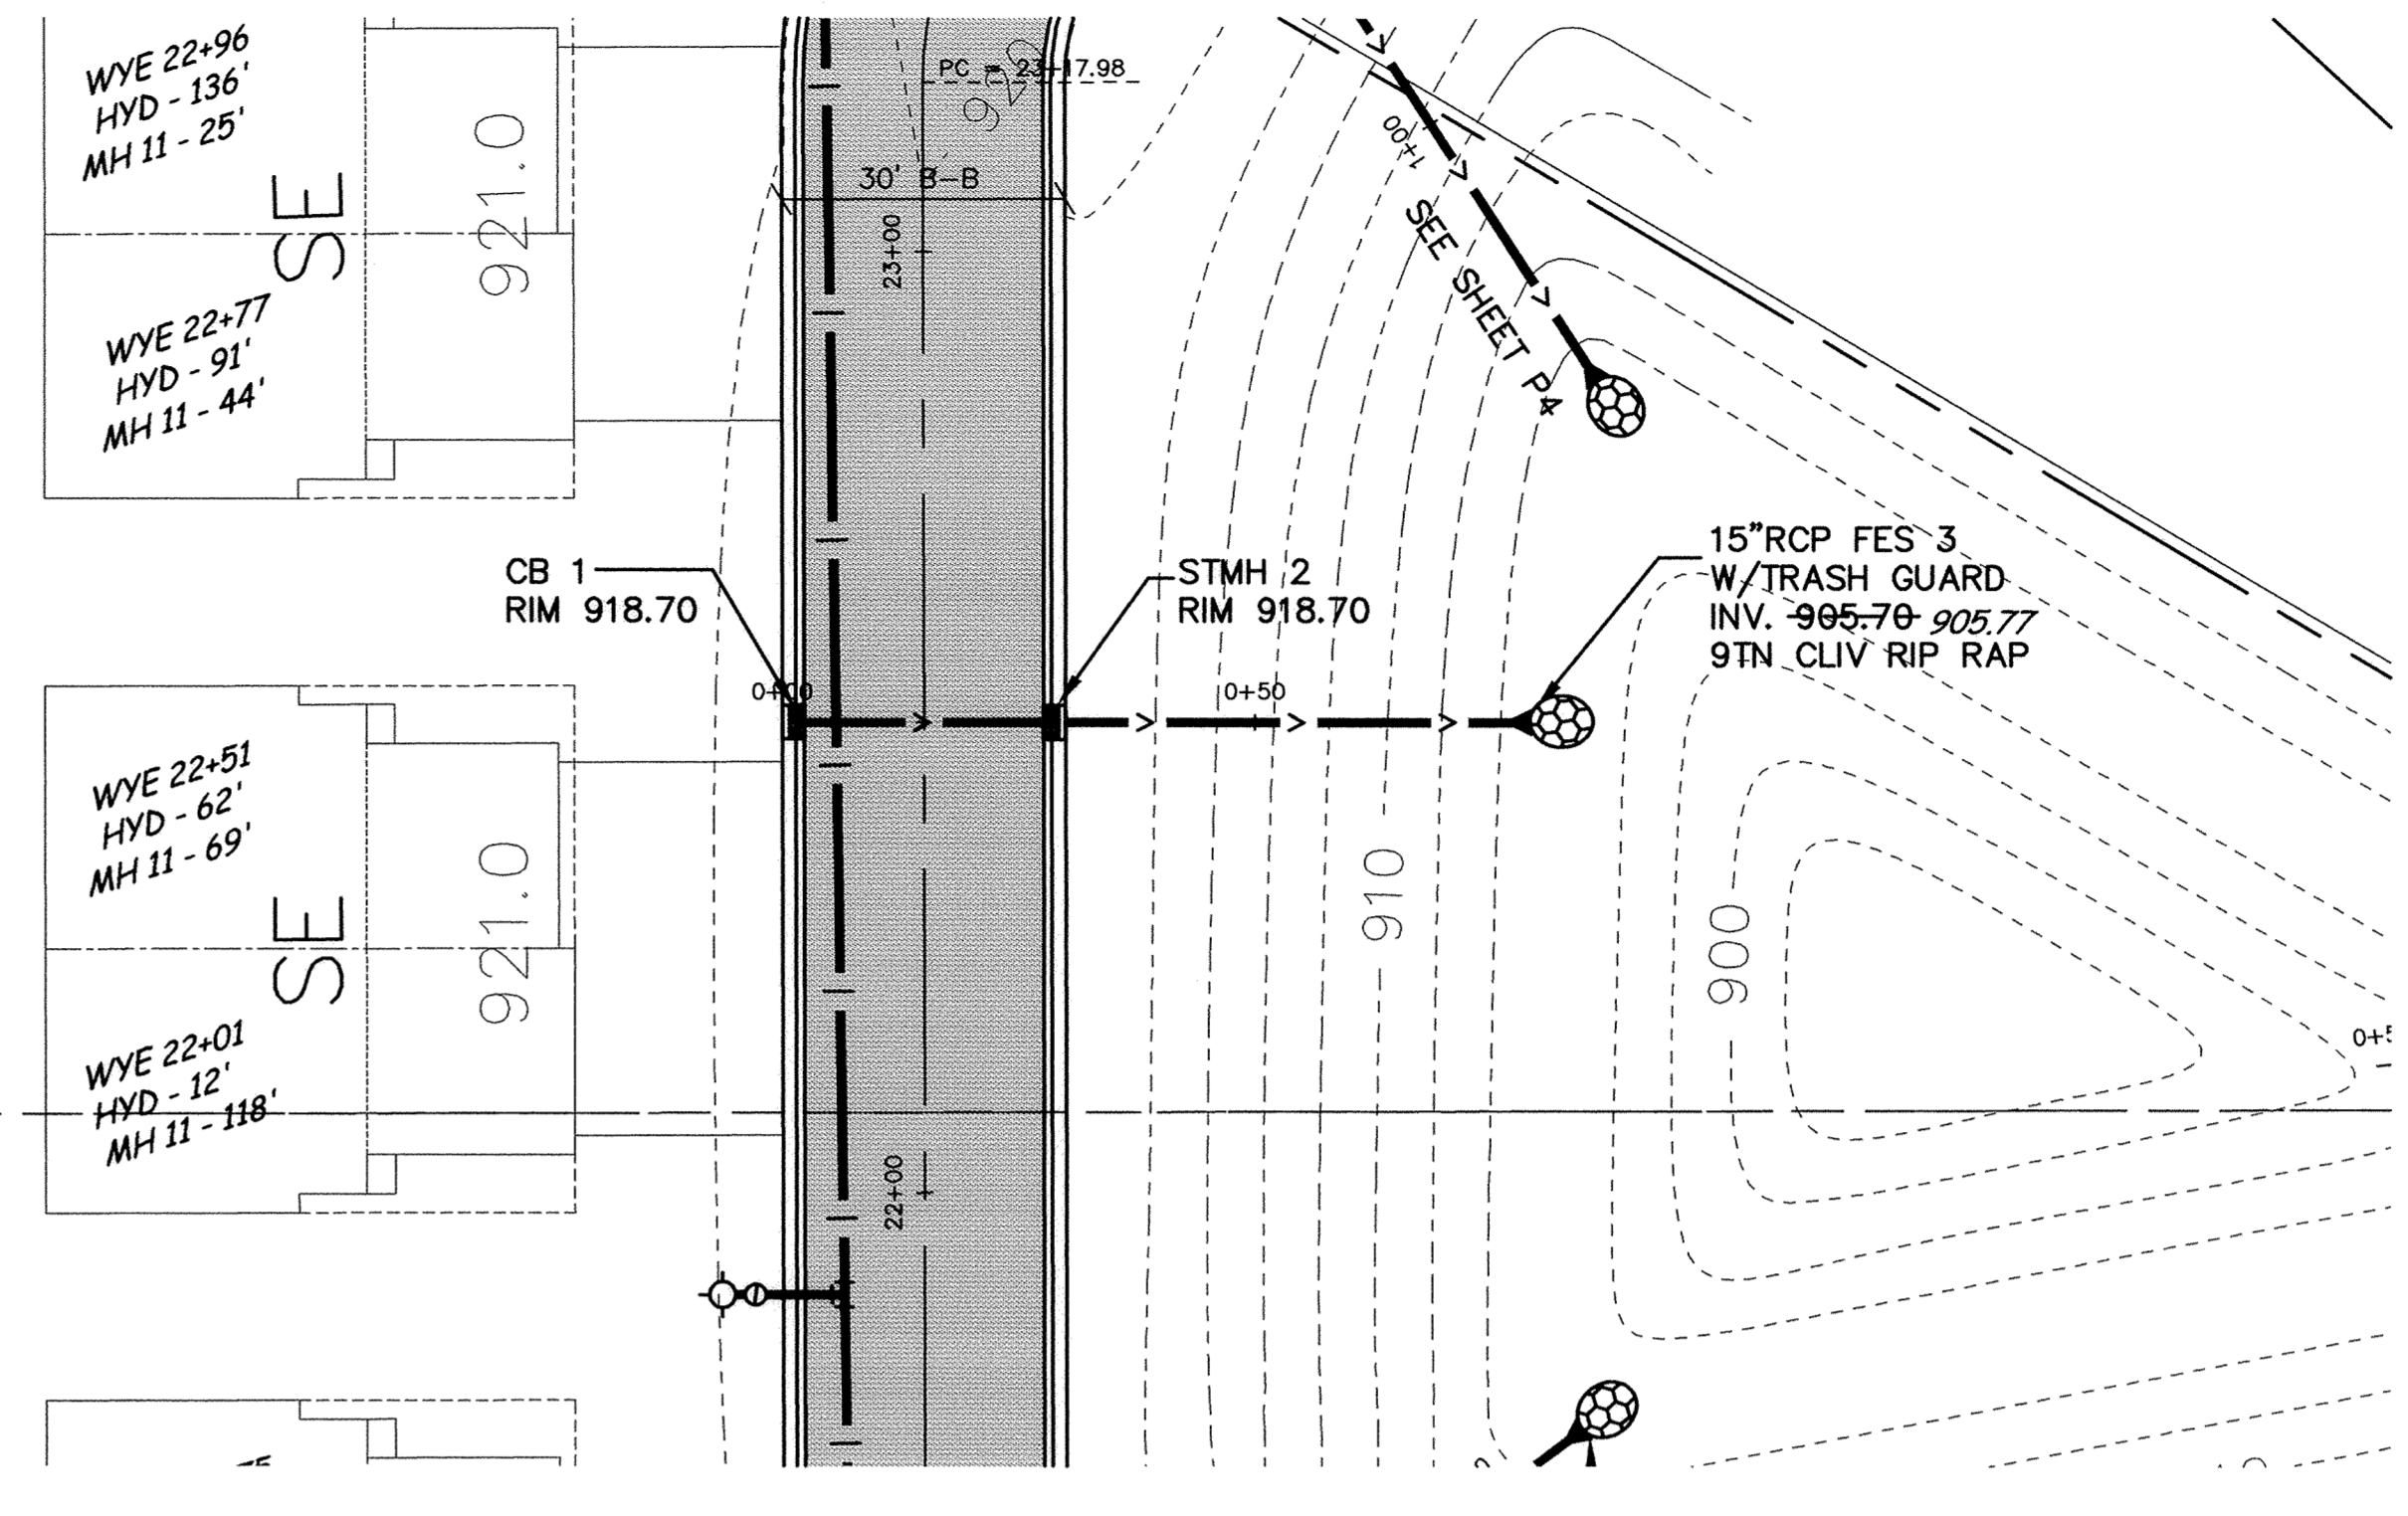
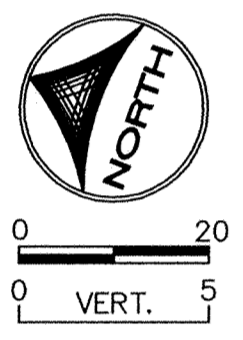


STORM SEWER CROSSINGS

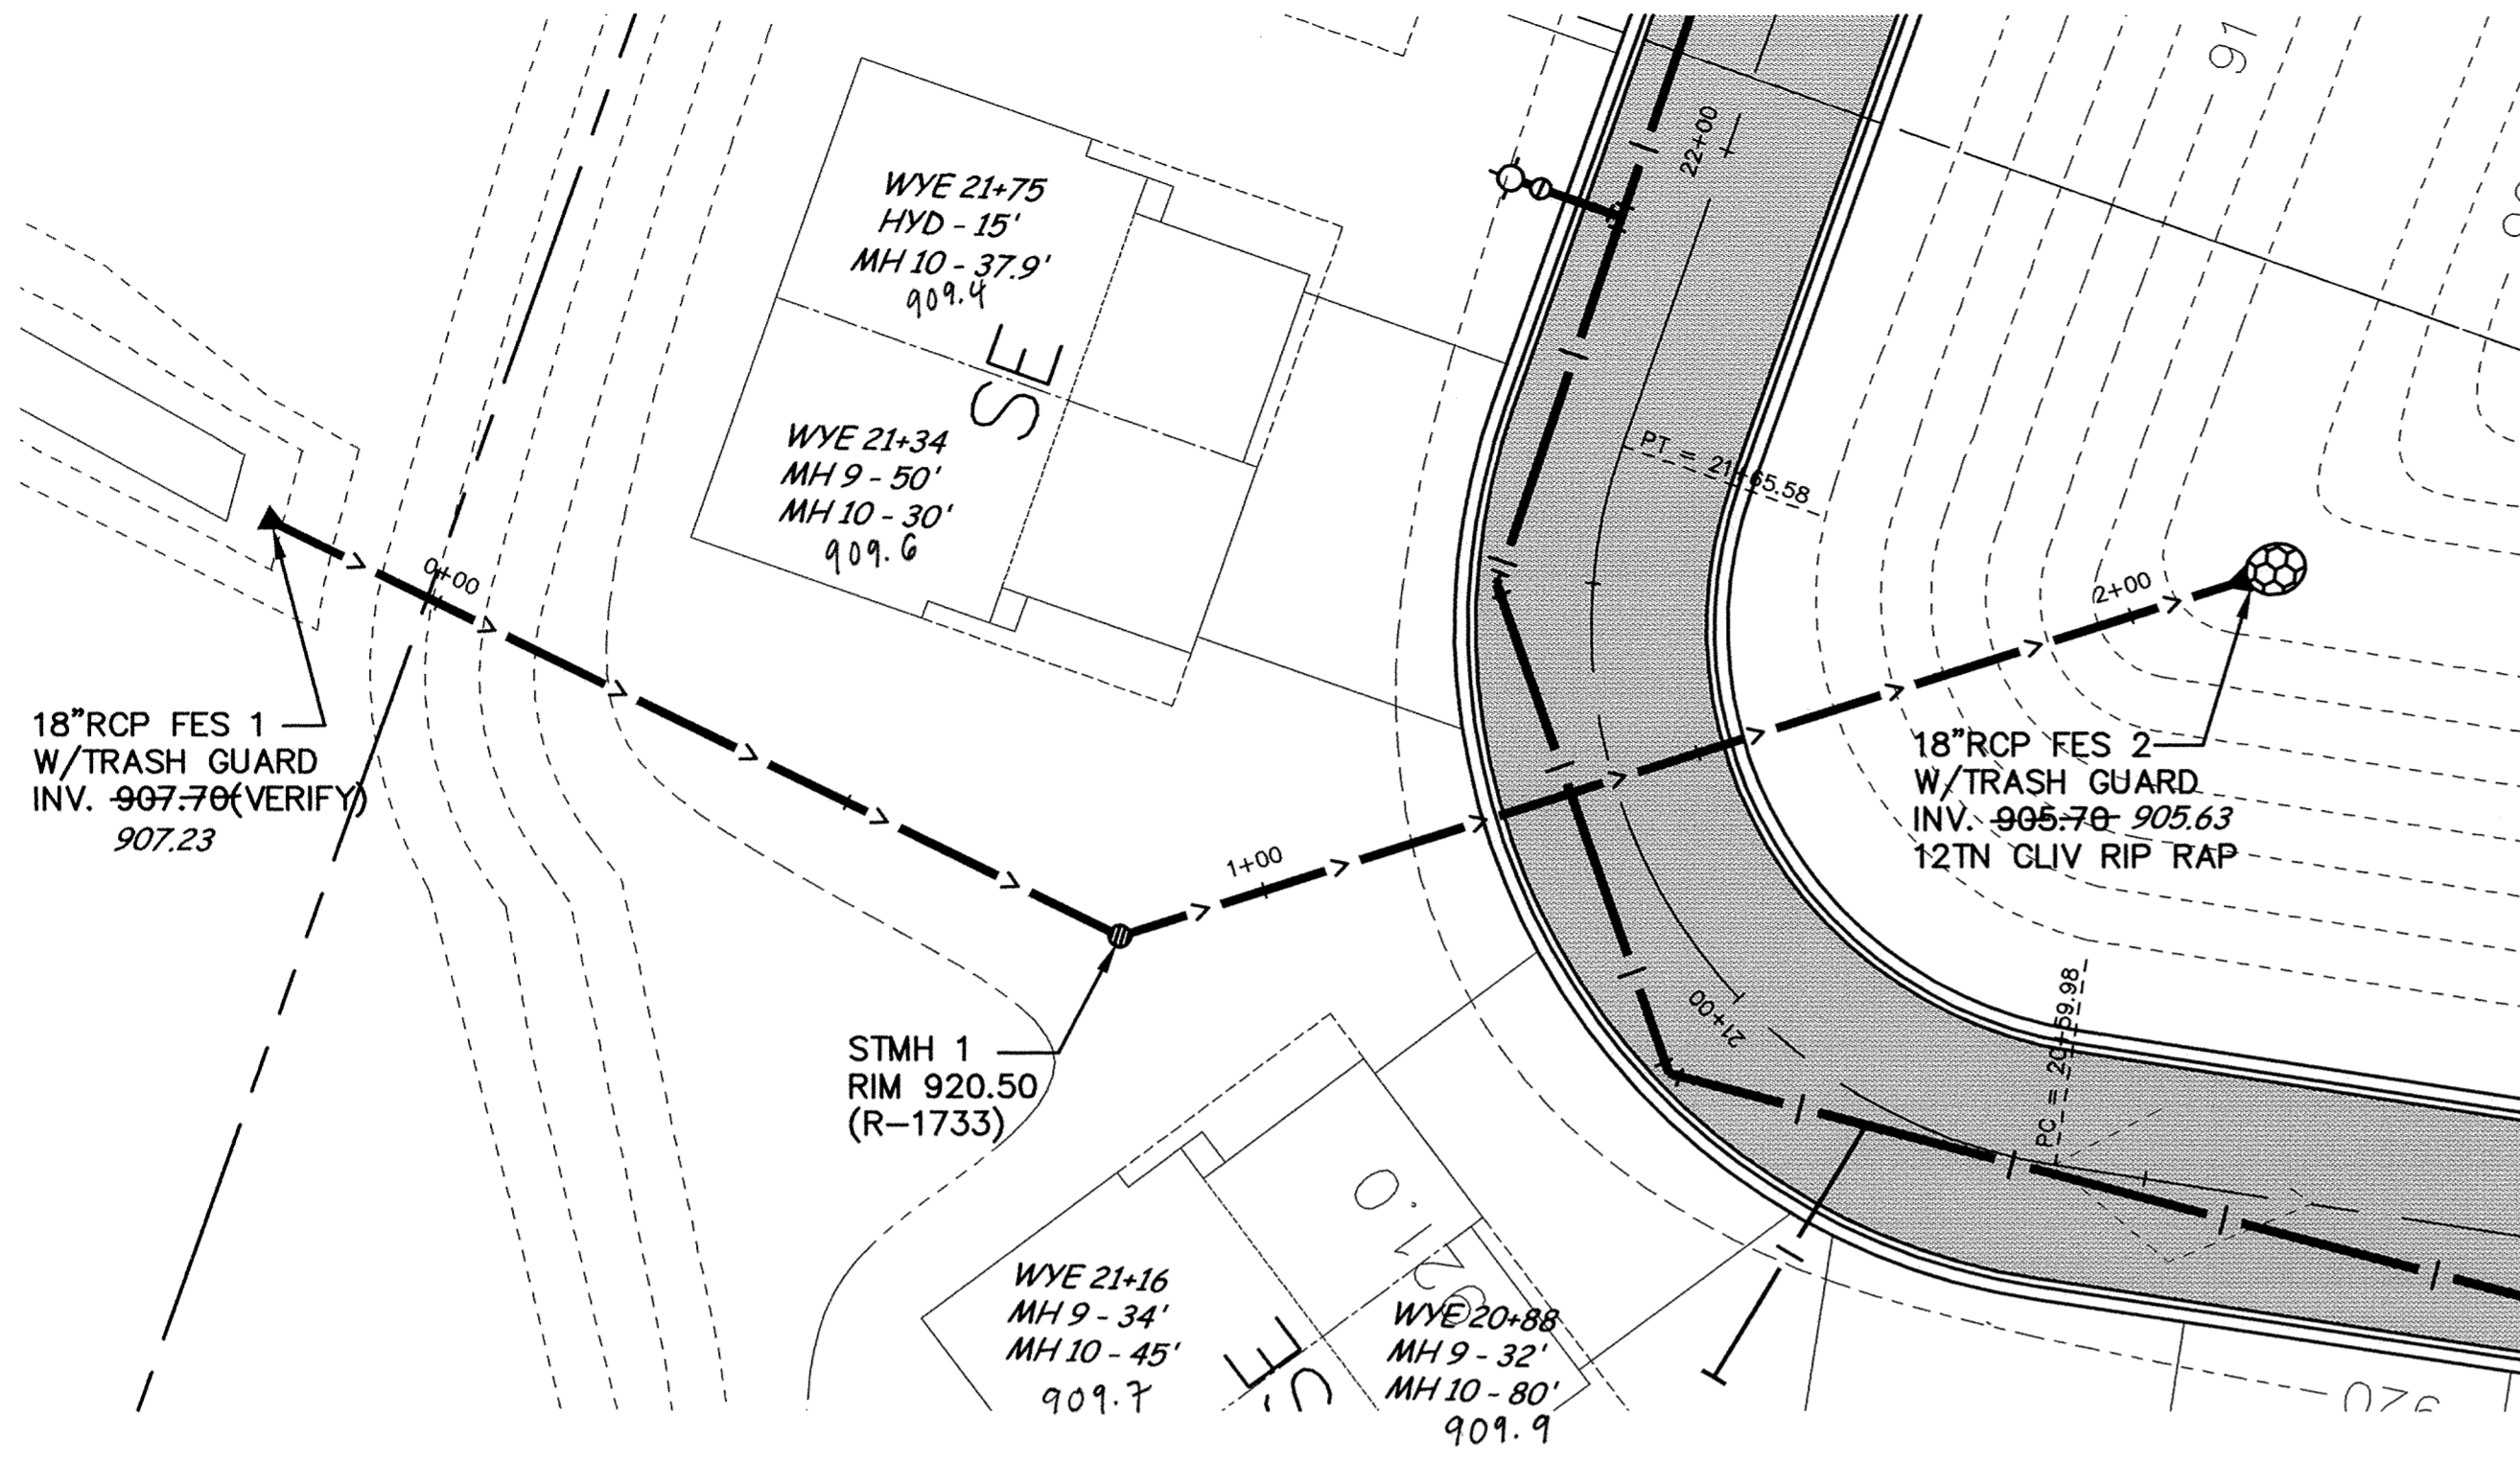

RECORD PLAN
APRIL 2002

DESIGNED BY: TJM DRAWN BY: EY
 APPROVED BY: TJM JOB NUMBER 809782J
 CAD DATE: April 03, 2002 2:22:54 p.m.
 CAD FILE: 809783\Phase III-Asbuitts\809783-P3.DWG

I HEREBY CERTIFY THAT THIS PLAN, SPECIFICATION, OR REPORT WAS PREPARED BY ME OR UNDER MY DIRECT SUPERVISION AND THAT I AM A DULY REGISTERED PROFESSIONAL ENGINEER UNDER THE LAWS OF THE STATE OF MINNESOTA.
 DATE _____ REG. NO. _____

NO.	DATE	BY	REVISION DESCRIPTION
1	8/22/01	EY	ADJ. FES 1 TO -0+25 PER PIONEER RIP RAP QUANTITIES

1326 ENERGY PARK DRIVE
 ST. PAUL, MINNESOTA 55108
 (651) 644-4389
Howard R Green Company
 CONSULTING ENGINEERS

CITY OF ELK RIVER
 TWIN LAKES TOWNHOMES 3RD ADDITION
 STREET AND UTILITY IMPROVEMENTS

STORM SEWER CROSSING
 PLAN AND PROFILE

SHEET NO.
P3

DRAWING NUMBER
 TWINL3.01
 5
 SAECO PRODUCTS • NEW HOPE, MINNESOTA
 REVISION BY PART NUMBER 8092