
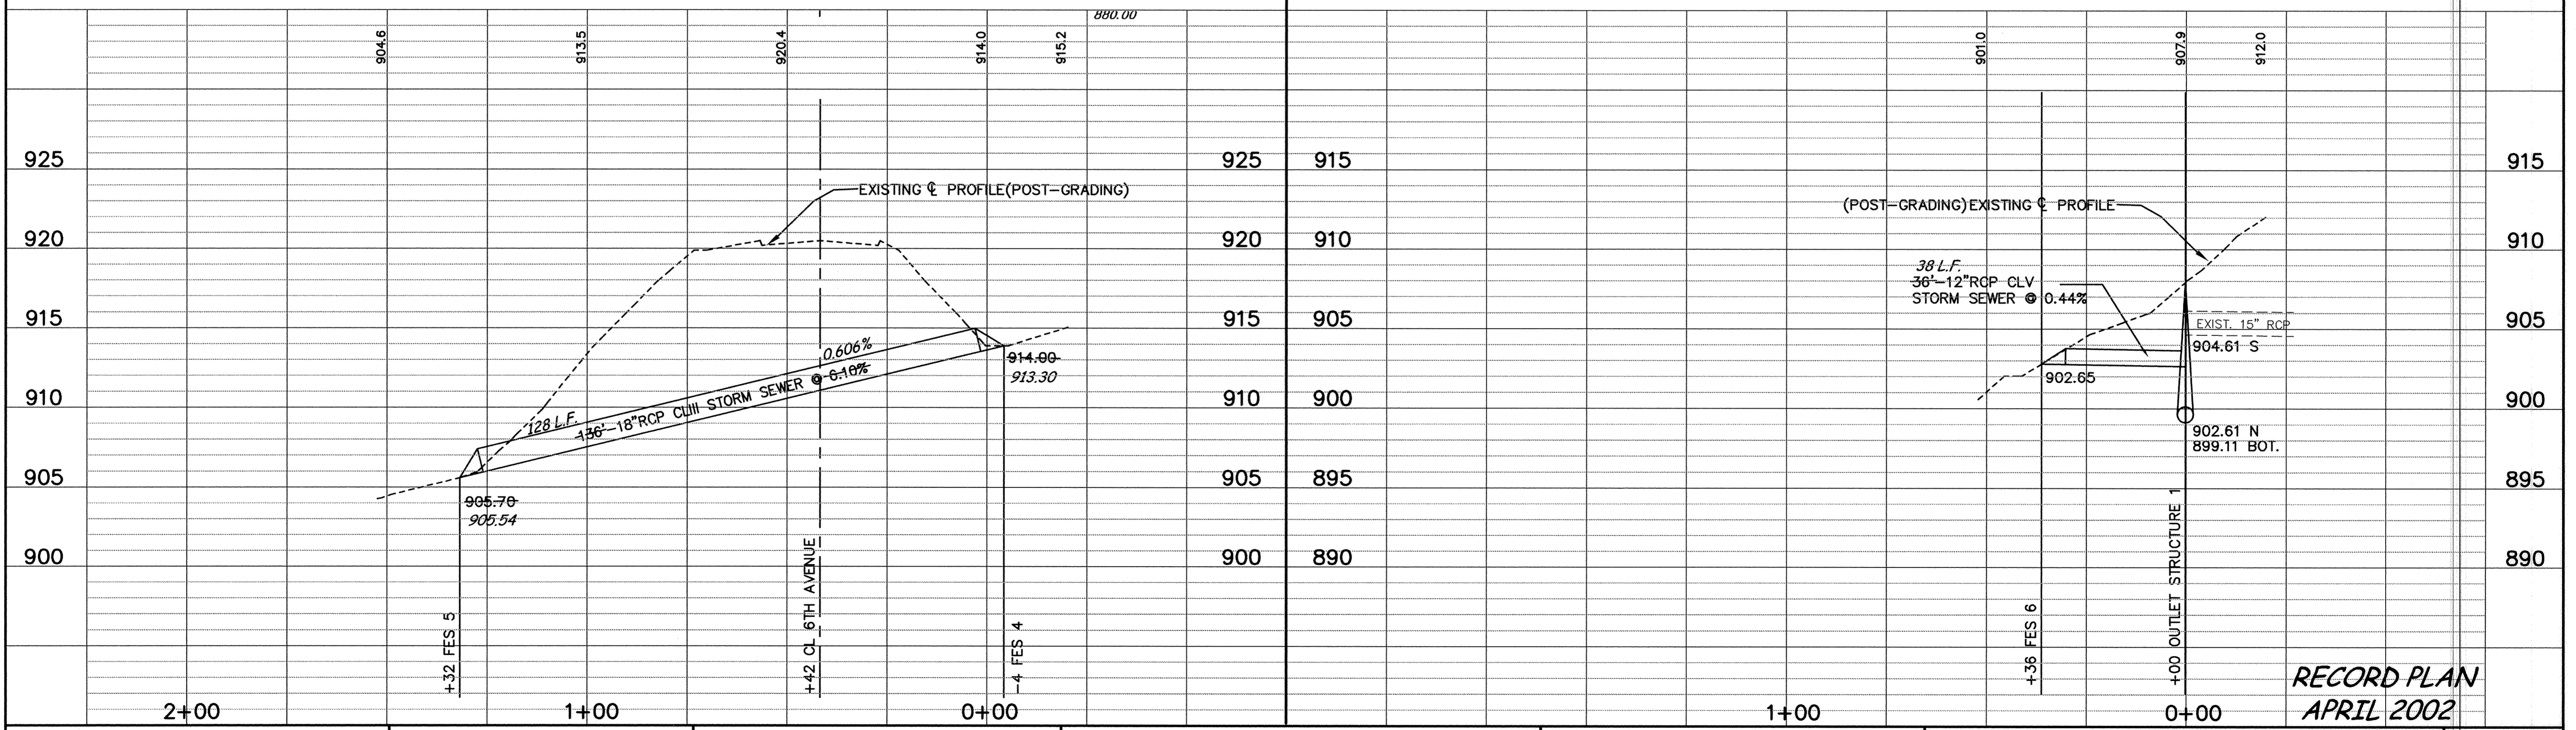
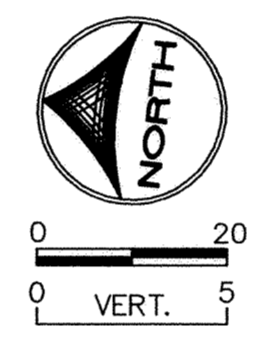
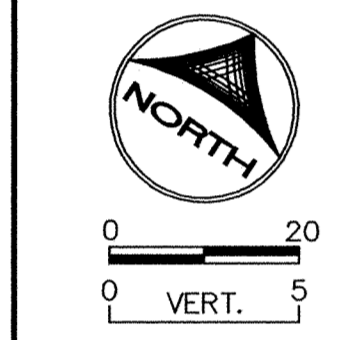
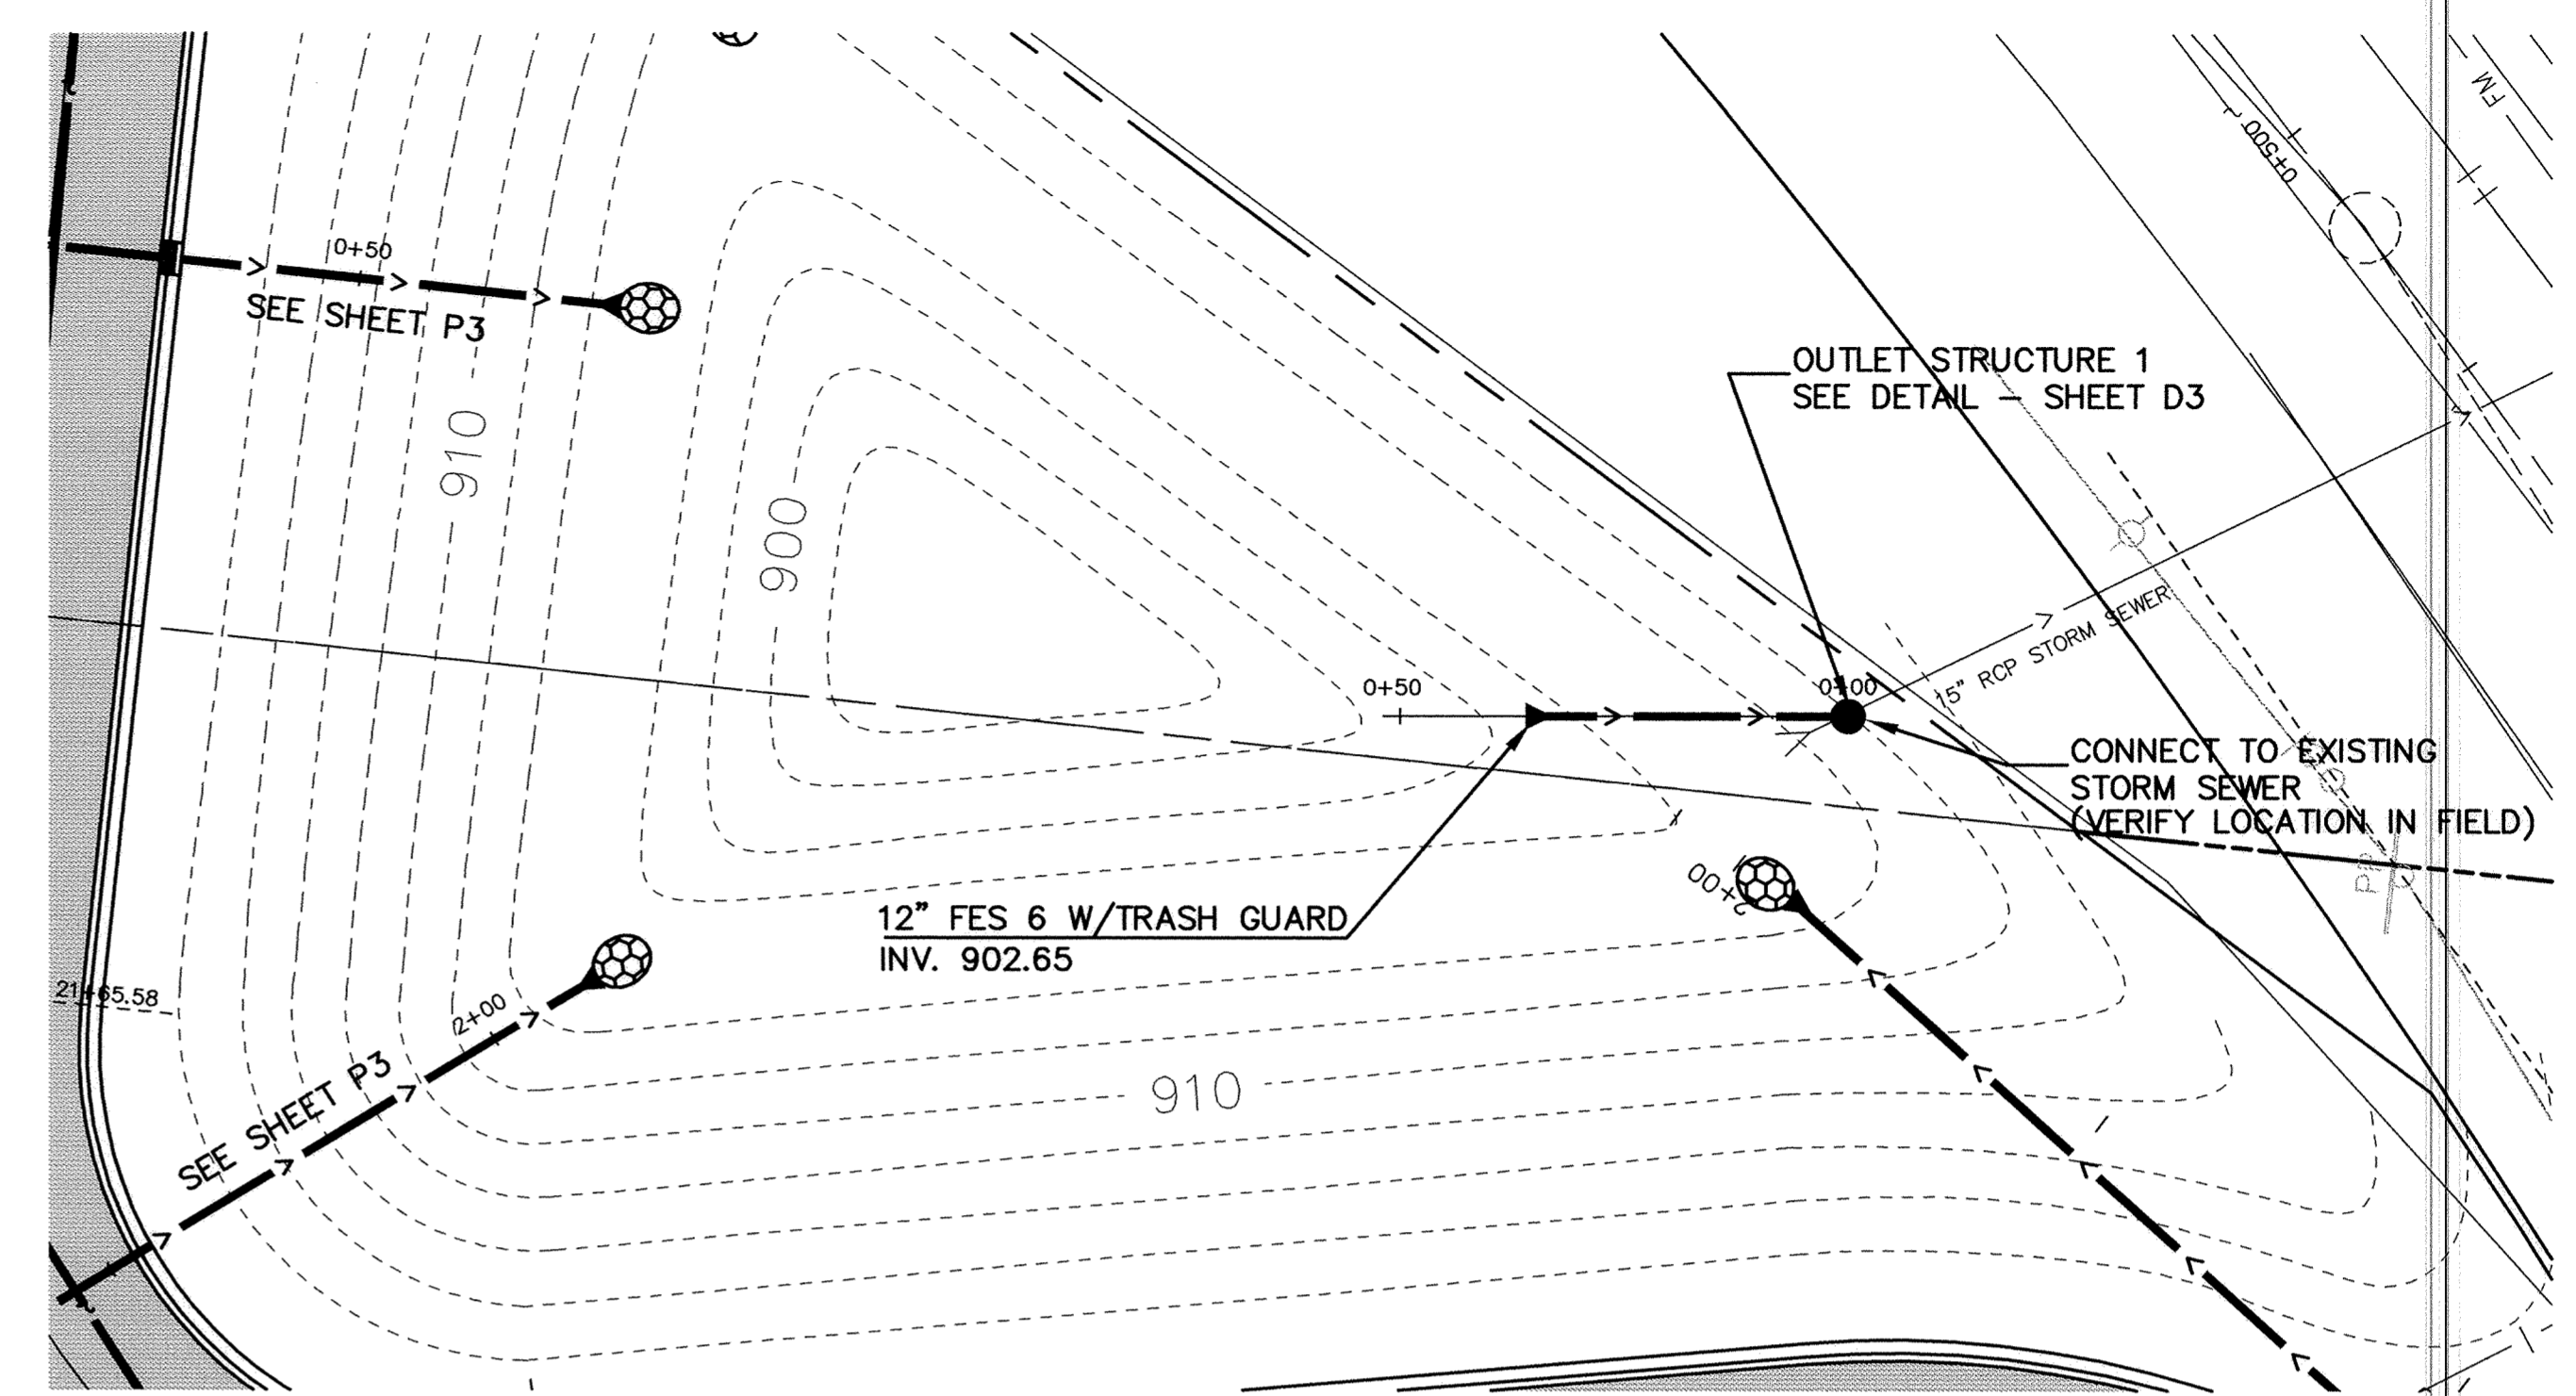


STORM SEWER CROSSINGS

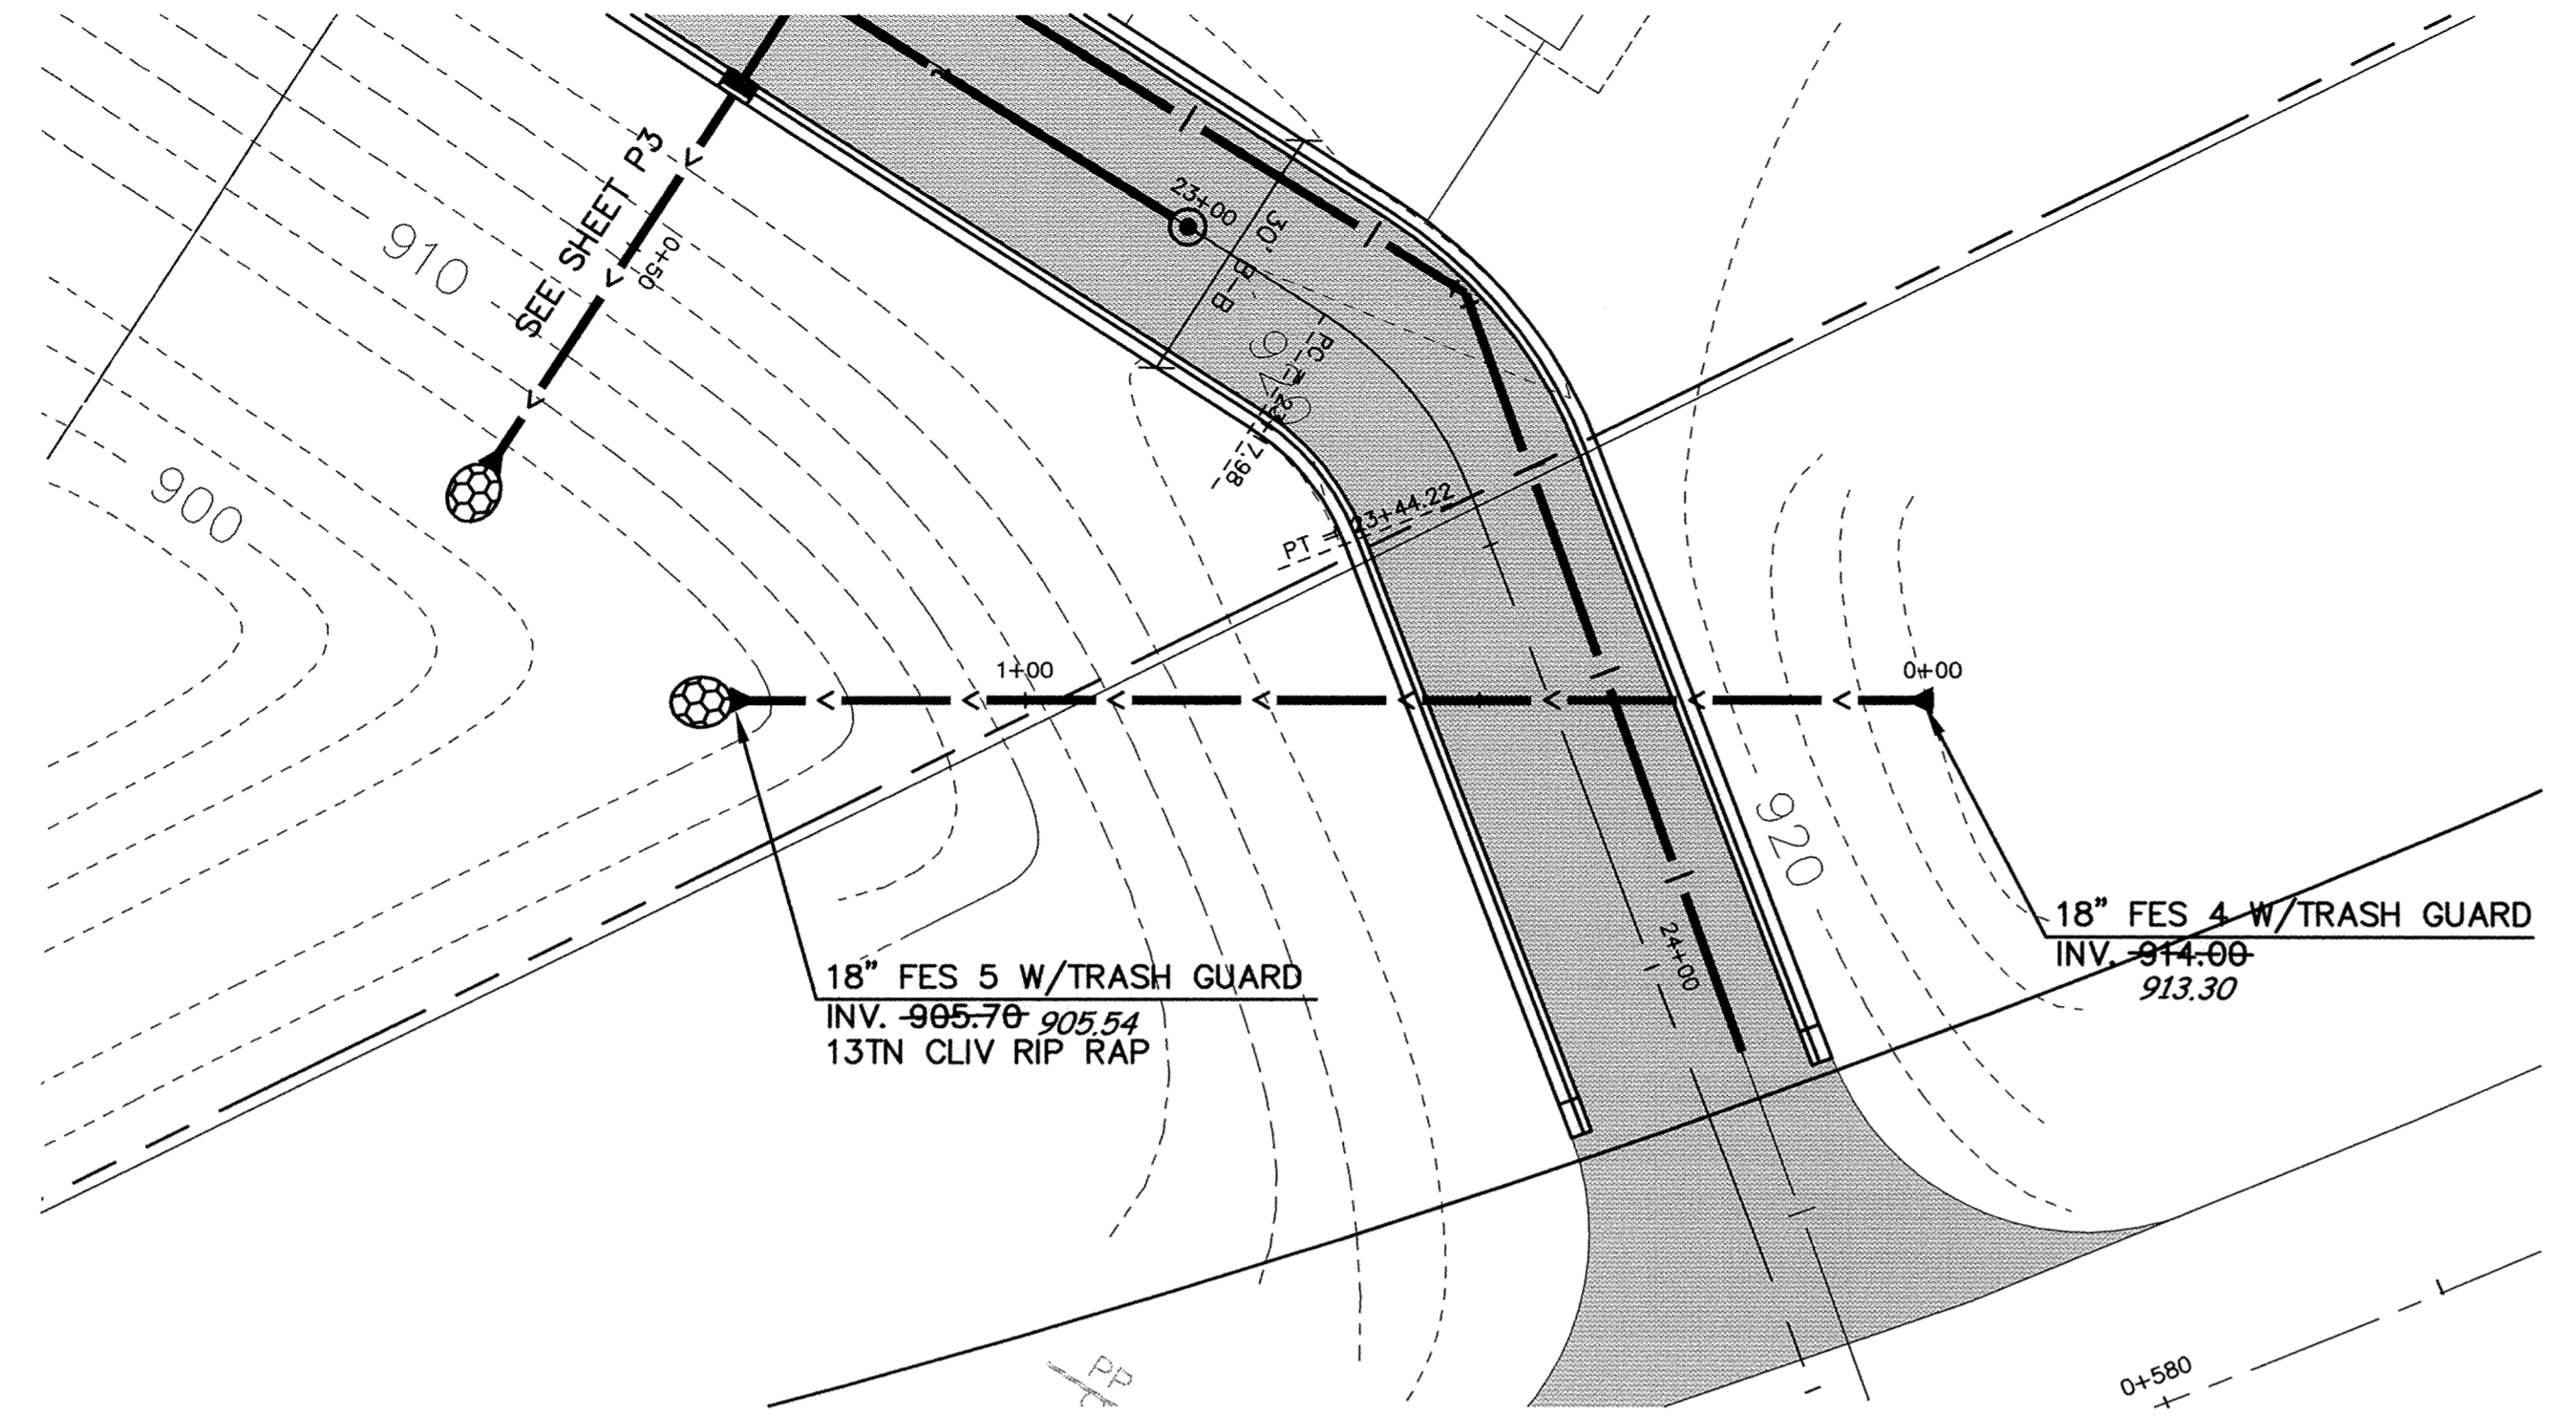

DESIGNED BY: TJM DRAWN BY: EY
 APPROVED BY: TJM JOB NUMBER 809782J
 CAD DATE: April 03, 2002 3:07:44 p.m.
 CAD FILE: 809783J\Phase III-Asbuilts\809783-P4.DWG

I HEREBY CERTIFY THAT THIS PLAN, SPECIFICATION, OR REPORT WAS PREPARED BY ME OR UNDER MY DIRECT SUPERVISION AND THAT I AM A DULY REGISTERED PROFESSIONAL ENGINEER UNDER THE LAWS OF THE STATE OF MINNESOTA.

DATE _____ REG. NO. _____

NO.	DATE	BY	REVISION DESCRIPTION
1	8/23/01	EY	PER CITY REVIEW

1326 ENERGY PARK DRIVE
ST. PAUL, MINNESOTA 55108
(651) 644-4389

Howard R. Green Company
CONSULTING ENGINEERS

CITY OF ELK RIVER
TWIN LAKES TOWNHOMES 3RD ADDITION
STREET AND UTILITY IMPROVEMENTS

STORM SEWER CROSSING
PLAN AND PROFILE

SHEET NO.
P4

RECORD PLAN
APRIL 2002

PROJECTS • NEW HOPKINS, MINNESOTA
 PREPARED BY PHILIP LANGRISH
 PROJECTS • NEW HOPKINS, MINNESOTA
 PREPARED BY PHILIP LANGRISH
 PROJECTS • NEW HOPKINS, MINNESOTA
 PREPARED BY PHILIP LANGRISH
 PROJECTS • NEW HOPKINS, MINNESOTA
 PREPARED BY PHILIP LANGRISH