
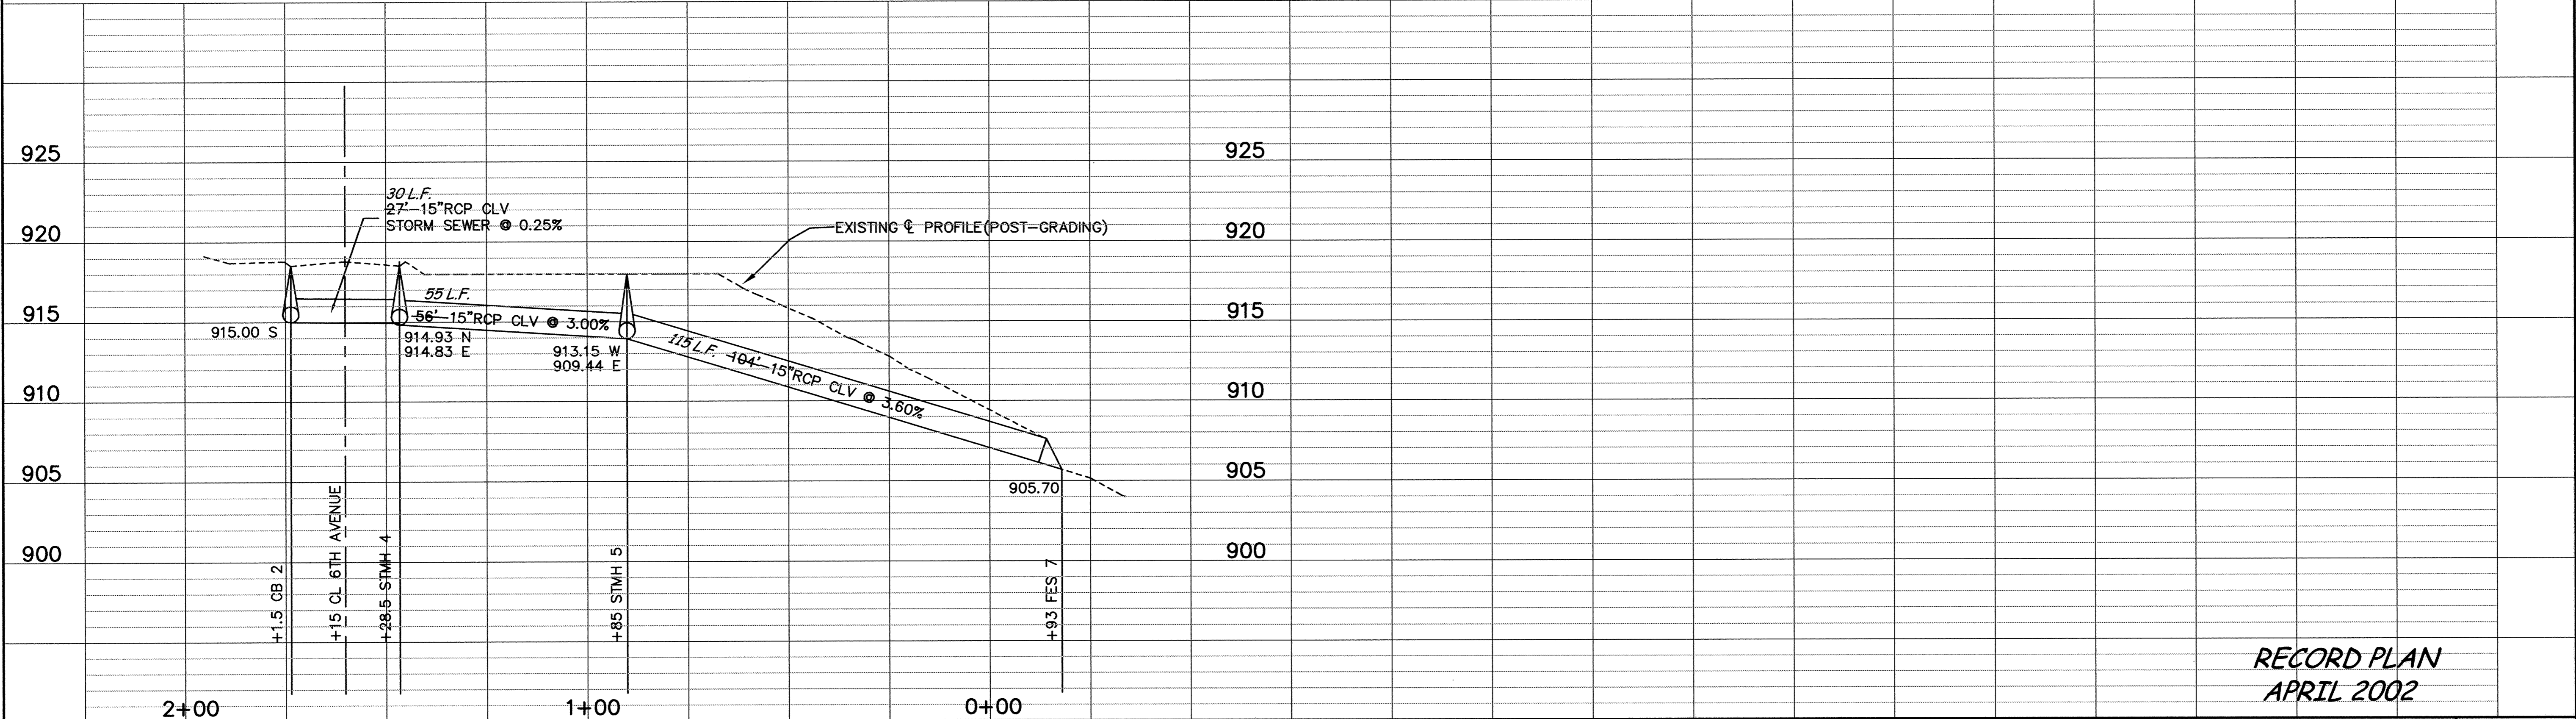


# STORM SEWER CROSSINGS

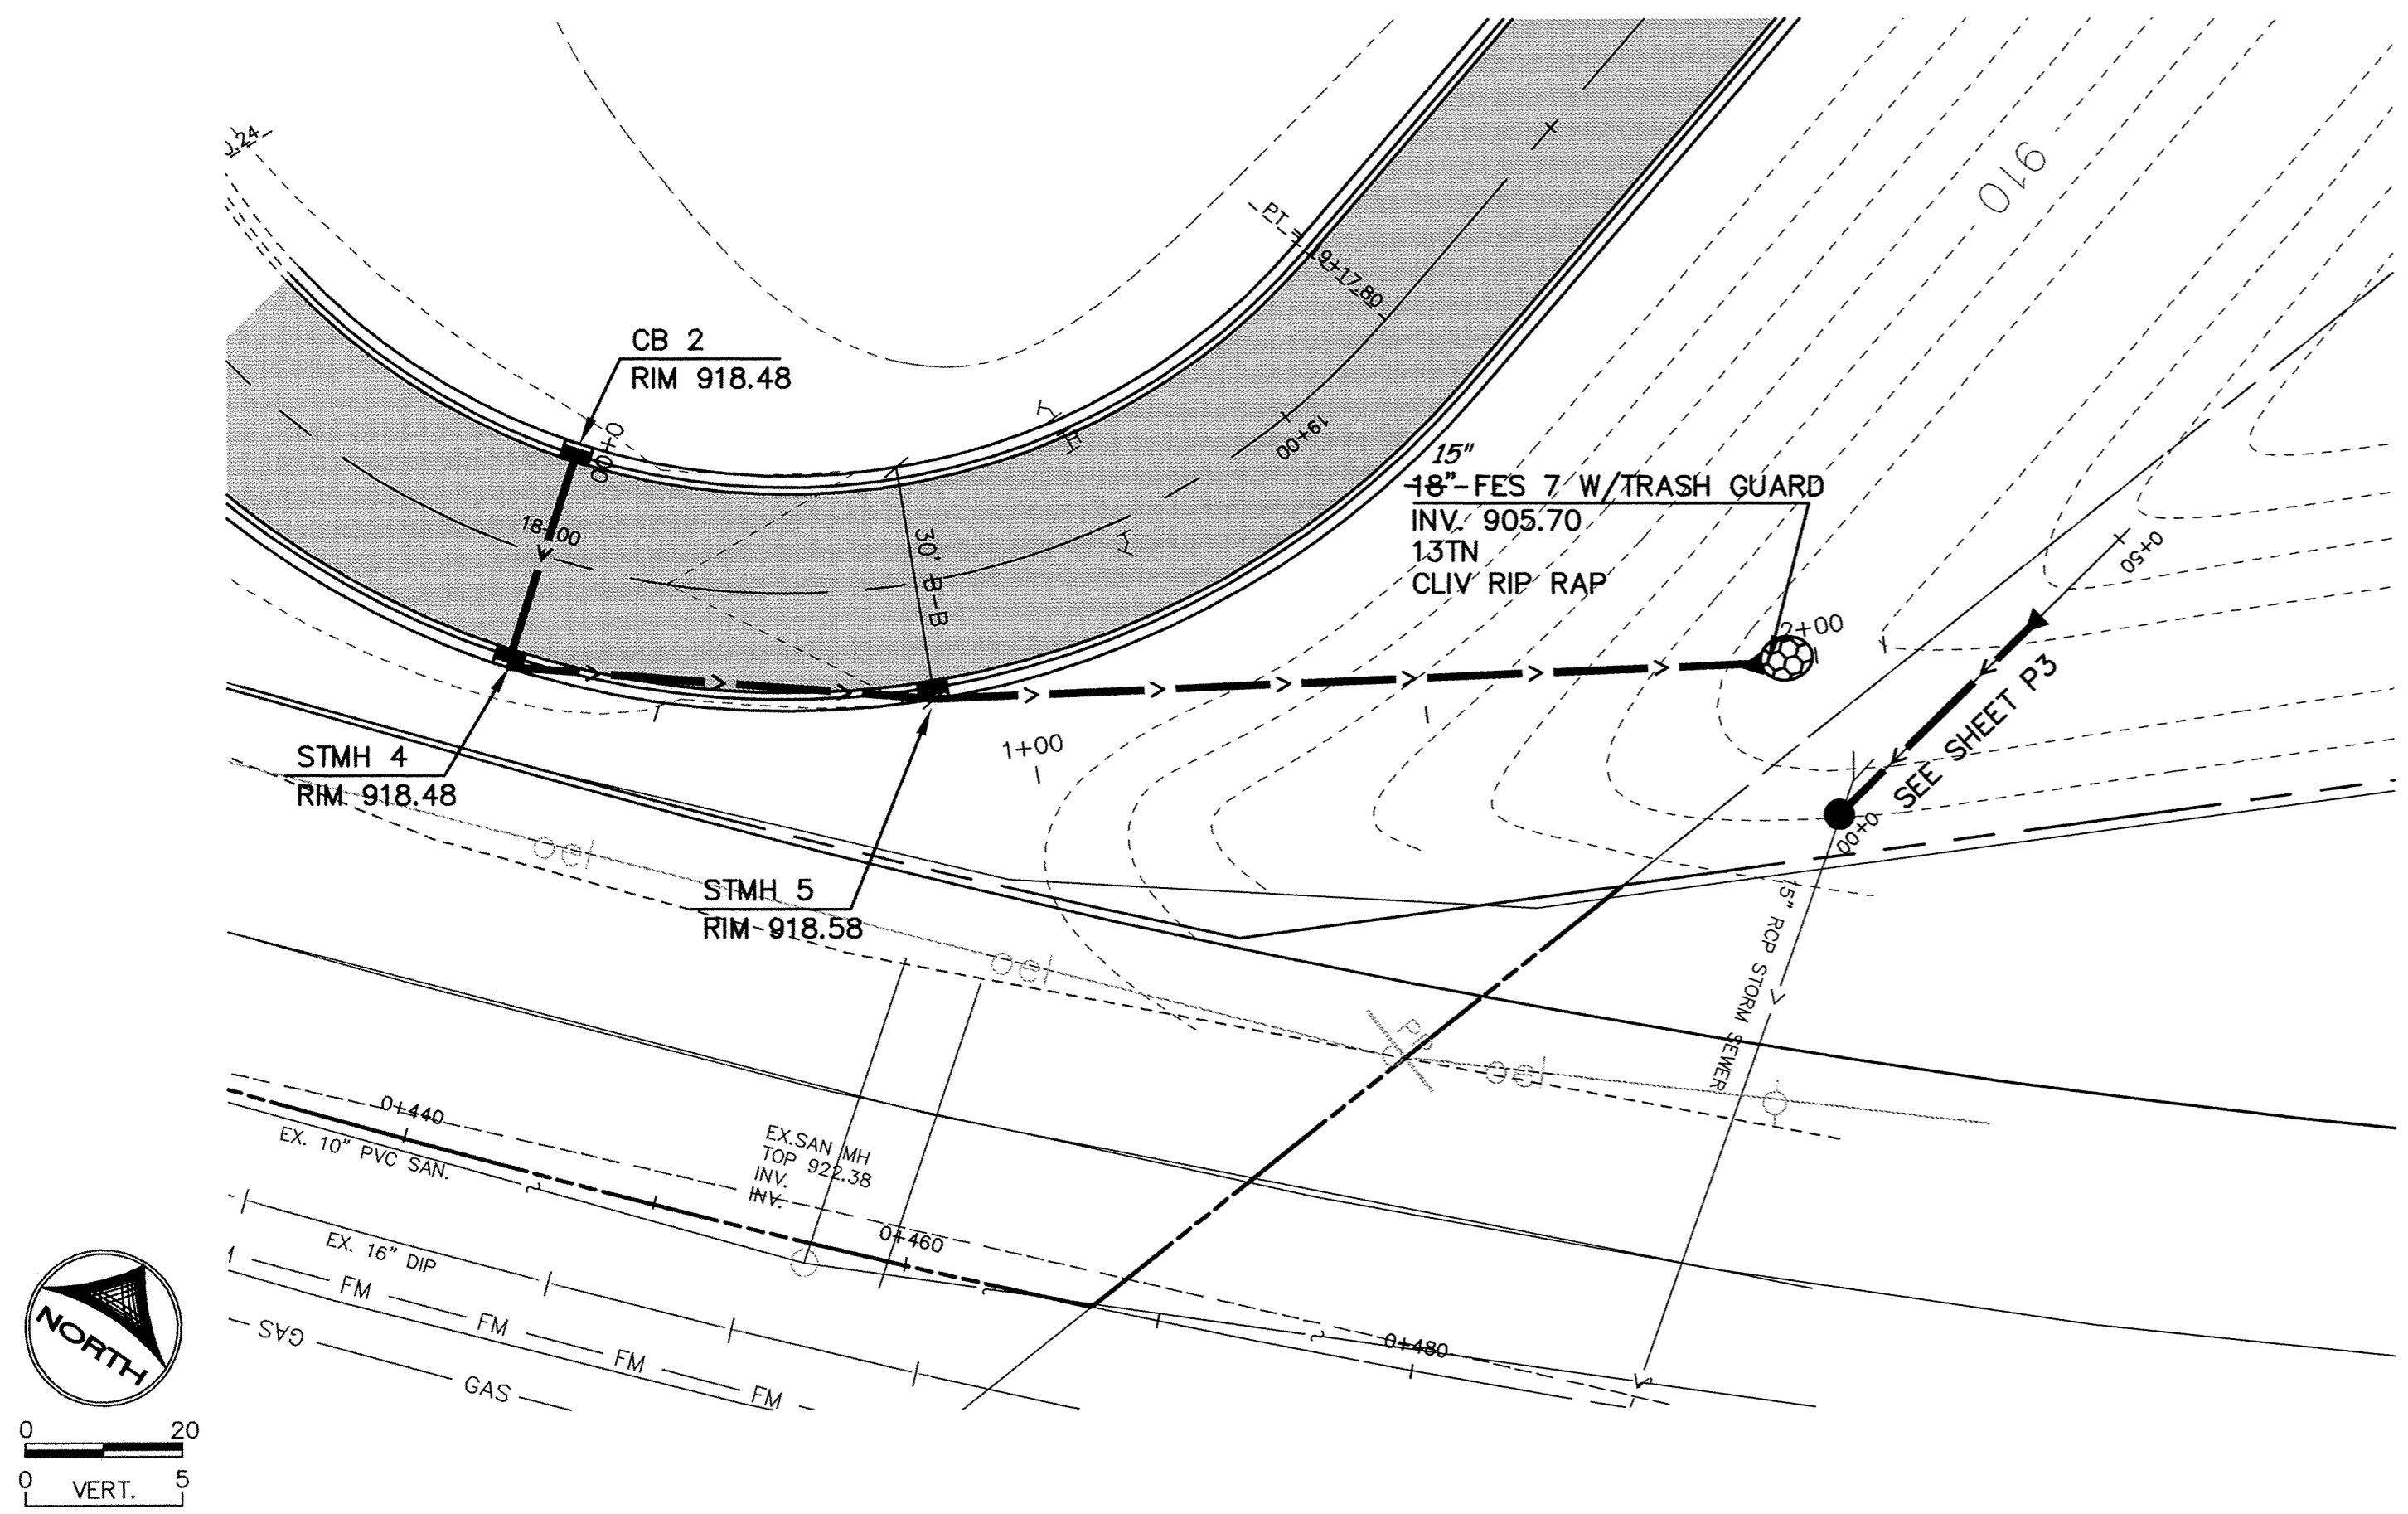

RECORD PLAN  
APRIL 2002

DESIGNED BY: TJM DRAWN BY: EY  
 APPROVED BY: TJM JOB NUMBER 809782J  
 CAD DATE: April 03, 2002 3:10:13 p.m.  
 CAD FILE: 809783J\Phase III-Asbuilts\809783-P5.DWG

I HEREBY CERTIFY THAT THIS PLAN, SPECIFICATION, OR REPORT WAS PREPARED BY ME OR UNDER MY DIRECT SUPERVISION AND THAT I AM A DULY REGISTERED PROFESSIONAL ENGINEER UNDER THE LAWS OF THE STATE OF MINNESOTA.  
 DATE: \_\_\_\_\_ REG. NO. \_\_\_\_\_

NO.	DATE	BY	REVISION DESCRIPTION
1	8/23/01	EY	PER CITY REVIEW

1326 ENERGY PARK DRIVE  
 ST. PAUL, MINNESOTA 55108  
 (651) 644-4389

Howard R. Green Company  
 CONSULTING ENGINEERS

CITY OF ELK RIVER  
 TWIN LAKES TOWNHOMES 3RD ADDITION  
 STREET AND UTILITY IMPROVEMENTS

STORM SEWER CROSSING  
 PLAN AND PROFILE

SHEET NO.  
**P5**