



**AERATION TANK ELECTRICAL PLAN**  
 SCALE: 1/2"=1'-0"  
 North ←  
 0 1 2 3 4 5 6  
 Graphic Scale

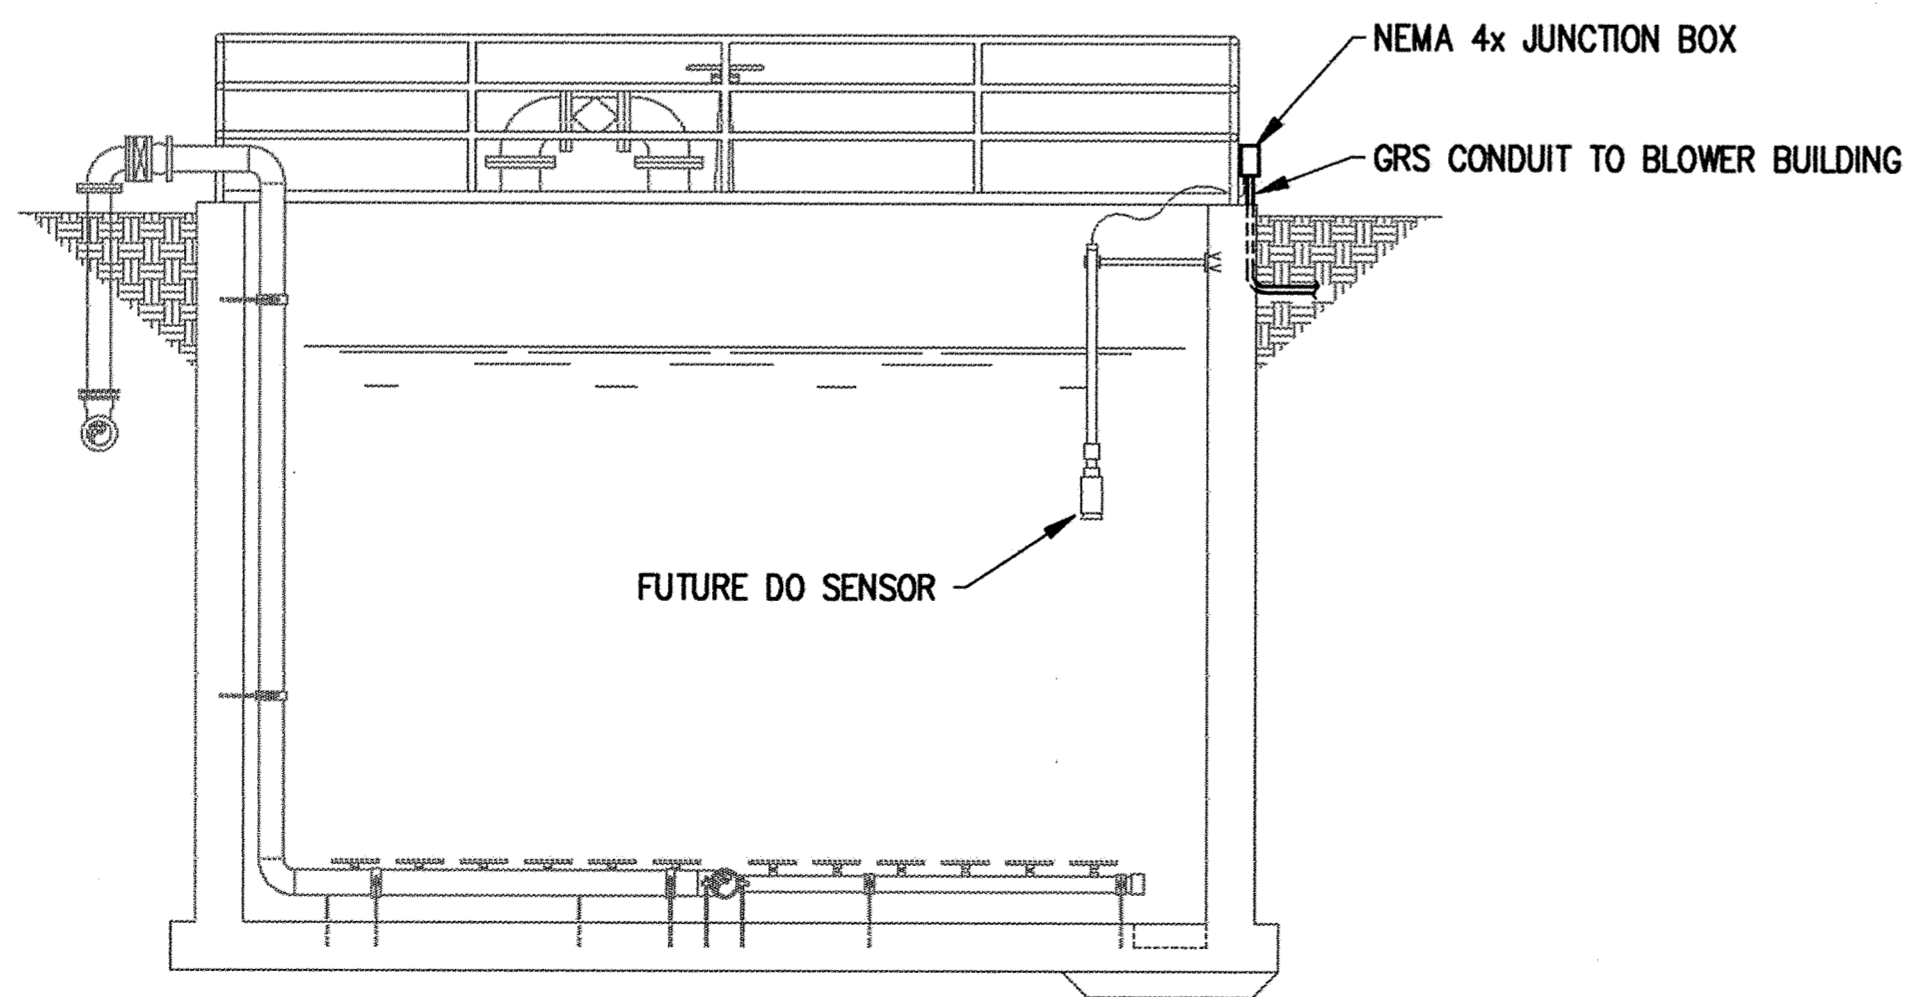

**AERATION TANK ELECTRICAL SECTION**  
 SCALE: 1/4"=1'-0"  
 0 1 2 3 4 6 8 12  
 Graphic Scale

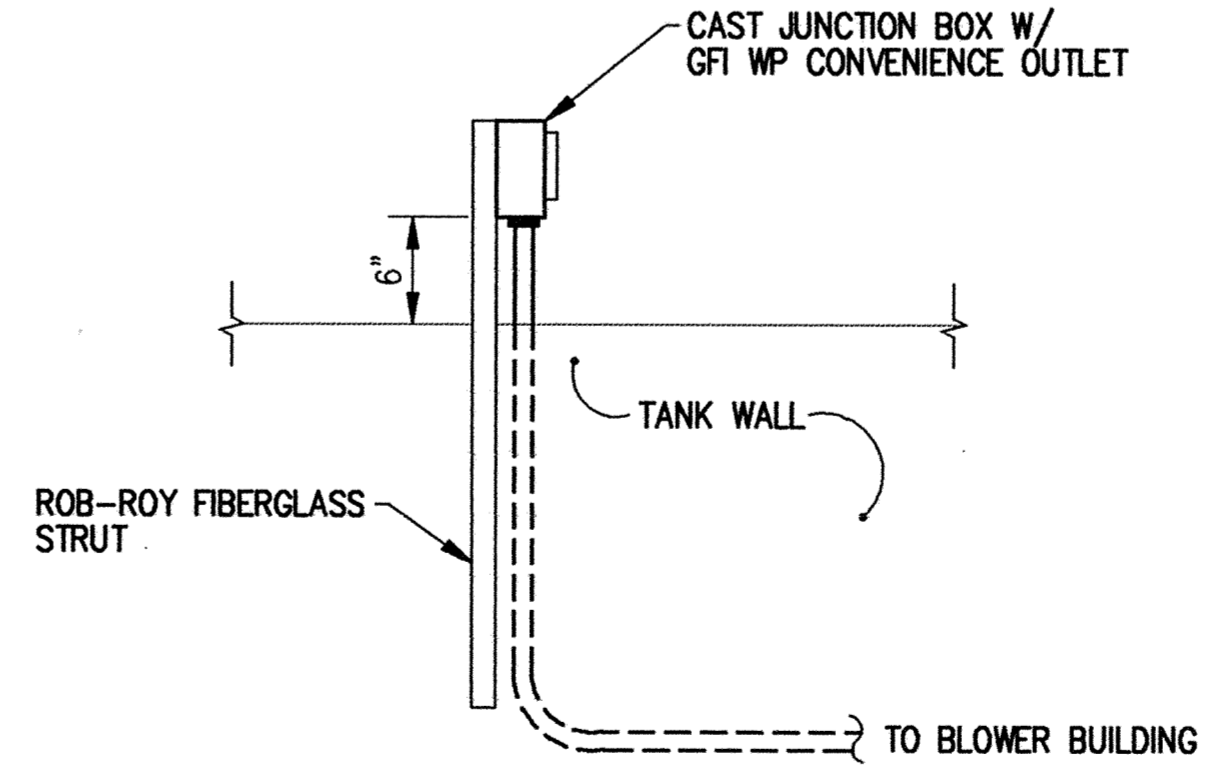

**AERATION TANK OUTLET DETAIL**  
 NO SCALE

This drawing was prepared by:  
 Kaeding & Associates, Inc.  
 7300 France Avenue South  
 Suite 330  
 Minneapolis, MN 55435  
 Telephone: (612) 831-0317  
 Fax: (612) 831-2179

I HEREBY CERTIFY THAT THIS PLAN, SPECIFICATION, OR REPORT WAS PREPARED BY ME OR UNDER MY DIRECT SUPERVISION AND THAT I AM A DULY REGISTERED PROFESSIONAL ENGINEER UNDER THE LAWS OF THE STATE OF MINNESOTA.  
 DATE 06 OCT 95 REG. NO. 9955

**MSA**  
 CONSULTING ENGINEERS  
 1326 ENERGY PARK DRIVE  
 ST. PAUL, MINNESOTA 55108  
 (612) 644-4389  
 5075 WAYZATA BLVD. SUITE 225  
 MINNEAPOLIS, MINNESOTA 55441  
 (612) 546-0432

REVISIONS	DATE	DESCRIPTION

DESIGNED	PPK
CHECKED	PPK
DRAWN	JGB/DTB
GRAPHIC SCALE	
0	HORIZ.
0	VERT.

**CITY OF ELK RIVER**  
 WASTEWATER TREATMENT FACILITIES  
 AERATION TANK ELECTRICAL PLAN & DETAILS

**E21**  
 DATE OCT 1995 SHEET 107 OF 112 SHEETS PROJECT NO. 230-151