



ELEVATION - LABORATORY CABINETS
SCALE: 3/8" = 1'-0"

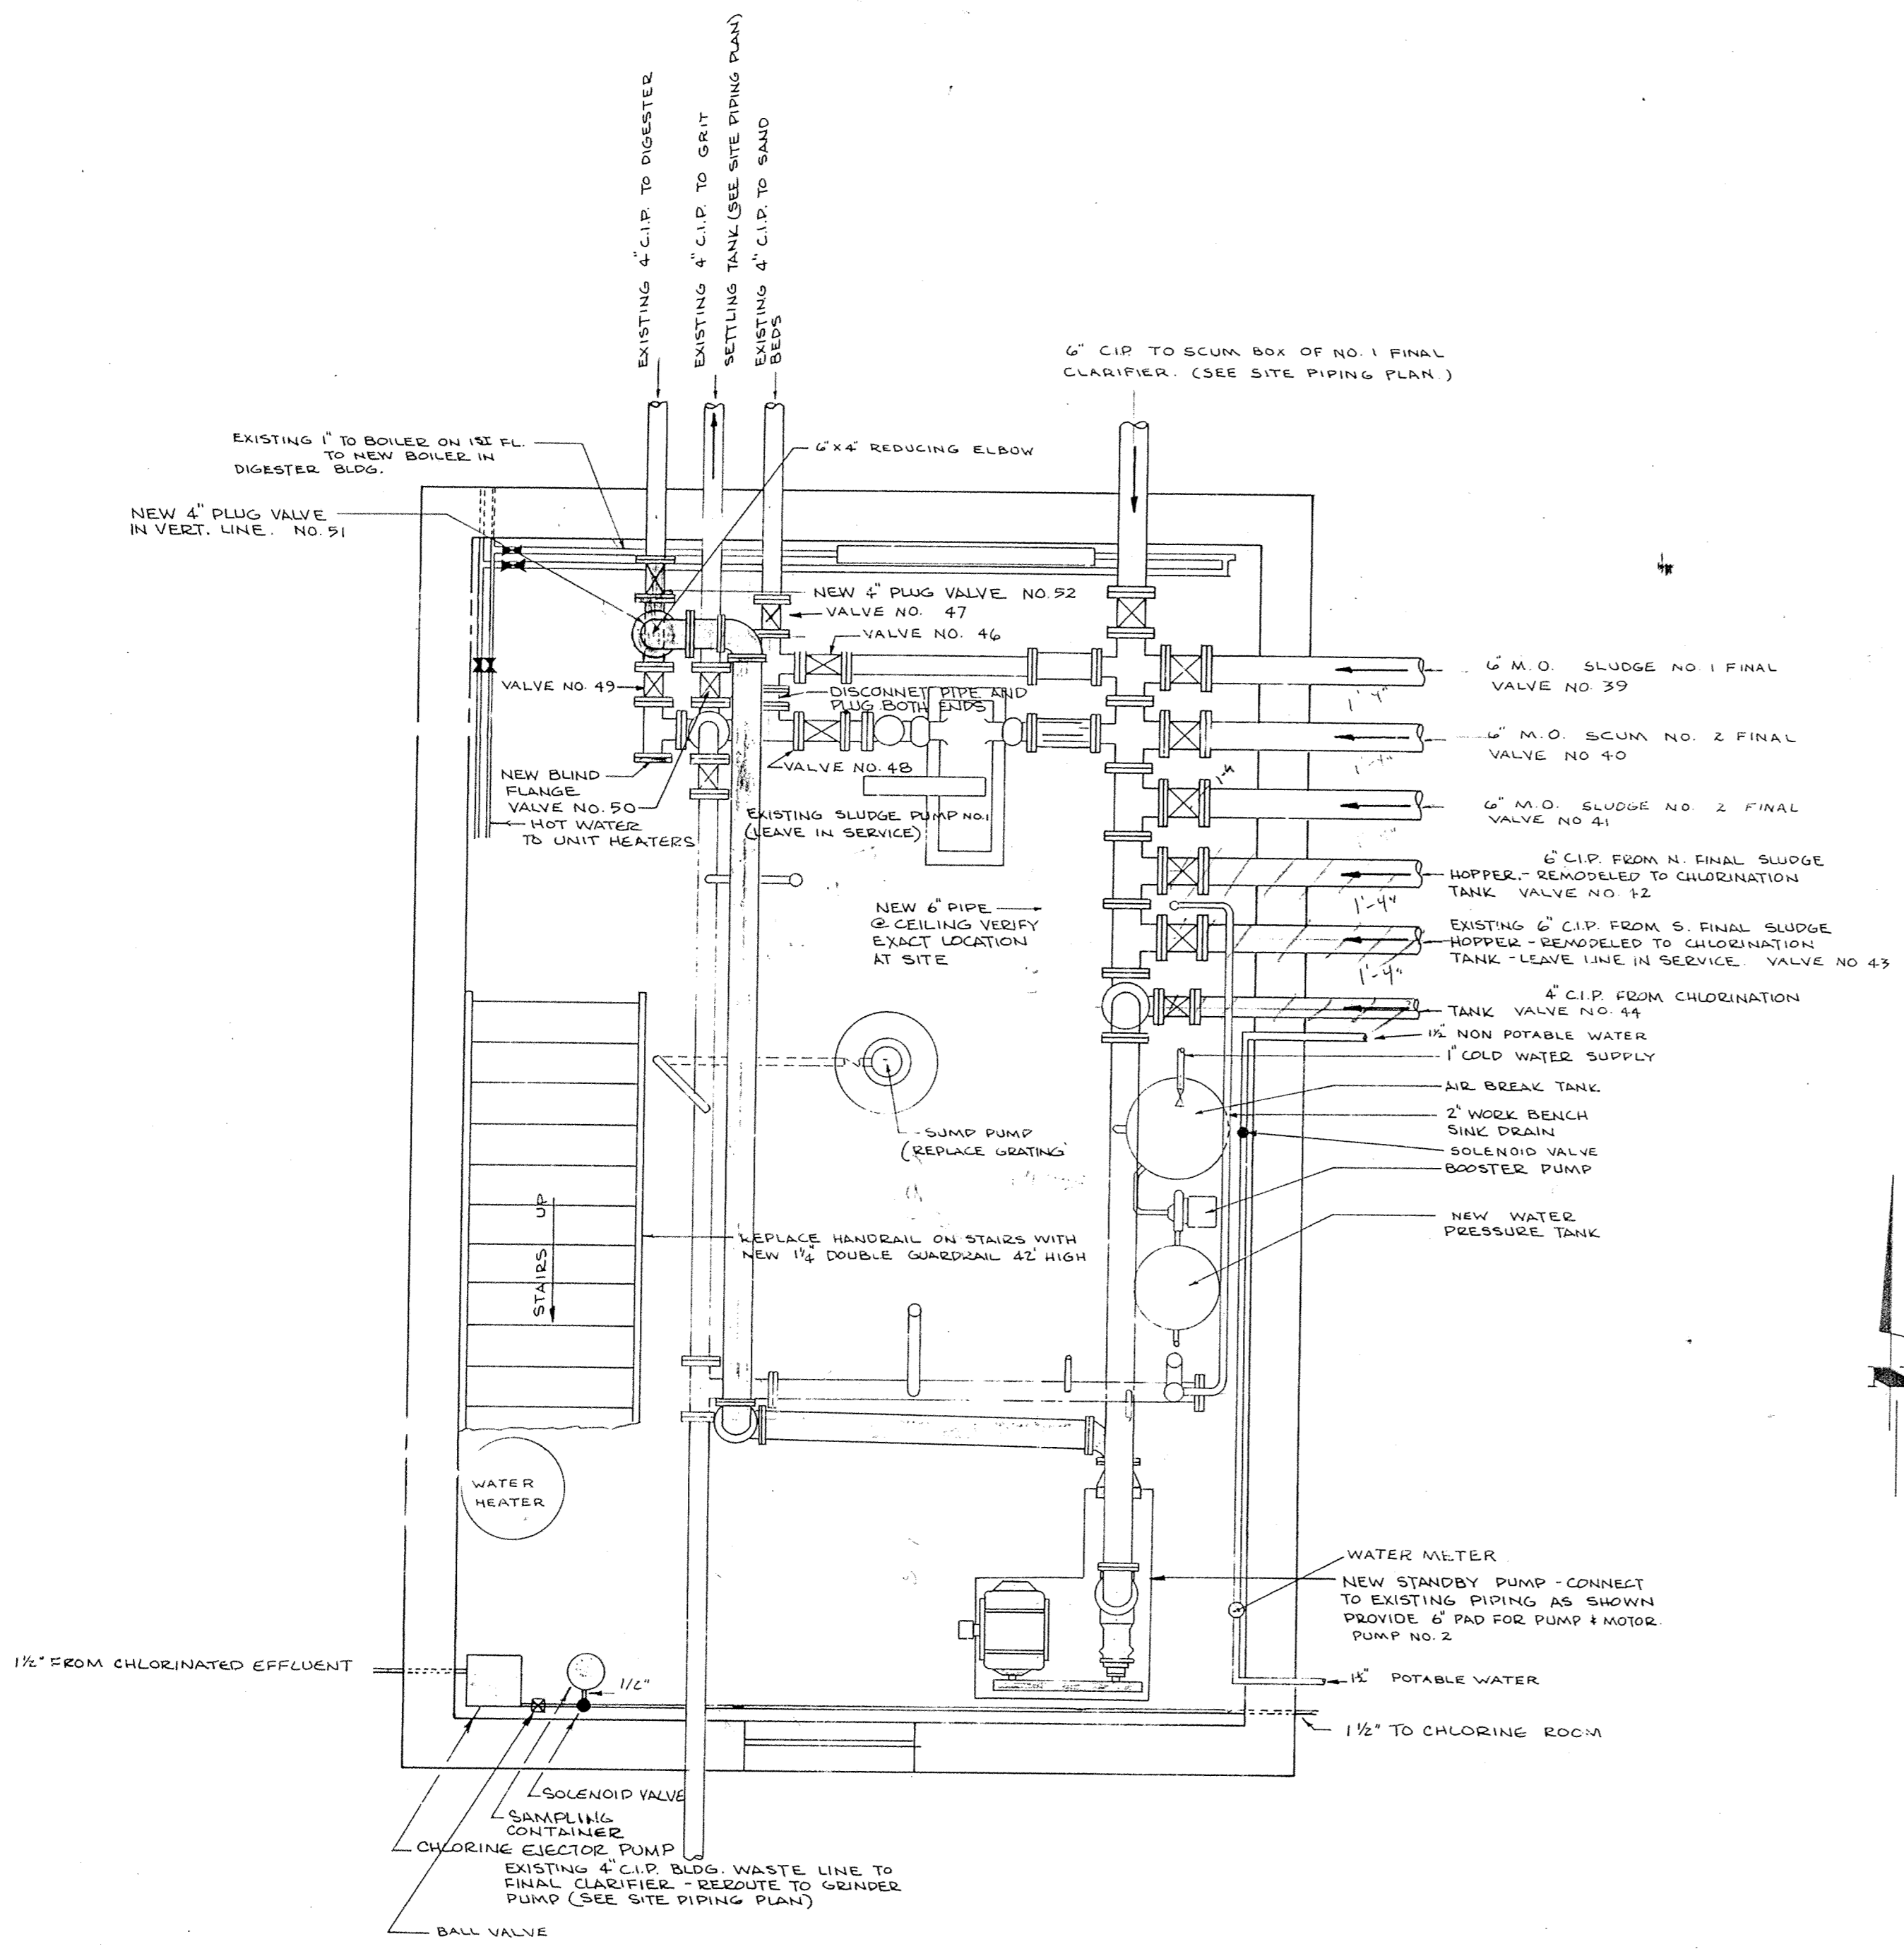

CONTROL BLDG. BASEMENT FLOOR
SCALE: 3/8" = 1'-0"

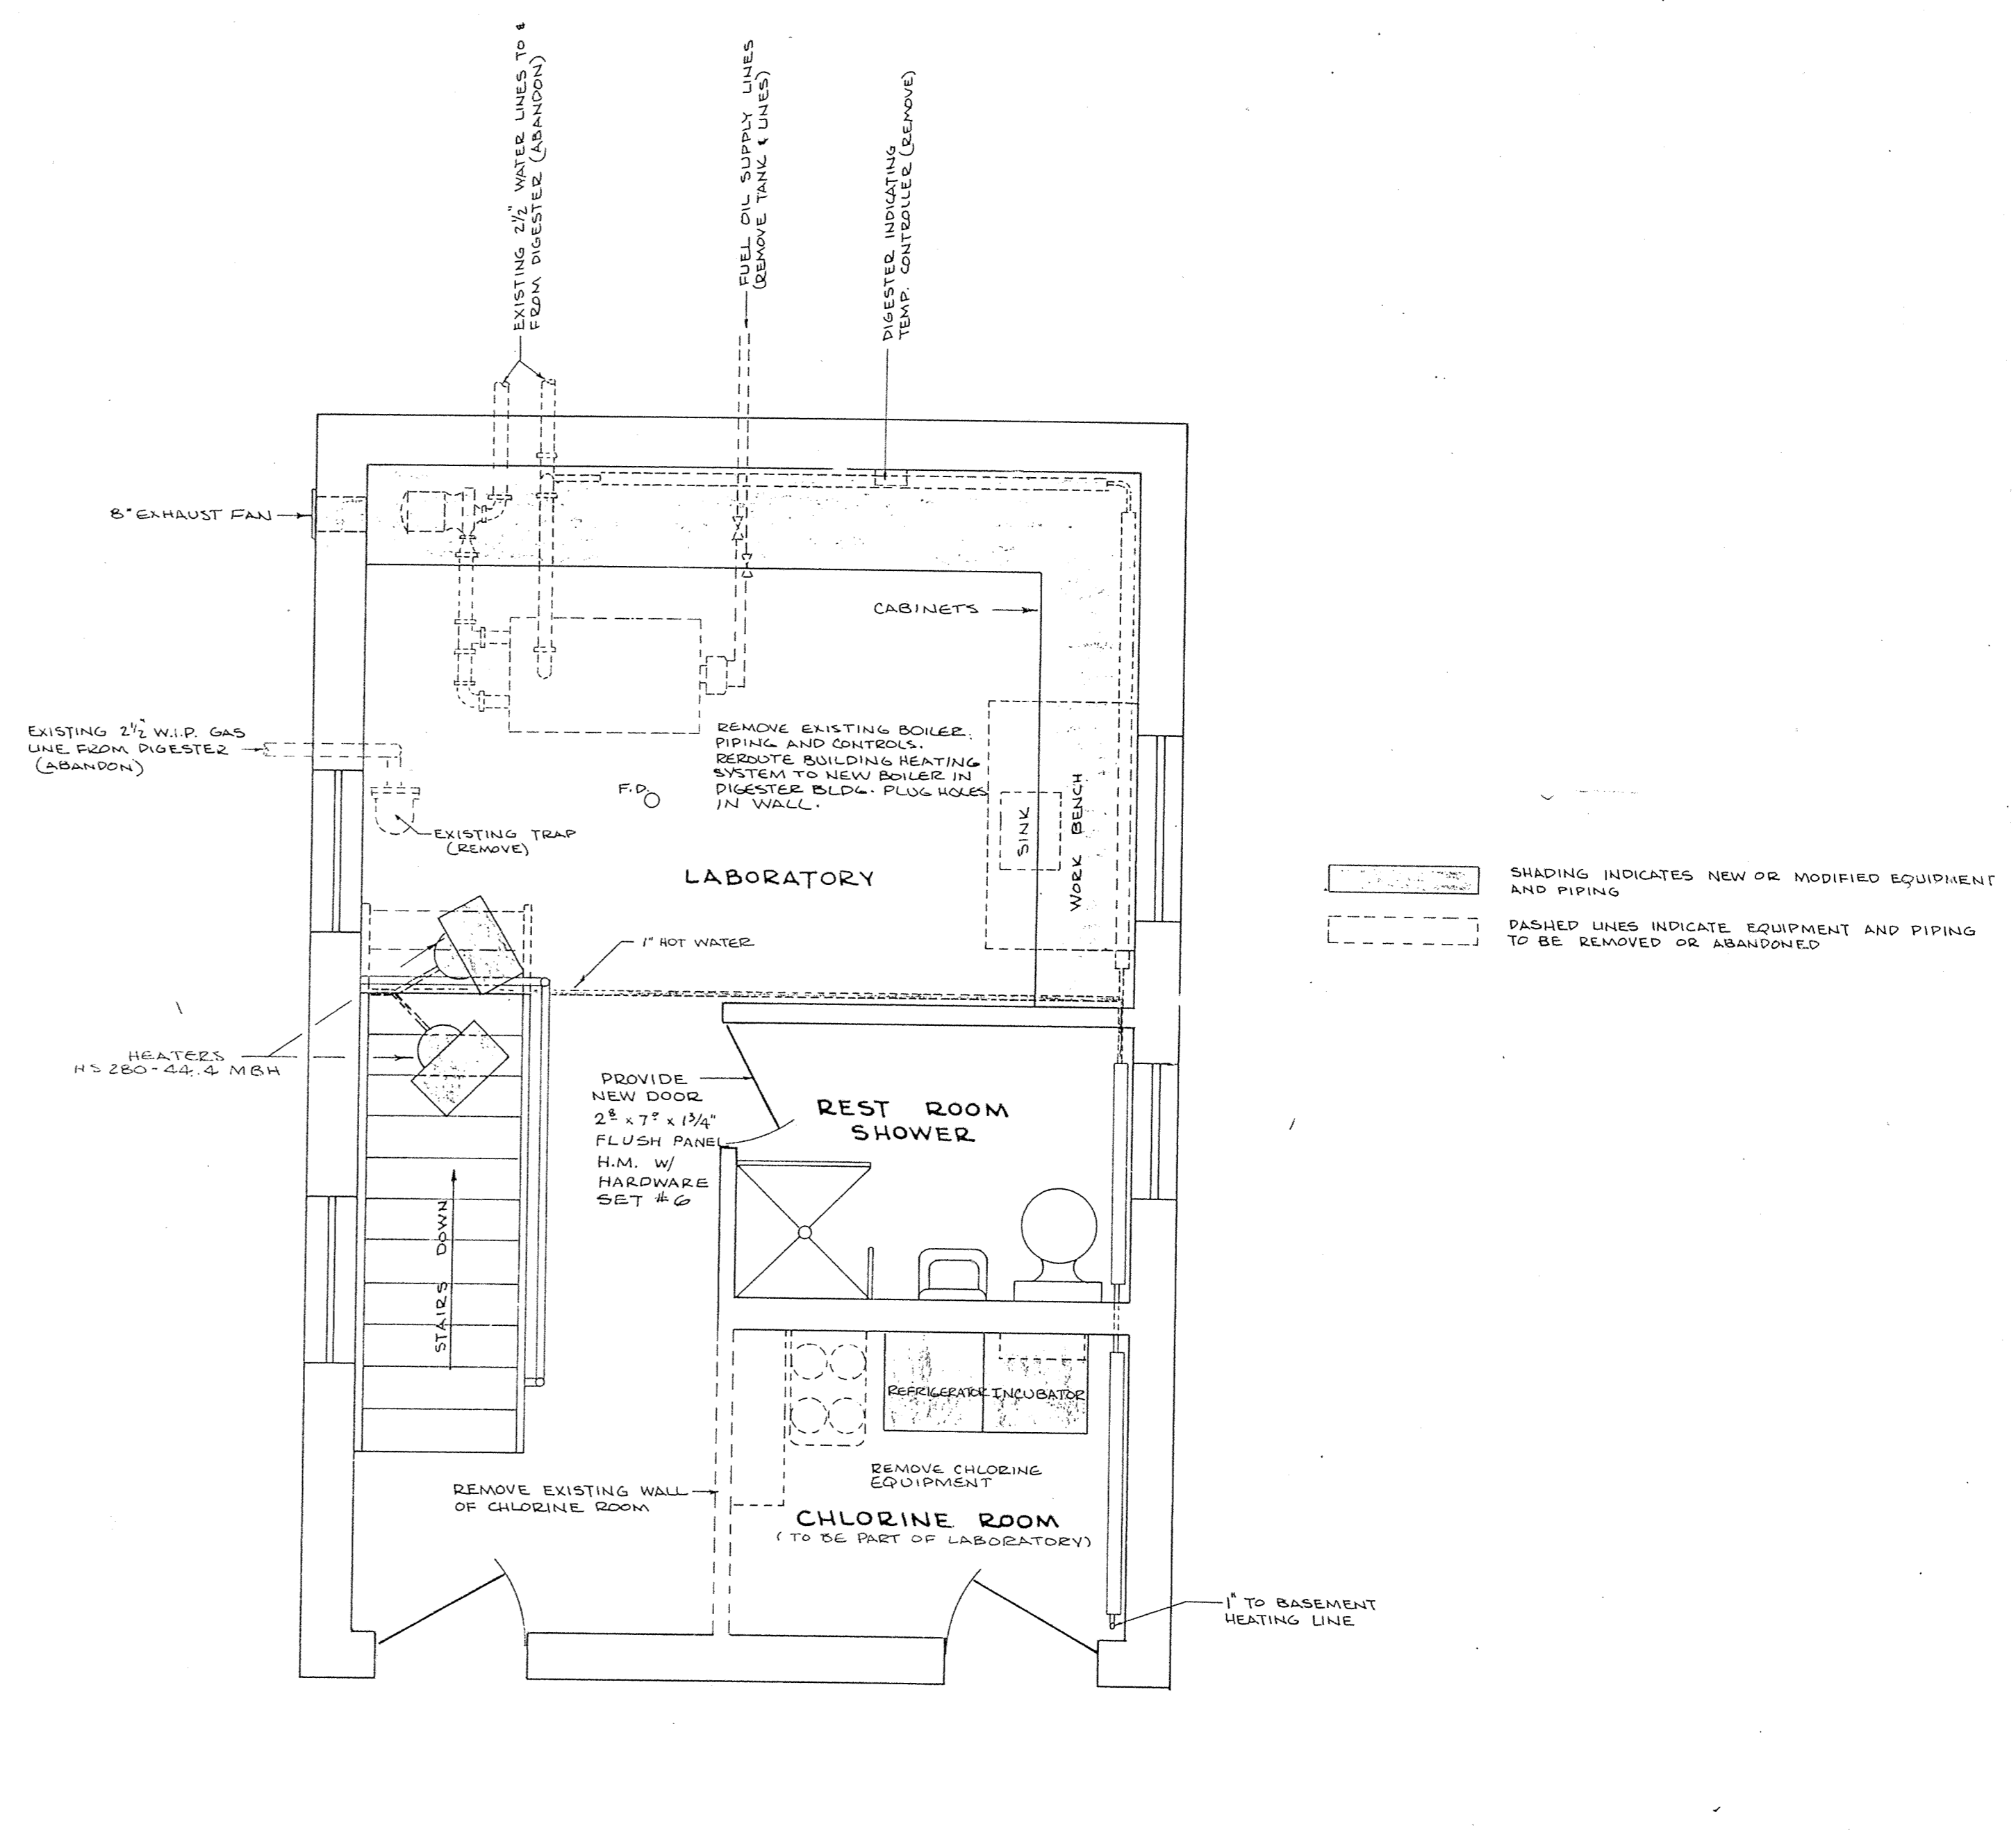

CONTROL BLDG. 1ST FLOOR
SCALE: 3/8" = 1'-0"

NO.	DATE	BY	REVISIONS
D	2-29-77	TLC	AS BUILT
C	9-30-77	J.R.C.	ADDED 2-4" PLUG VALVES, REDUCING ELBOW, 1/4" TEE
B	2-23-77	J.R.C.	ADDED NOTE TO POTABLE WATER SUPPLY & MISC. REVISION
A	9-25-76	J.R.C.	CHANGED ABANDONED LINED TO SAND BEDS TO LIVE LINE. REROUTED W.P. PUMP

DESIGNED K.L.V.	CHECKED K.L.V.
DRAWN J.R.C.	APPROVED W.H.M.
DATE 8/26/75	COMM.

I HEREBY CERTIFY THAT THIS PLAN WAS PREPARED BY ME OR UNDER MY DIRECT SUPERVISION AND THAT I AM A DULY REGISTERED PROFESSIONAL ENGINEER UNDER THE LAWS OF THE STATE OF MINNESOTA.

Wm. J. VanLaack
 DATE **Aug 29, 1975** REG. NO. **10159**

McCOMBS-KNUTSON ASSOCIATES, INC.
 CONSULTING ENGINEERS ■ LAND SURVEYERS ■ SITE PLANNERS
 MINNEAPOLIS, HUTCHINSON and MARSHALL, MINNESOTA

WASTE WATER TREATMENT FACILITIES
 FOR
ELK RIVER, MINNESOTA

SCALE AS NOTED	BOOK	PAGE
FILE NO. 2603		

CONTROL BUILDING MODIFICATIONS

SHEET 18	REV.
OF 31	