



**FLARE WIRING ONE-LINE DIAGRAM**  
NO SCALE

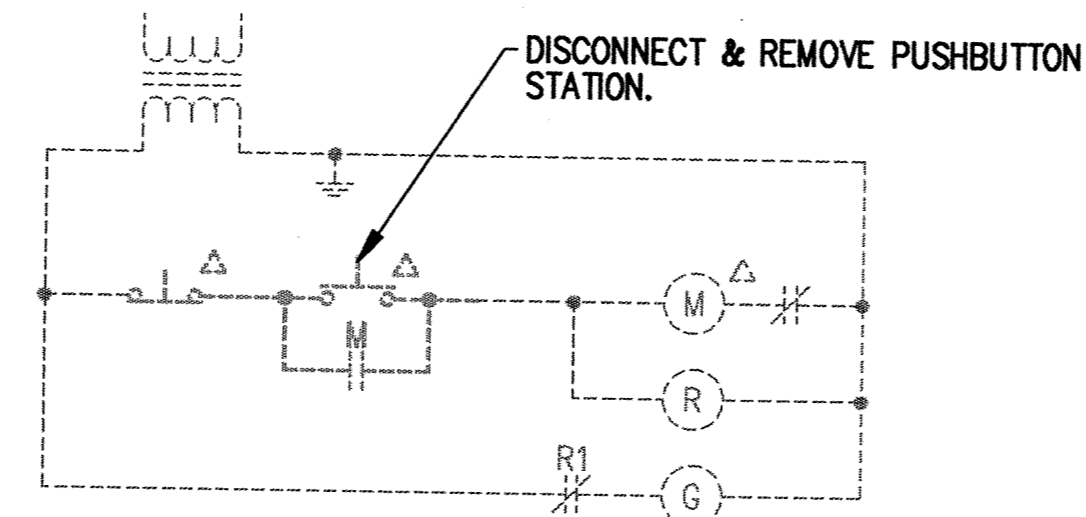


**PARTIAL SCHEMATIC-EXISTING DIGESTER STARTER SCHEMATIC**  
NO SCALE SLUDGE PUMPS-TYPICAL

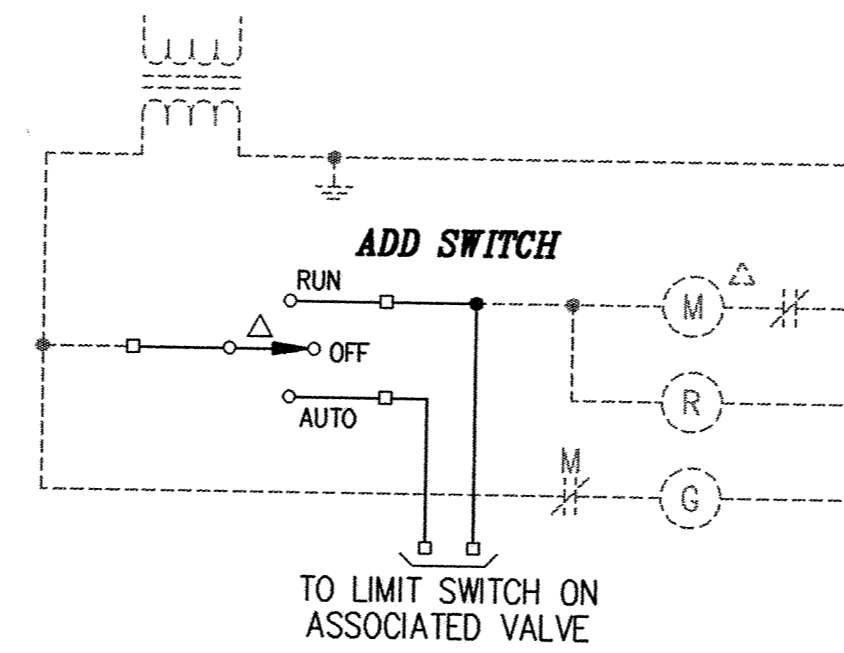


**PARTIAL SCHEMATIC-REVISED DIGESTER STARTER SCHEMATIC**  
NO SCALE SLUDGE PUMPS-TYPICAL

LEGEND	
SYMBOL	DESCRIPTION
△	MOTOR CONTROL CENTER MOUNTED
*	FIELD MOUNTED
◇	CONTROL PANEL MOUNTED

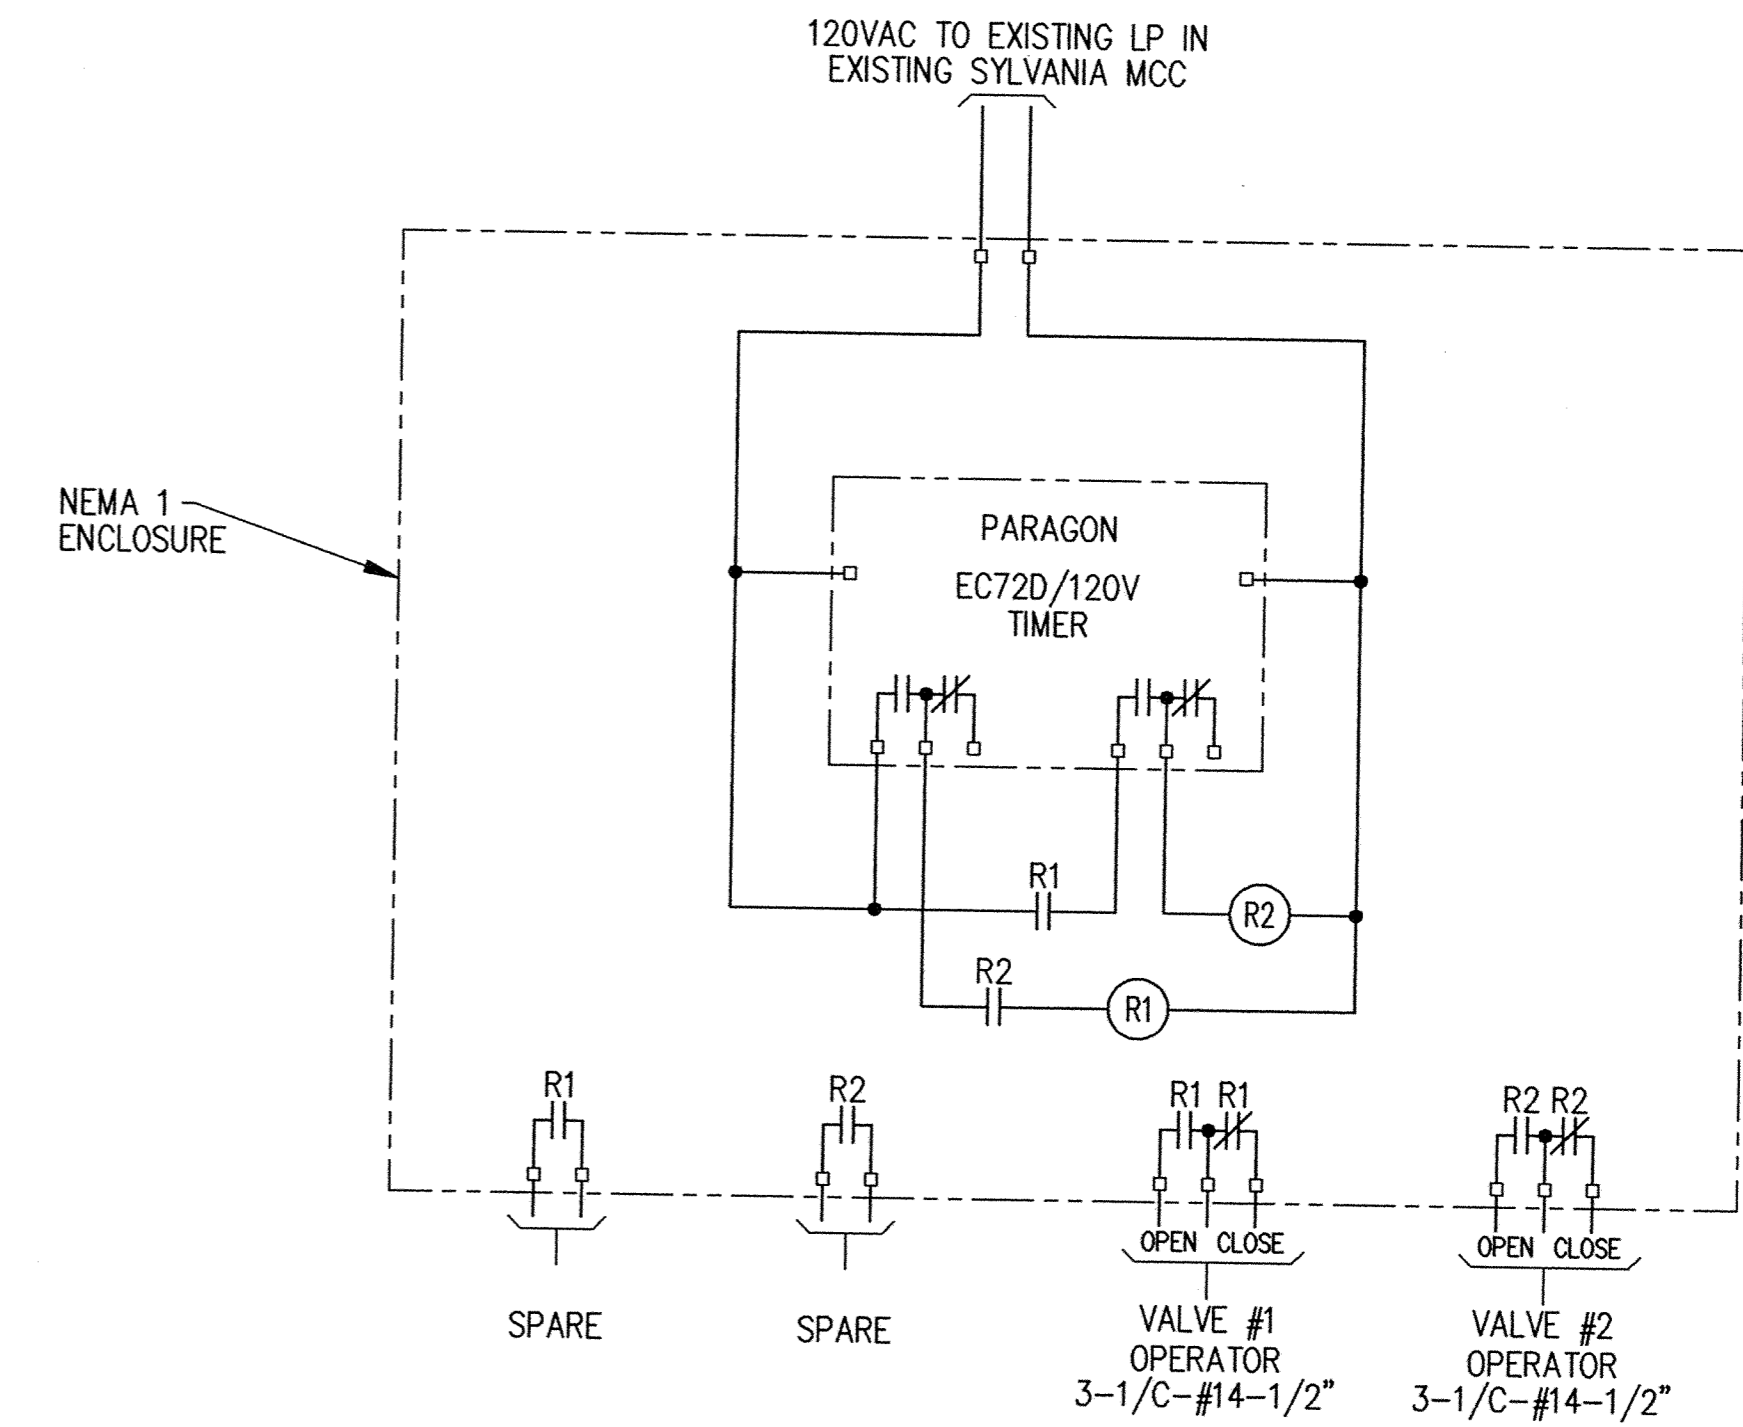

**DIGESTER BUILDING CONTROL PANEL**  
NO SCALE LOCATED AT MAIN LEVEL NEAR MCC

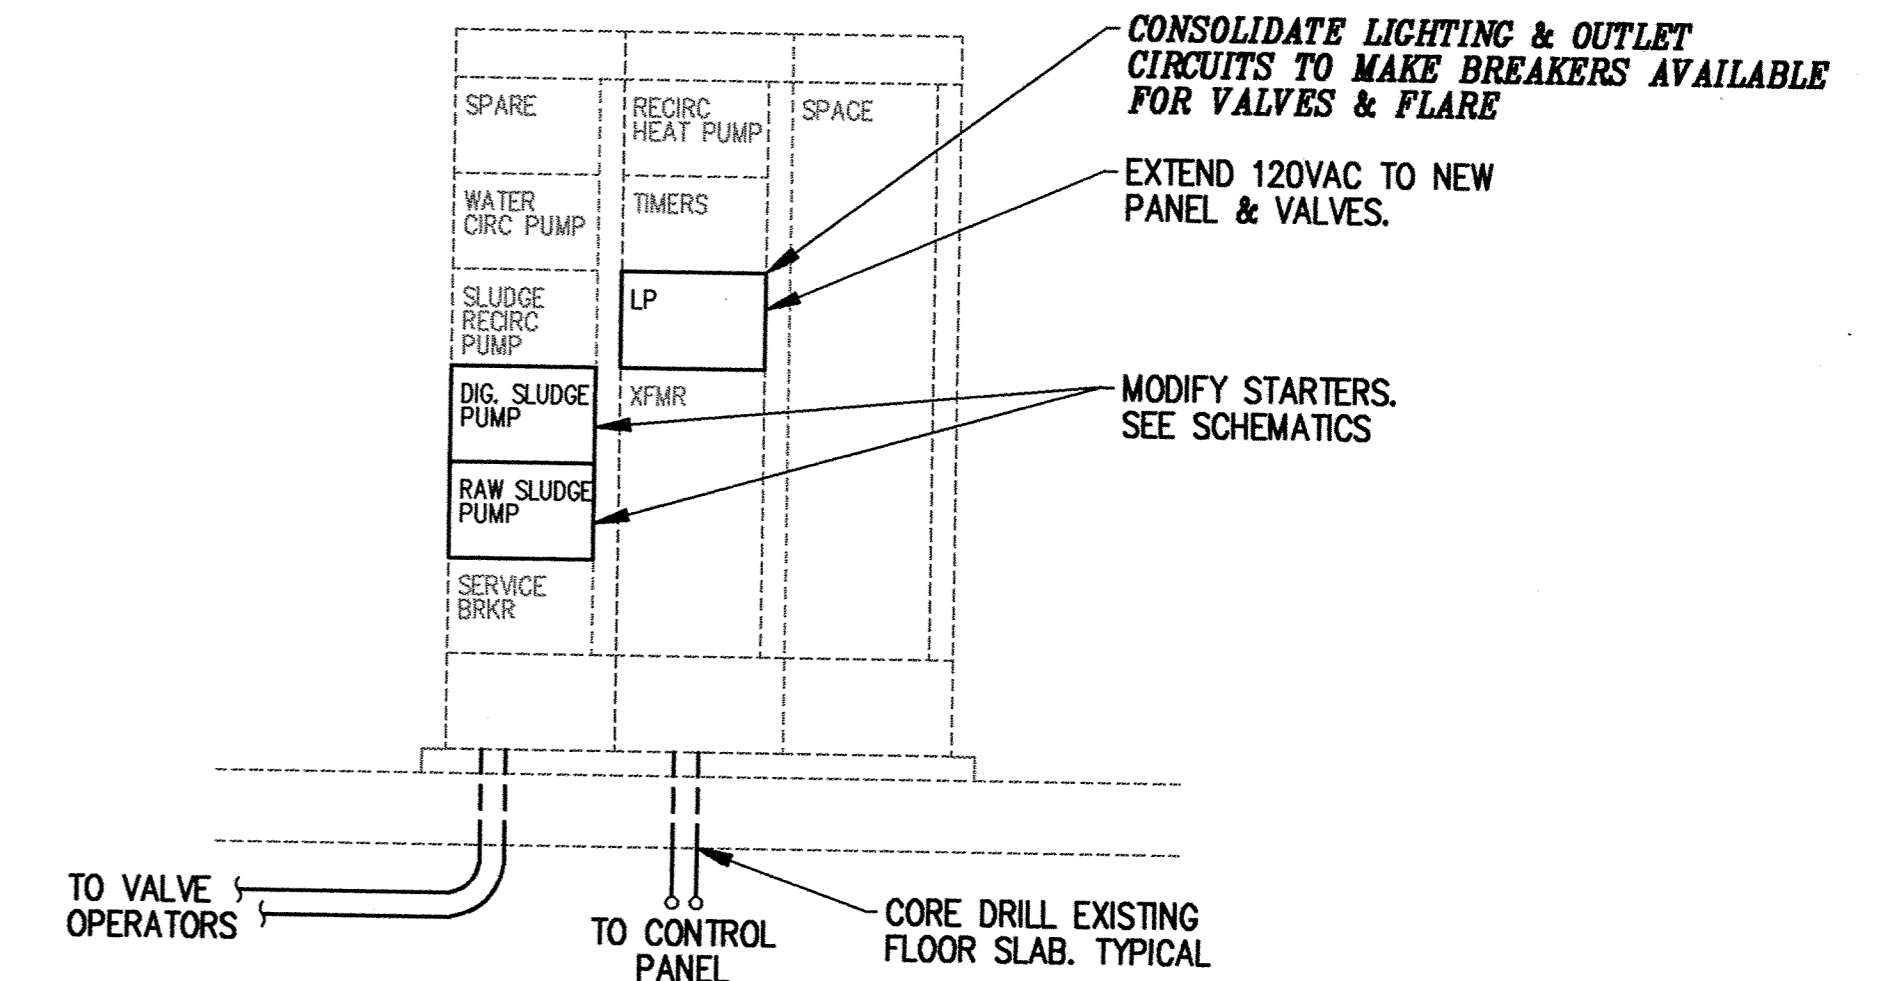

**EXISTING MOTOR CONTROL CENTER ELEVATION**  
SCALE: 1/2"=1'-0" LOCATED AT MAIN LEVEL

This drawing was prepared by:  
**Kaeding & Associates, Inc.**  
2300 France Avenue South  
Suite 330  
Minneapolis, MN 55435  
Telephone: (612) 831-0317  
Fax: (612) 831-2179

I HEREBY CERTIFY THAT THIS PLAN, SPECIFICATION, OR REPORT WAS PREPARED BY ME OR UNDER MY DIRECT SUPERVISION AND THAT I AM A DULY REGISTERED PROFESSIONAL ENGINEER UNDER THE LAWS OF THE STATE OF MINNESOTA.  
*[Signature]*  
DATE 06 OCT 95 REG. NO. 9955



1326 ENERGY PARK DRIVE  
ST. PAUL, MINNESOTA 55108  
(612) 644-4389  
5075 WAYZATA BLVD. SUITE 225  
MINNEAPOLIS, MINNESOTA 55441  
(612) 546-0432

DATE	DESCRIPTION	DESIGNED PFK	CHECKED PFK

REVISIONS

**CITY OF ELK RIVER**  
WASTEWATER TREATMENT FACILITIES  
DIGESTER BUILDING CONTROLS

**E25**

DATE OCT 1995 SHEET 111 OF 112 SHEETS PROJECT NO. 230-151