



SECTION **A-24**
SCALE: 1/8"=1'-0"

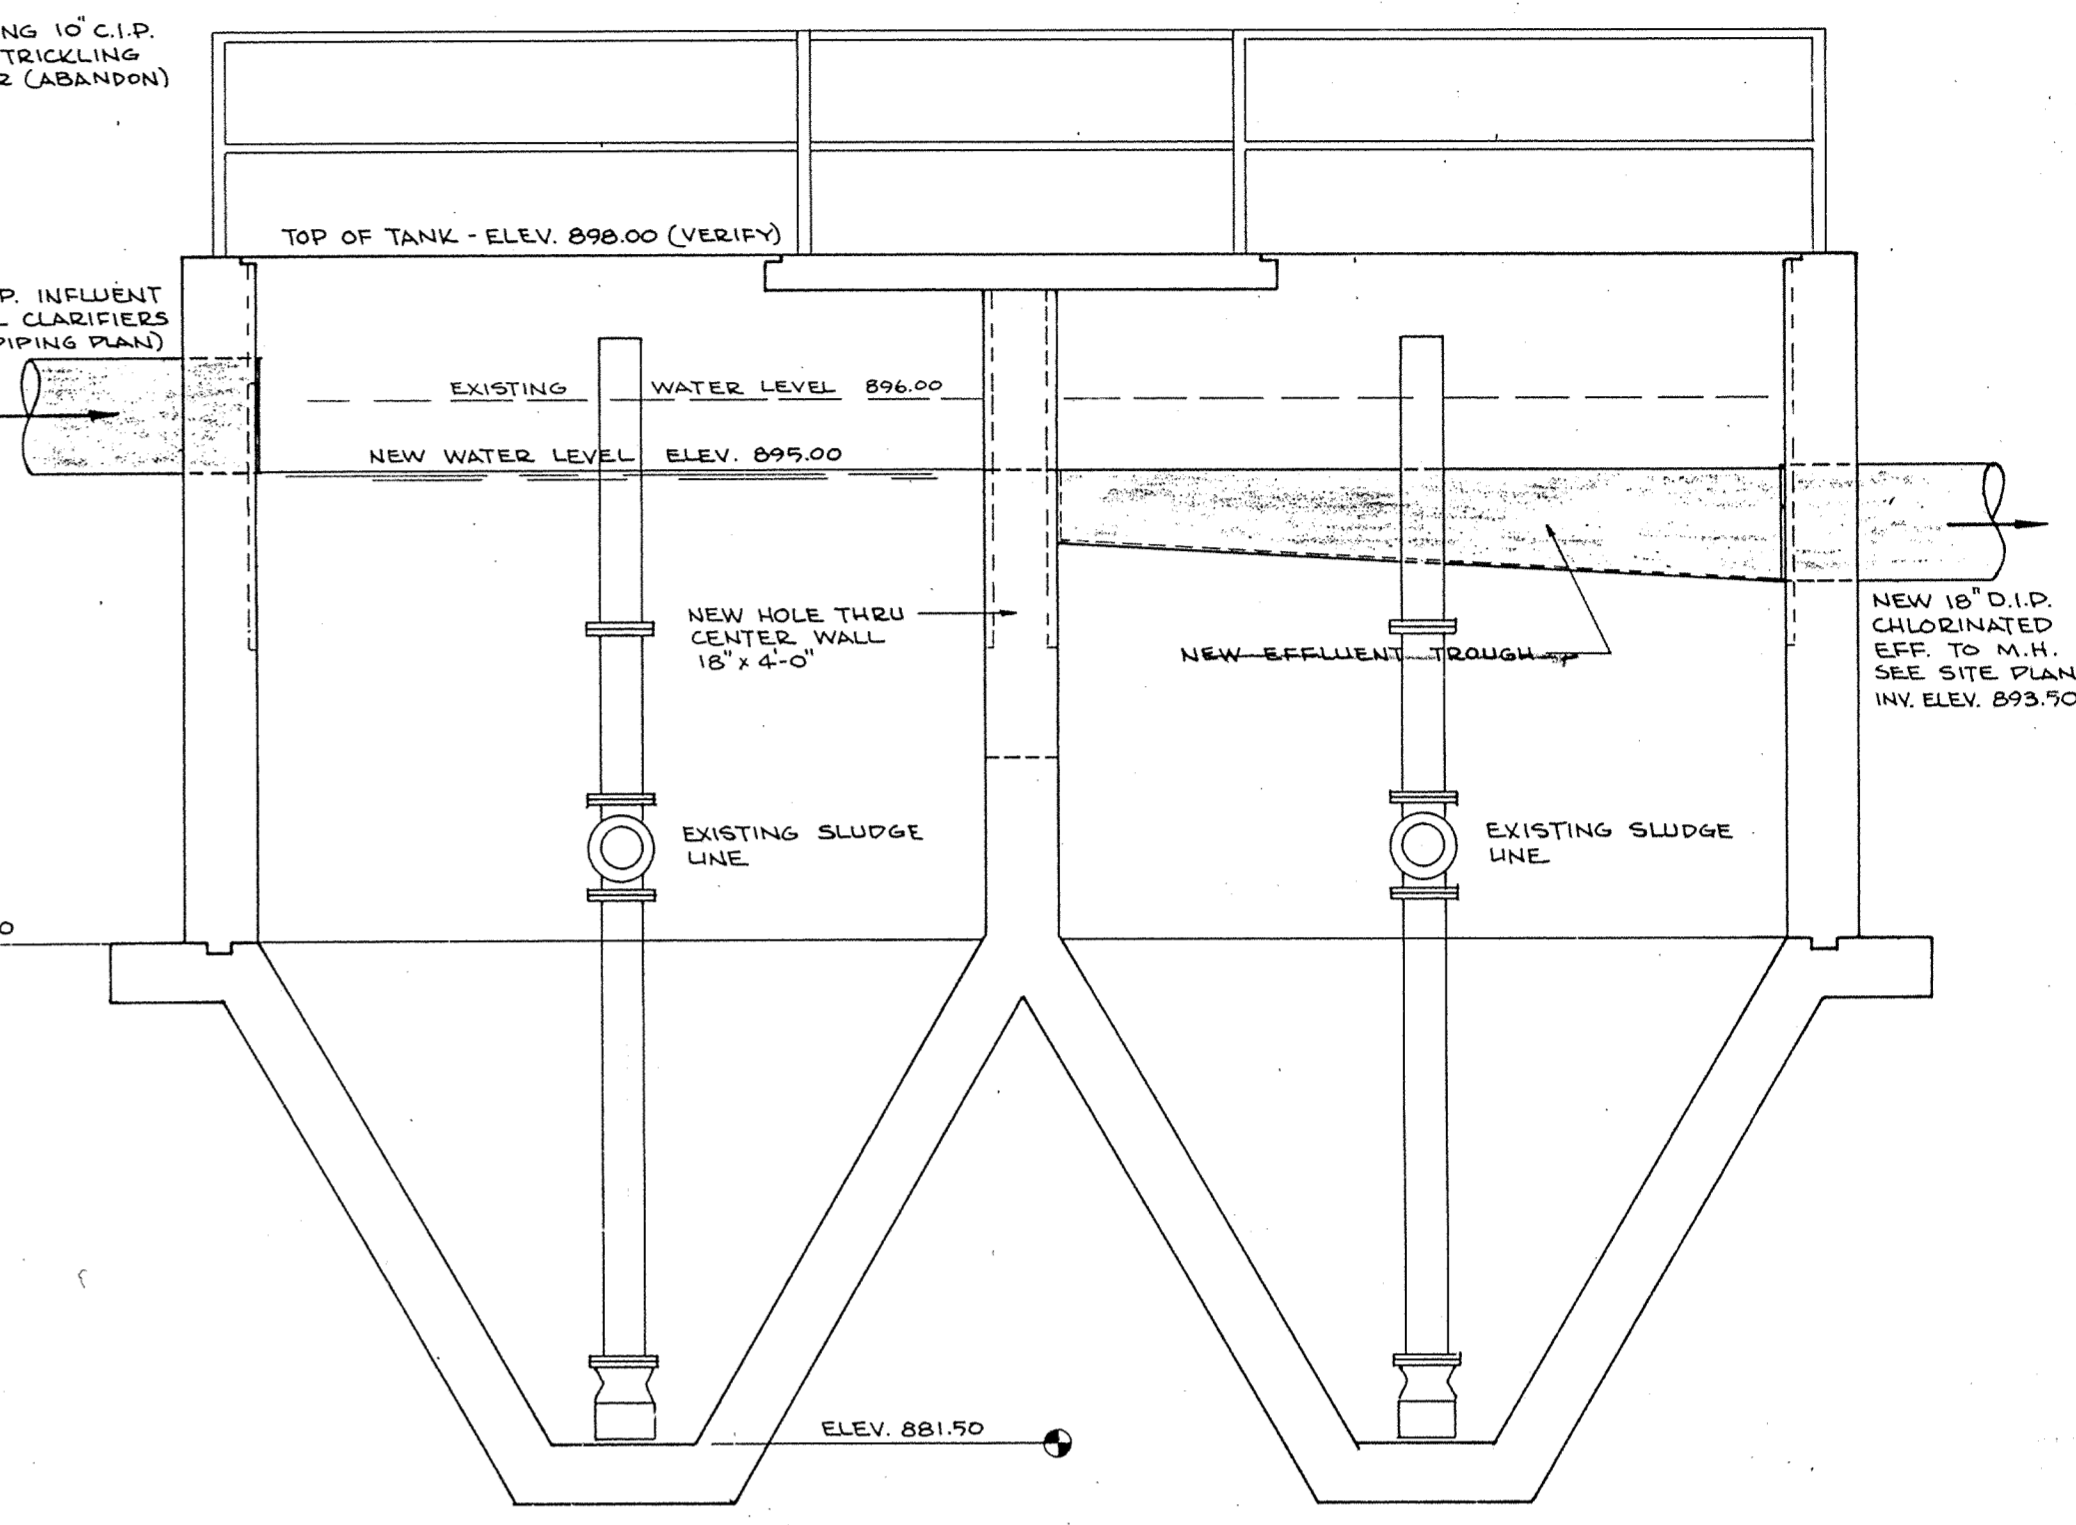

SECTION **B-24**
SCALE: 1/8"=1'-0"

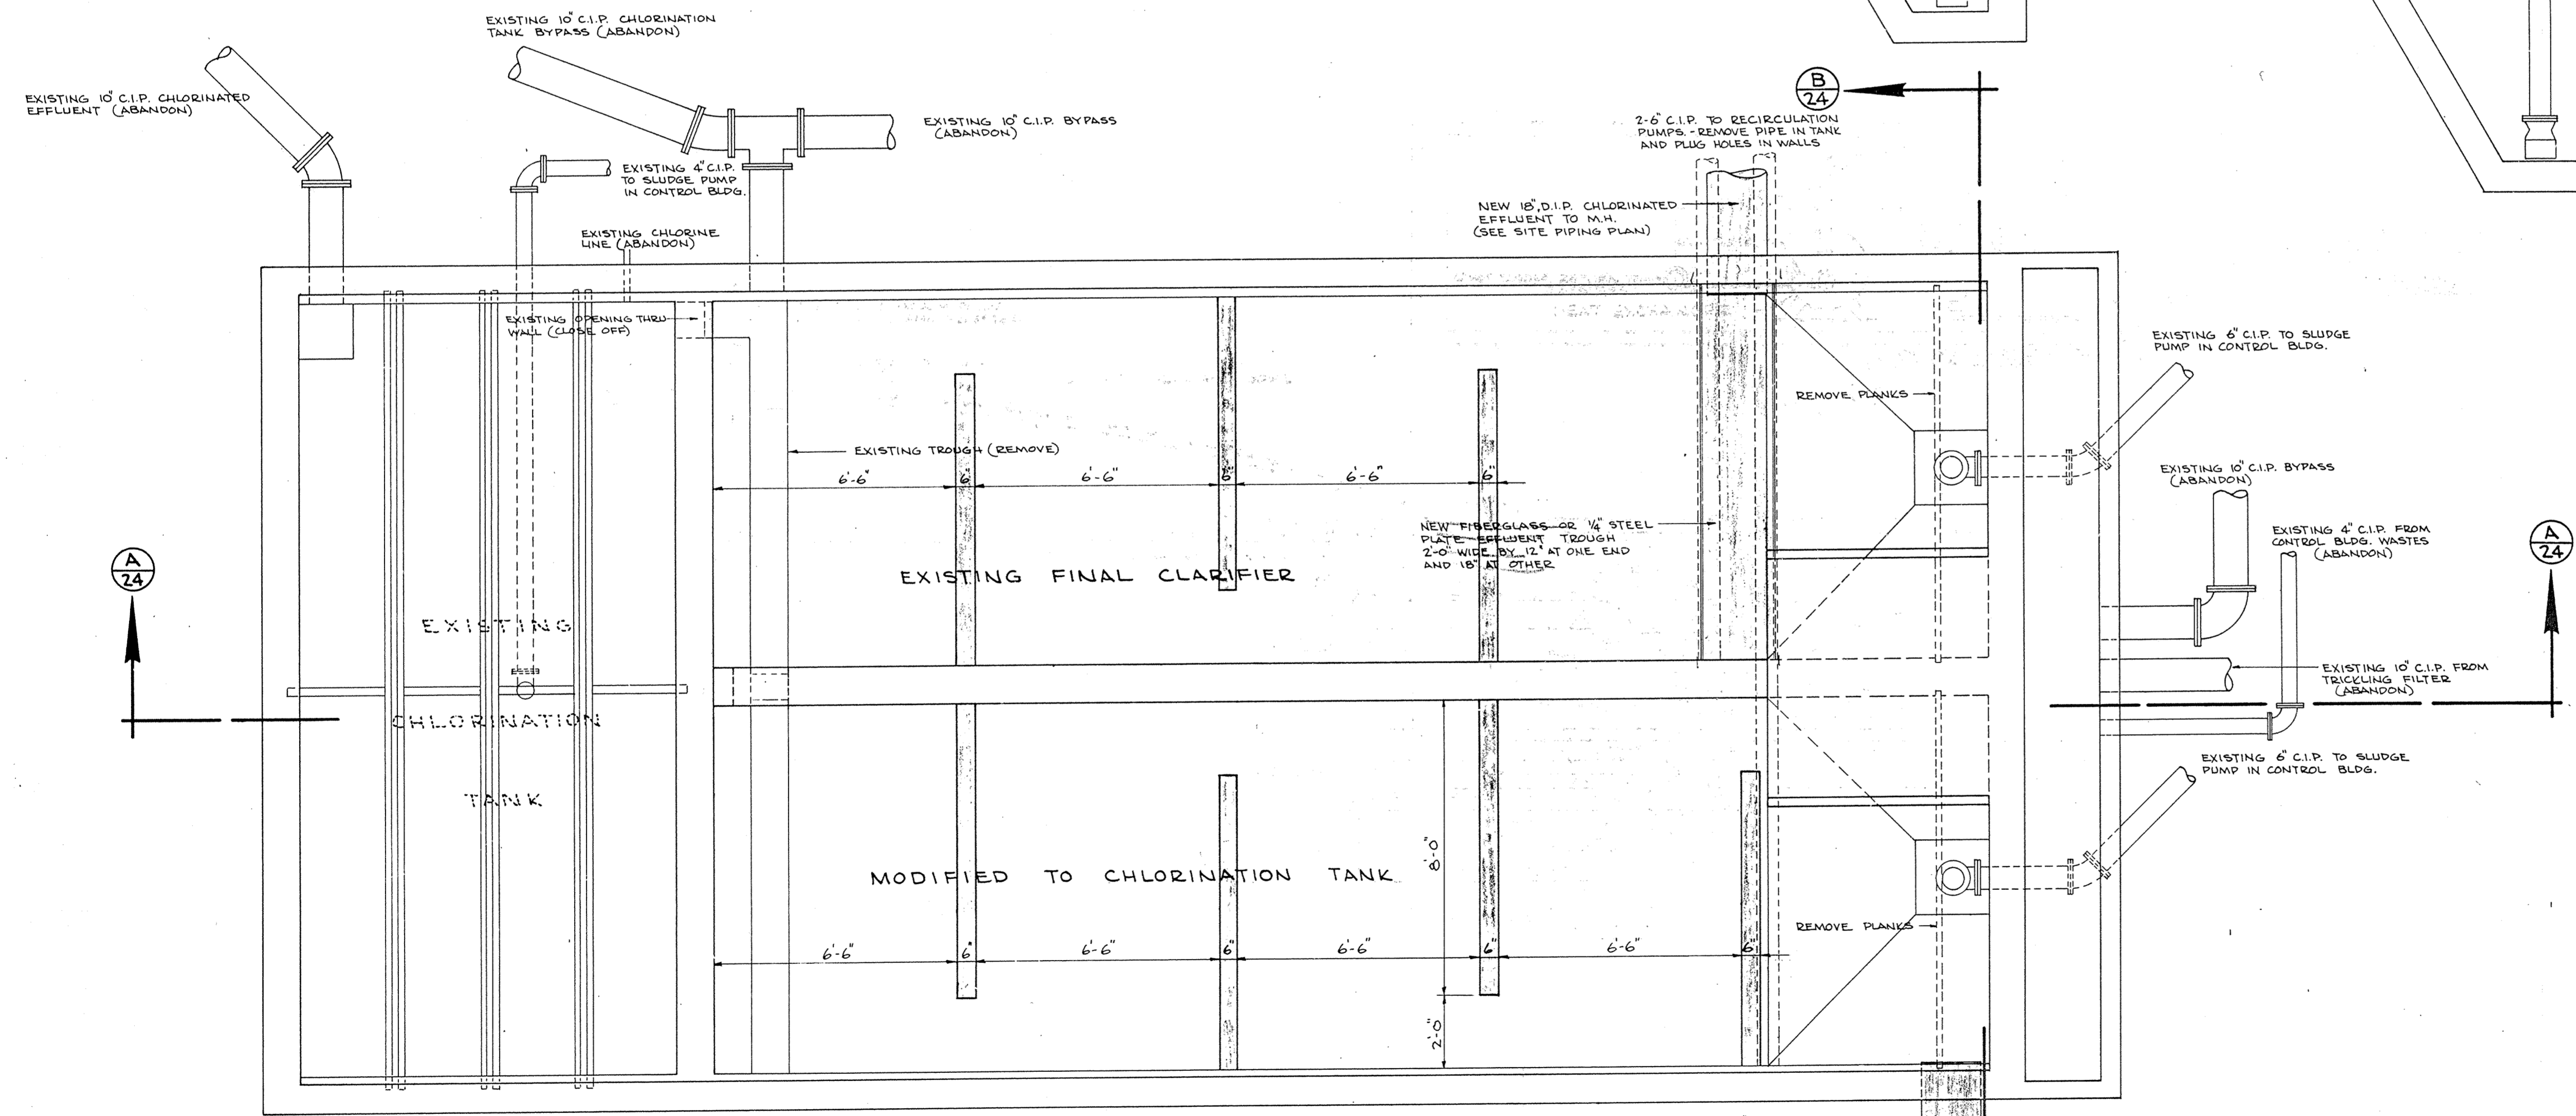

PLAN
SCALE: 1/8"=1'-0"

NOTE:
CHLORINE INJECTION POINT TO BE IN 18" CROSS UPSTREAM FROM CHLORINATION TANK. RUN NEW CHLORINE LINE FROM CONTROL BLDG.

NO.	DATE	BY	REMARKS
C	2-23-77	J.R.C.	MISC. NOTE REVISION.
B	9-16-76	J.R.C.	ADDED CONC. BAFFLE WALLS TO TANK
A	7-6-76	J.R.C.	ADDED CHLORINE SUPPLY LINE

DESIGNED K.L.V.	CHECKED K.L.V.
DRAWN J.R.C.	APPROVED W.H.M.
DATE 8/26/75	COMM.

I HEREBY CERTIFY THAT THIS PLAN WAS PREPARED BY ME OR UNDER MY DIRECT SUPERVISION AND THAT I AM A DULY REGISTERED PROFESSIONAL ENGINEER UNDER THE LAWS OF THE STATE OF MINNESOTA.
Karen VanLaack
DATE **Aug 29, 1975** REG. NO. **10159**

McCOMBS-KNUTSON ASSOCIATES, INC.
CONSULTING ENGINEERS & LAND SURVEYORS & SITE PLANNERS
MINNEAPOLIS, HUTCHINSON AND MARSHALL, MINNESOTA

WASTE WATER TREATMENT FACILITIES
FOR
ELK RIVER, MINNESOTA

SCALE AS NOTED	BOOK	PAGE
FILE NO.	2603	

MECHANICAL PLAN
CHLORINATION TANK

SHEET	REV.
24	C
OF	31