


STANDARD MANHOLE DETAIL

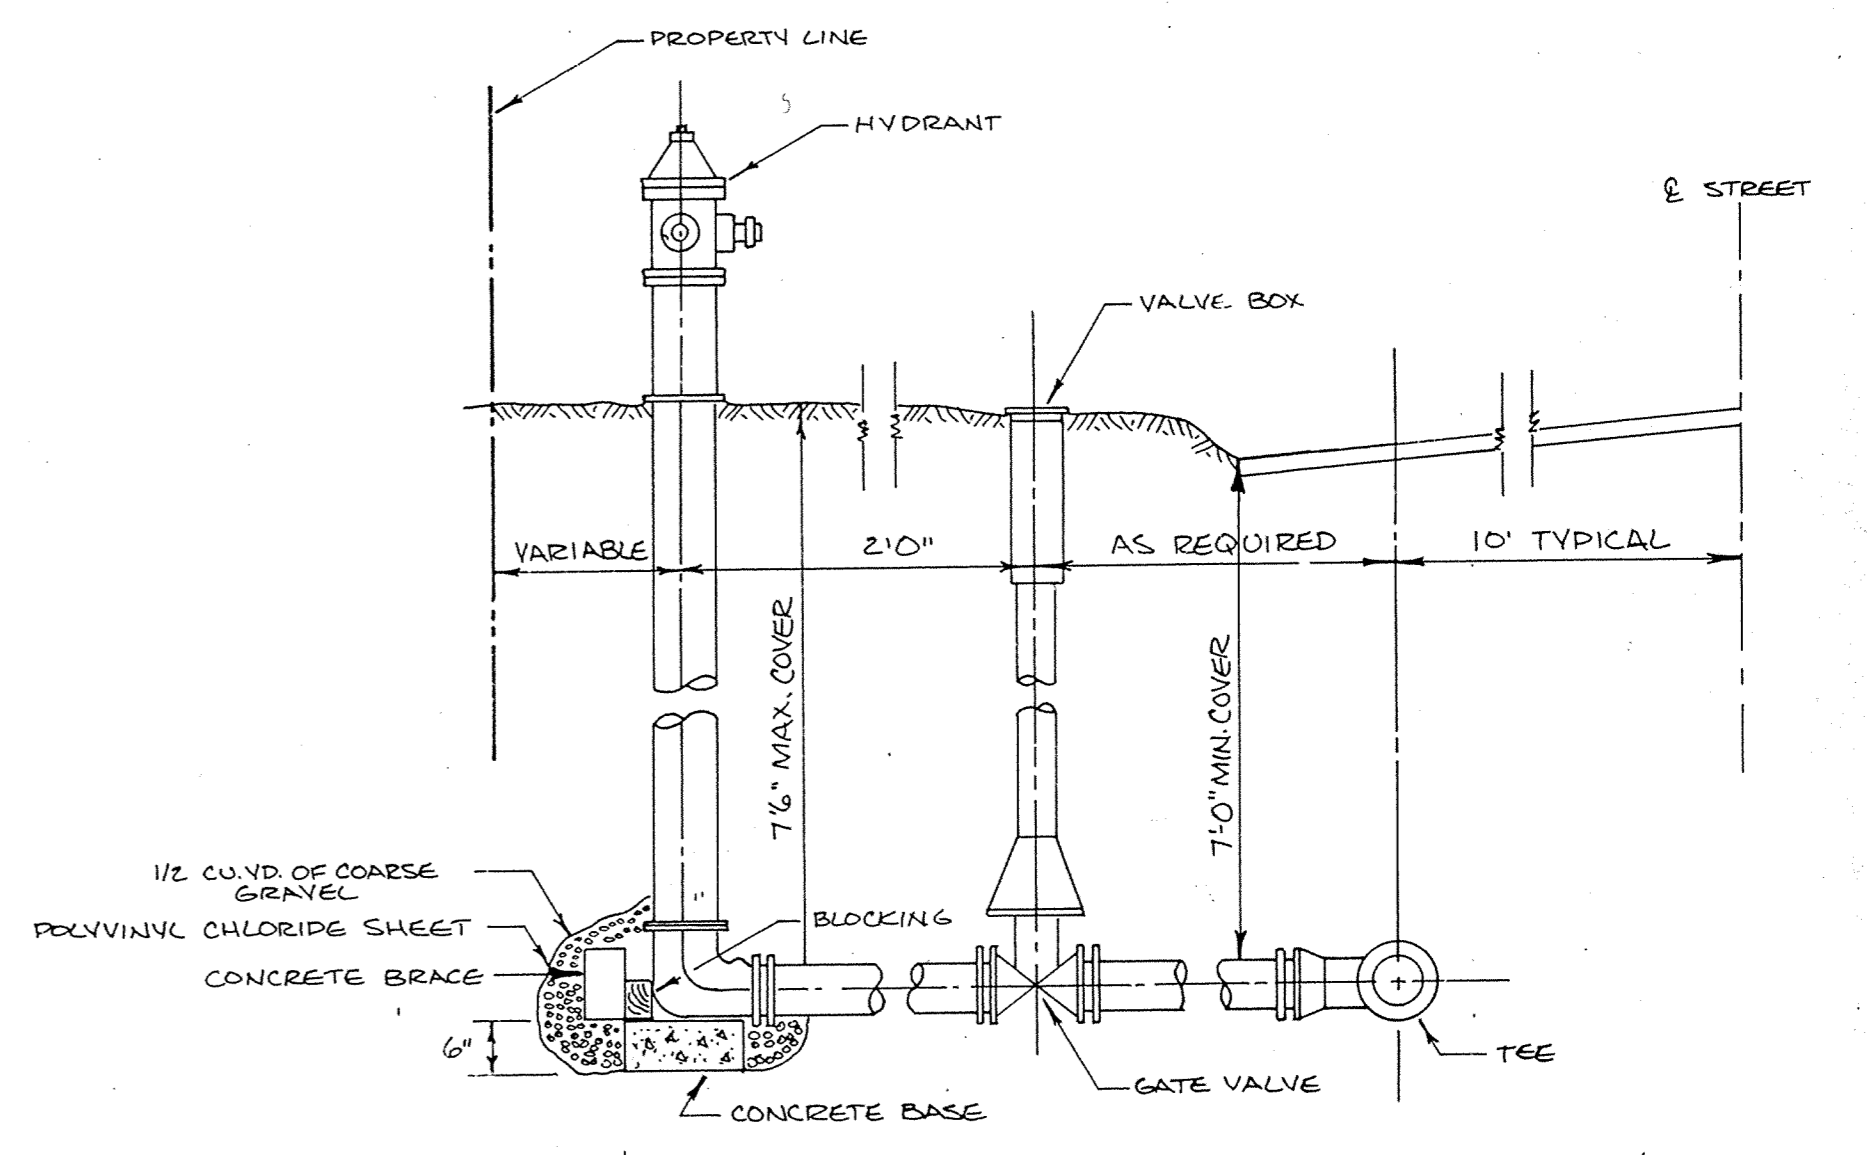

NO.	DATE	BY	REMARKS

DESIGNED K.L.V.	CHECKED K.L.V.
DRAWN P.W.P.	APPROVED W.H.M.
DATE	COMM.

I HEREBY CERTIFY THAT THIS PLAN WAS PREPARED BY ME OR UNDER MY DIRECT SUPERVISION AND THAT I AM A DULY REGISTERED PROFESSIONAL ENGINEER UNDER THE LAWS OF THE STATE OF MINNESOTA.

Karen L. VanRackem
DATE Aug 29, 1975 REG. NO. 10159

McCOMBS-KNUTSON ASSOCIATES, INC.
CONSULTING ENGINEERS ■ LAND SURVEYORS ■ SITE PLANNERS
MINNEAPOLIS, HUTCHINSON and MARSHALL, MINNESOTA

WASTE WATER TREATMENT FACILITIES
FOR
ELK RIVER, MINNESOTA

SCALE AS NOTED
BOOK PAGE
FILE NO. 2603

MISC. DETAILS

SHEET 27	REV.
OF 31	

SARGO PRODUCTS • NEW HARBOR, MINNESOTA
REGISTERED BY PART NUMBER 6528