



ELECTRICAL JUNCTION BOX PLAN
SCALE: 1/2" = 1'-0"

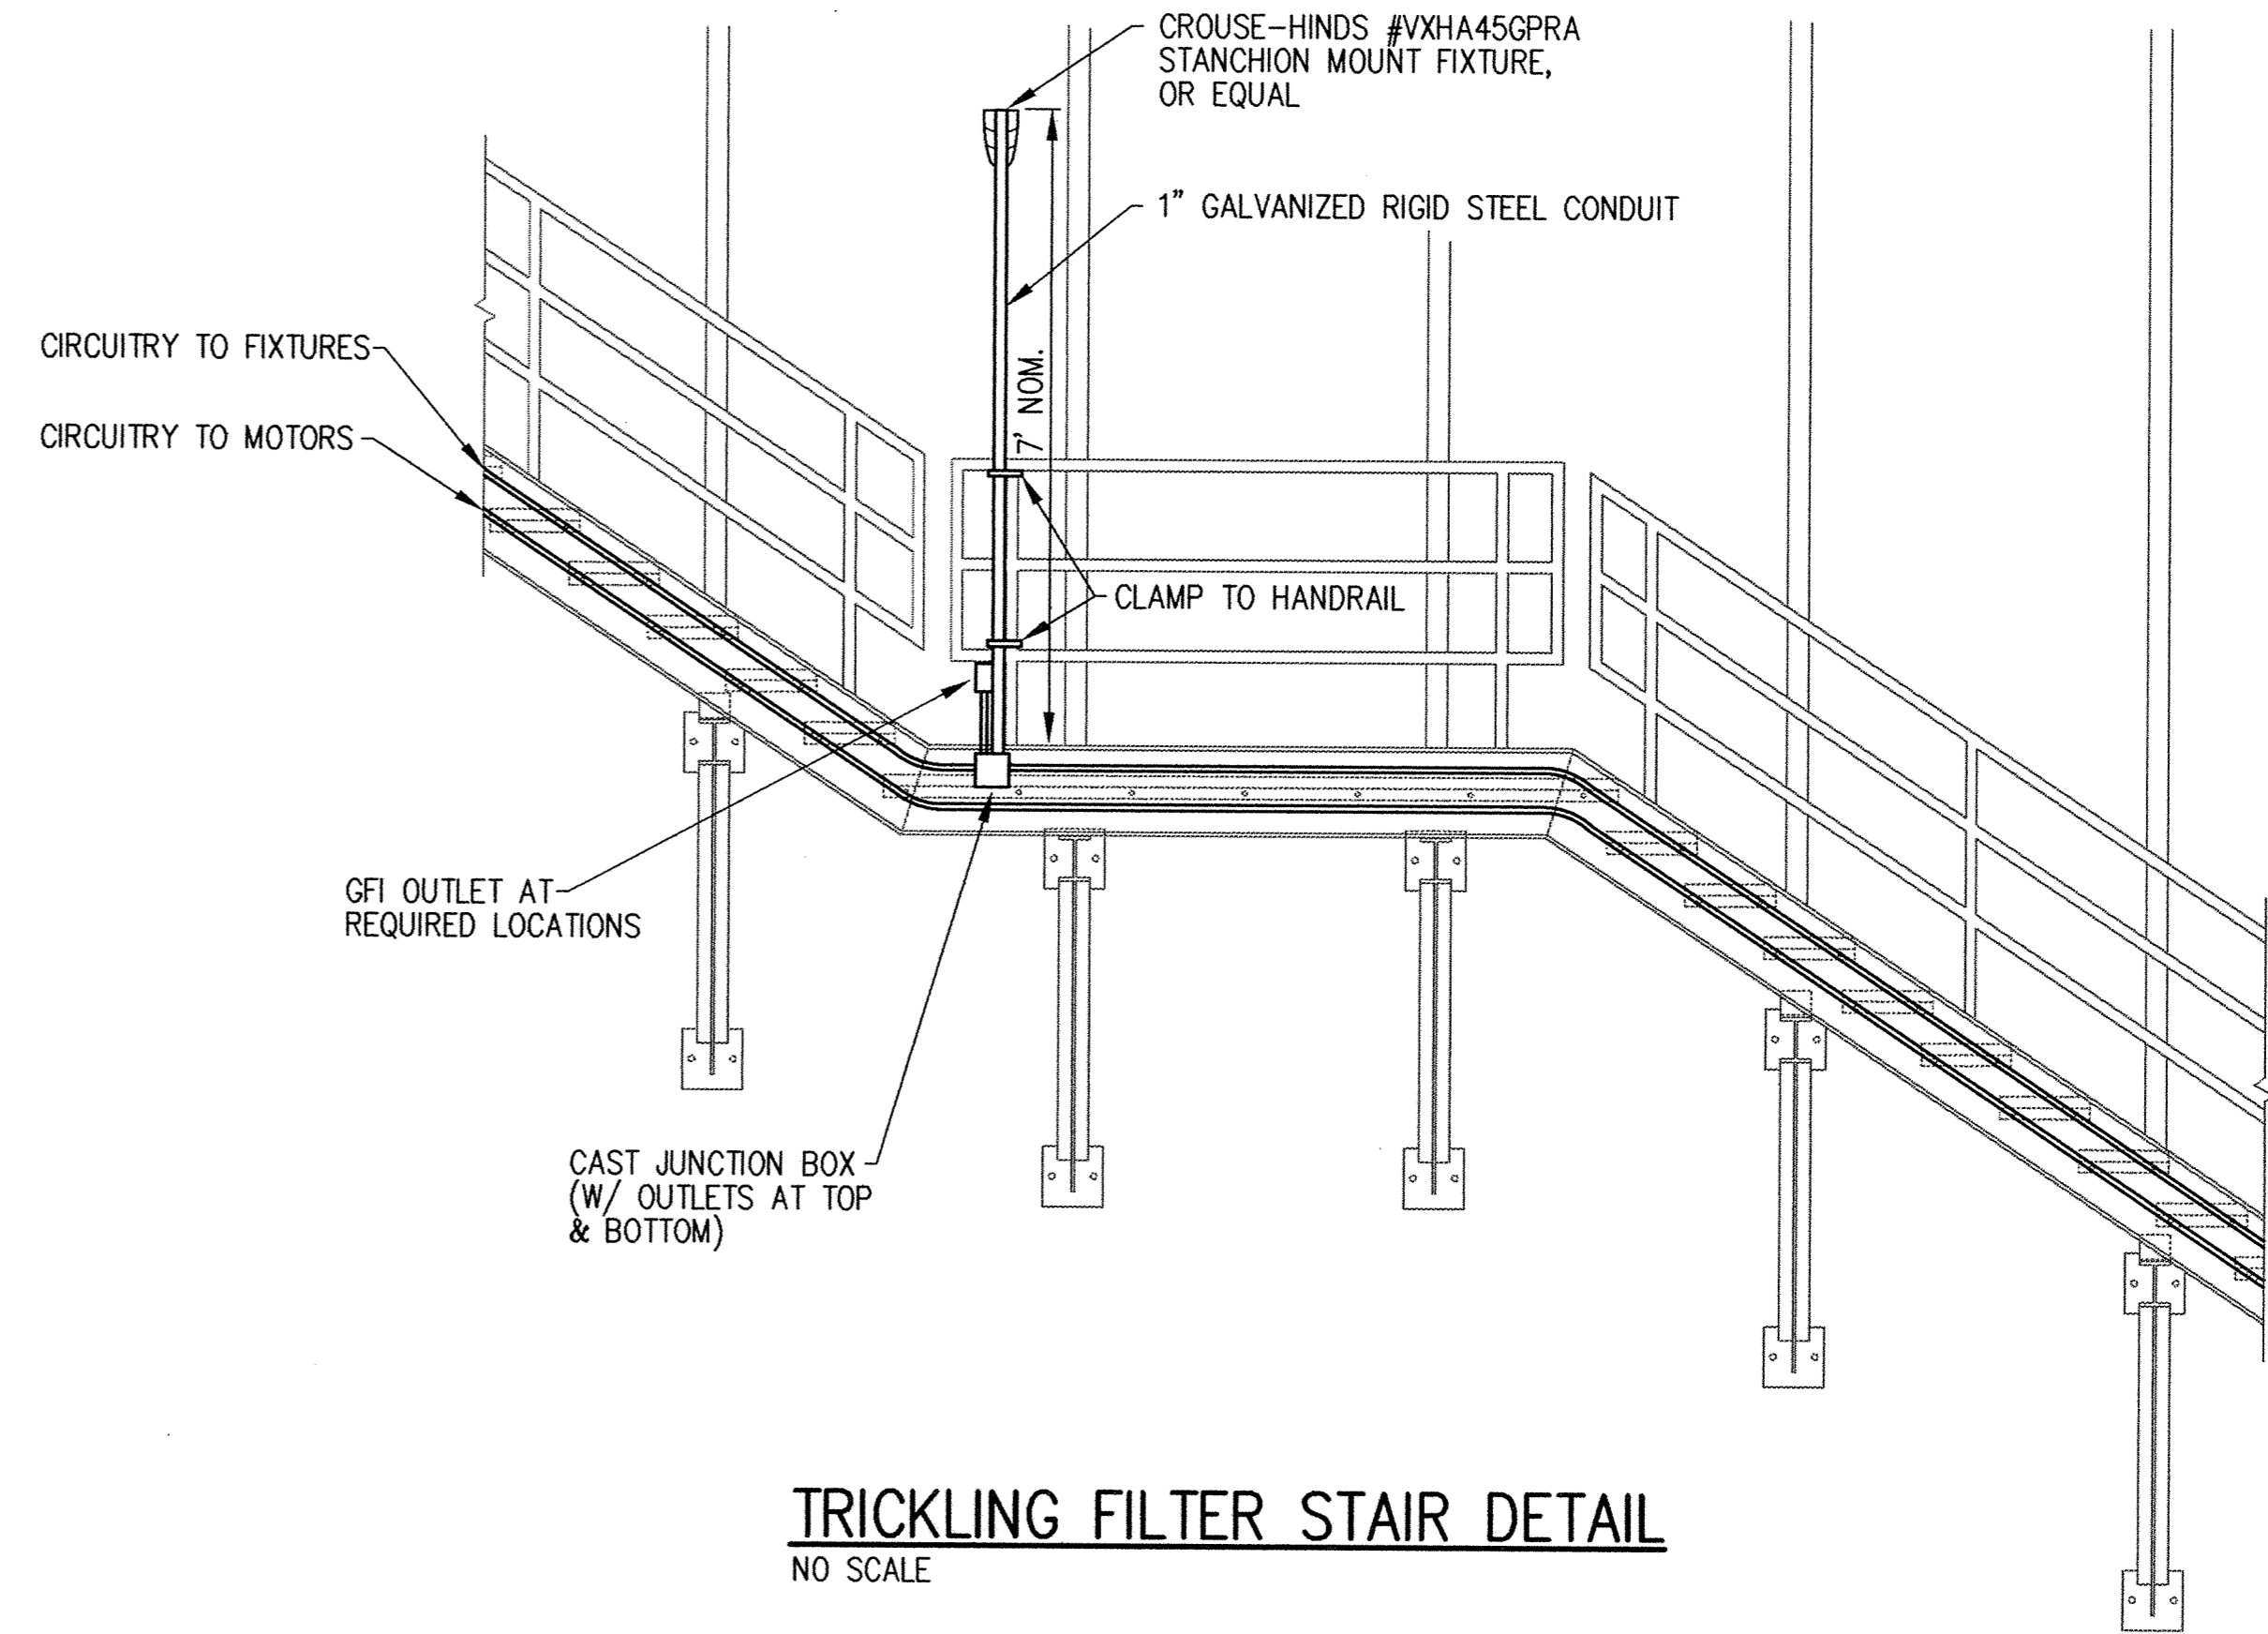

TRICKLING FILTER STAIR DETAIL
NO SCALE

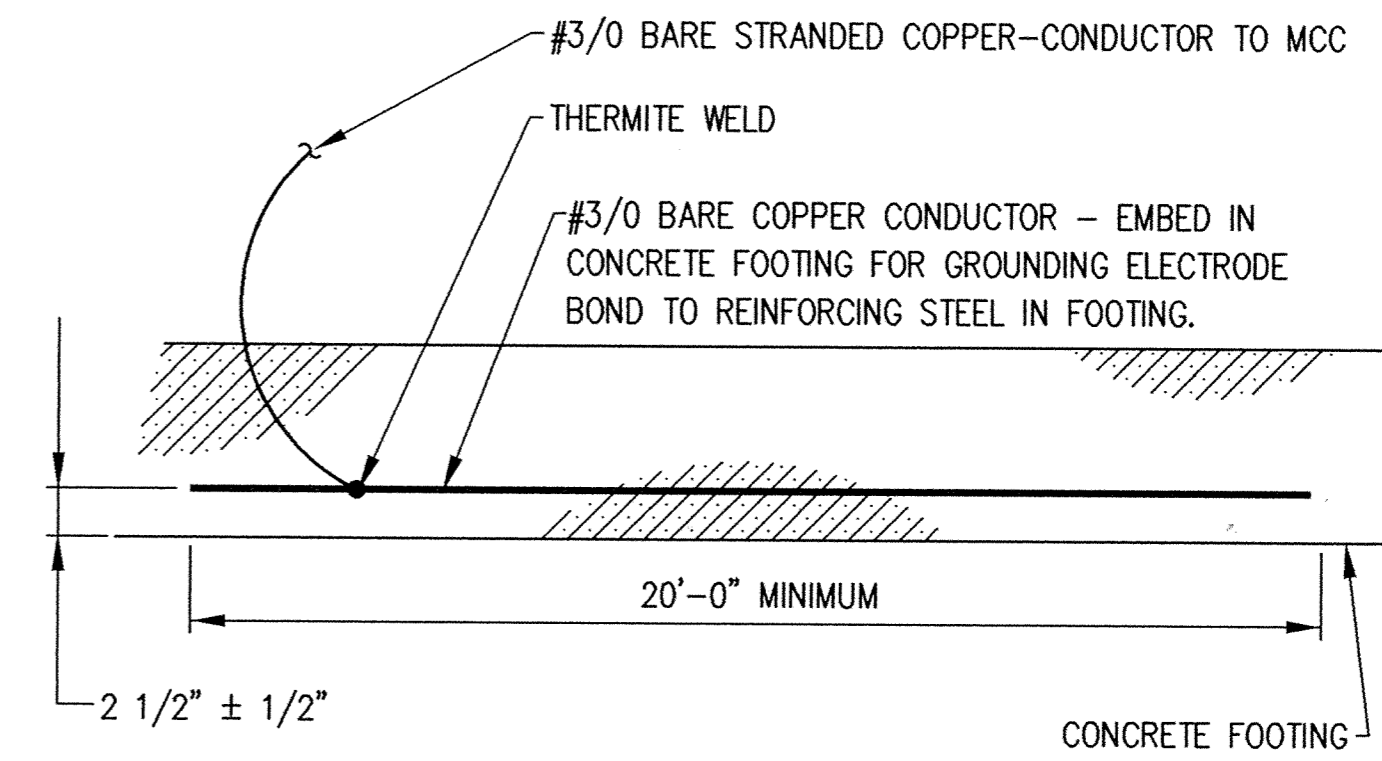

UFER GROUNDING ELECTRODE DETAIL
NO SCALE

This drawing was prepared by:
Kaeding & Associates, Inc.
7300 France Avenue South
Suite 330
Minneapolis, MN 55435
Telephone: (612) 831-0317
Fax: (612) 831-2179

I HEREBY CERTIFY THAT THIS PLAN, SPECIFICATION, OR REPORT WAS PREPARED BY ME OR UNDER MY DIRECT SUPERVISION AND THAT I AM A DULY REGISTERED PROFESSIONAL ENGINEER UNDER THE LAWS OF THE STATE OF MINNESOTA.
[Signature]
DATE: 10/1, 1994 REG. NO. 9955



1326 ENERGY PARK DRIVE
ST. PAUL, MINNESOTA 55108
(612) 644-4389

9800 SHELARD PARKWAY
MINNEAPOLIS, MINNESOTA 55441
(612) 546-0432

REVISIONS	DATE	DESCRIPTION	DESIGNED PFK	CHECKED PFK

DRAWN DTB
GRAPHIC SCALE
0 HORIZ.
0 VERT.

CITY OF ELK RIVER
WASTEWATER TREATMENT FACILITIES
ELECTRICAL DETAILS

E14