
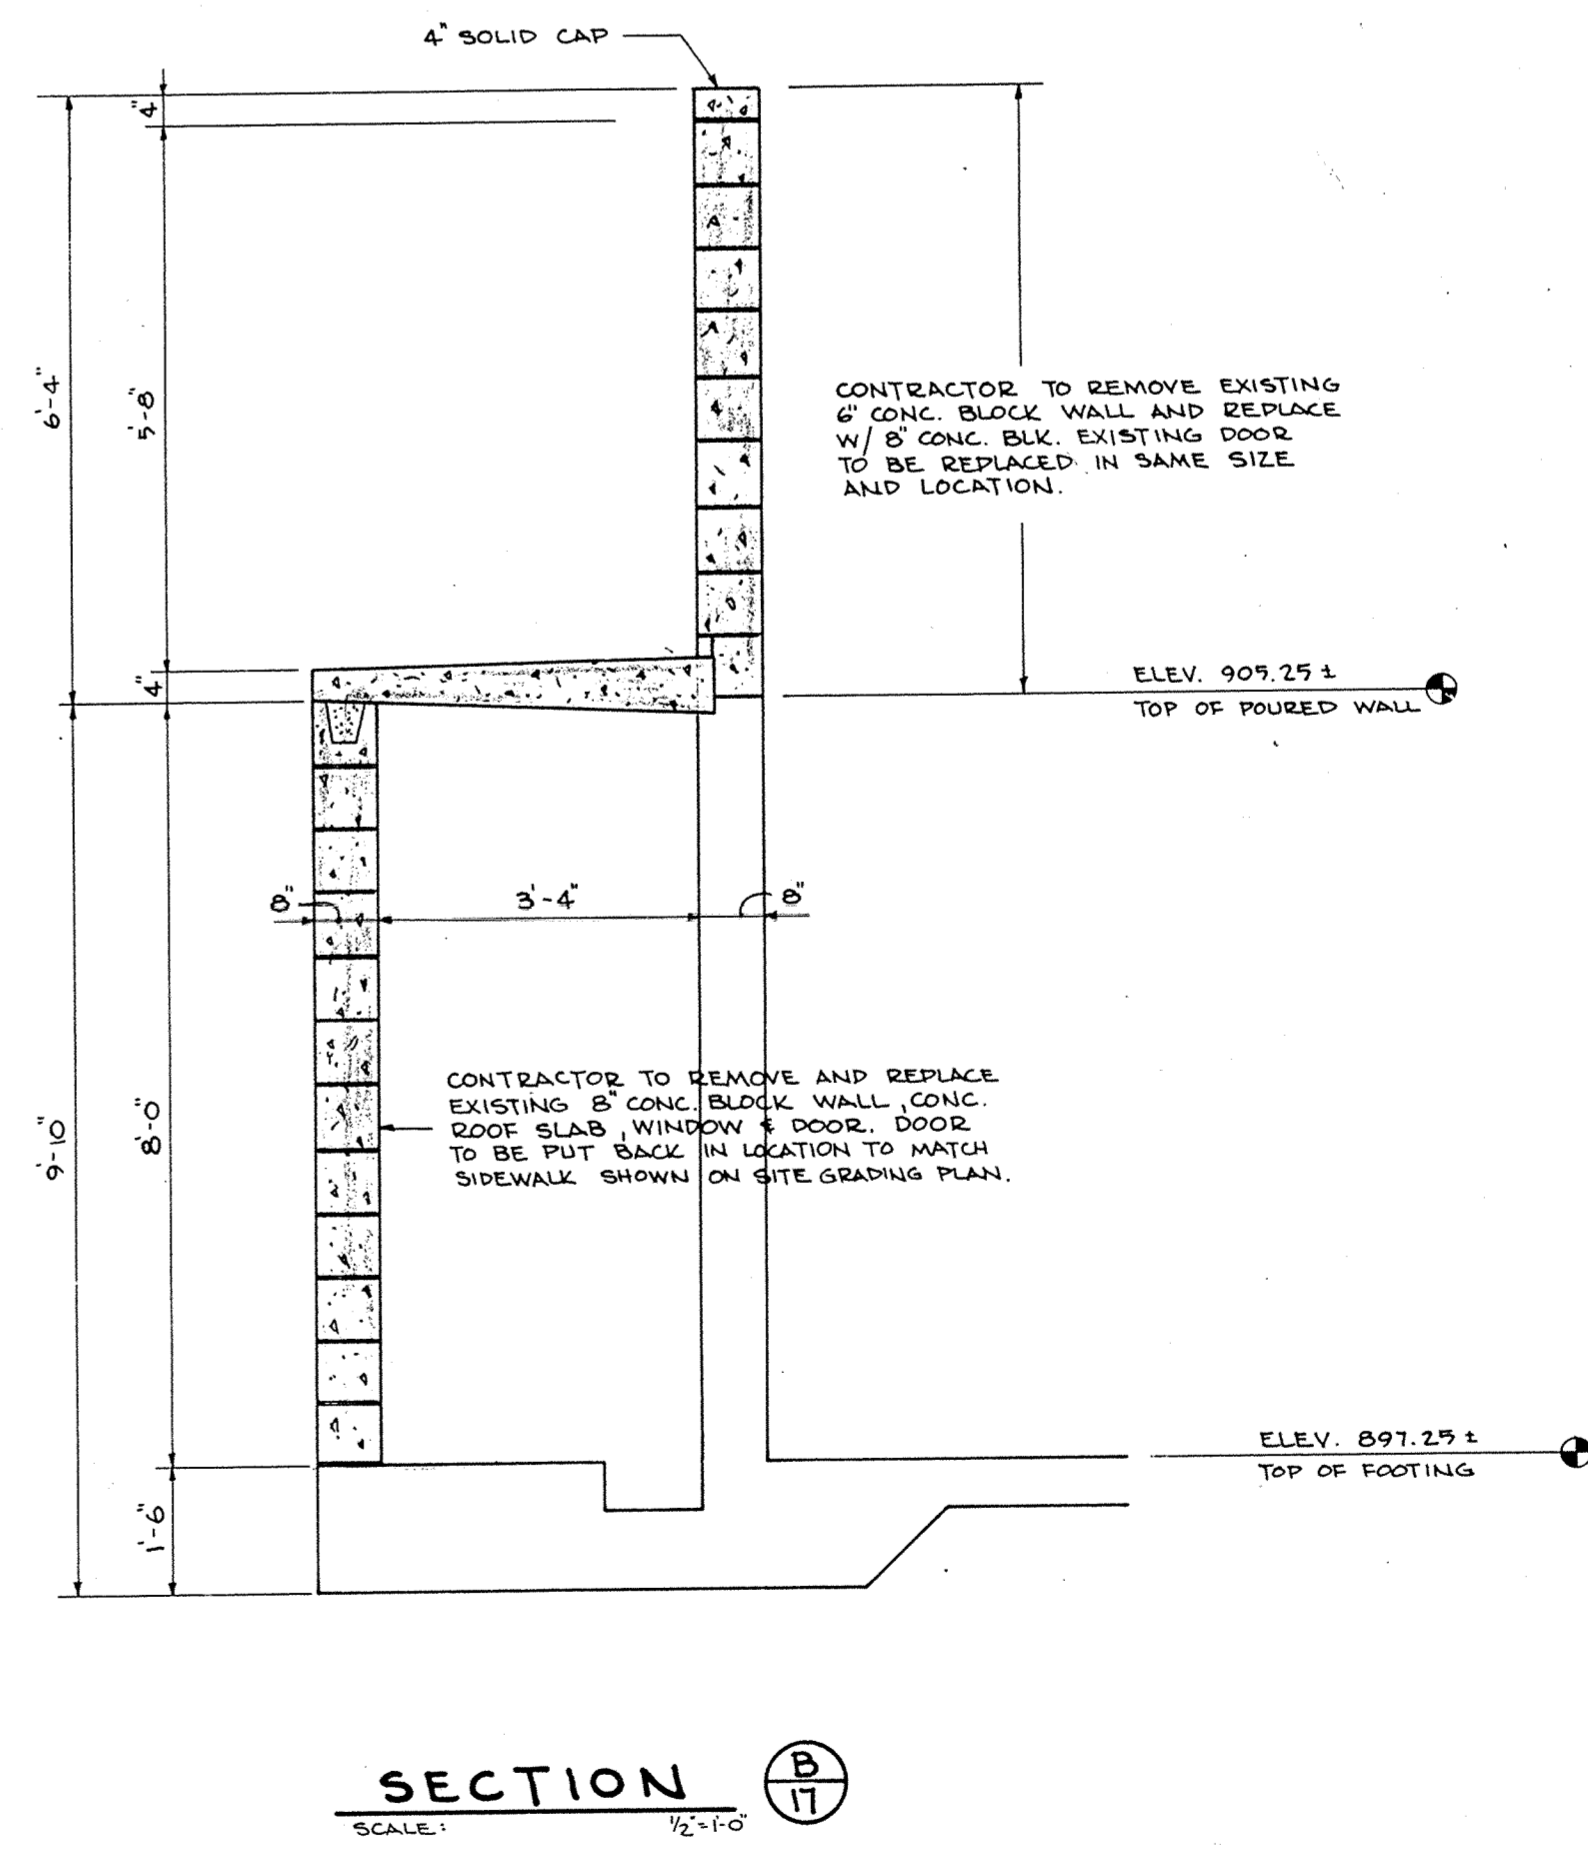
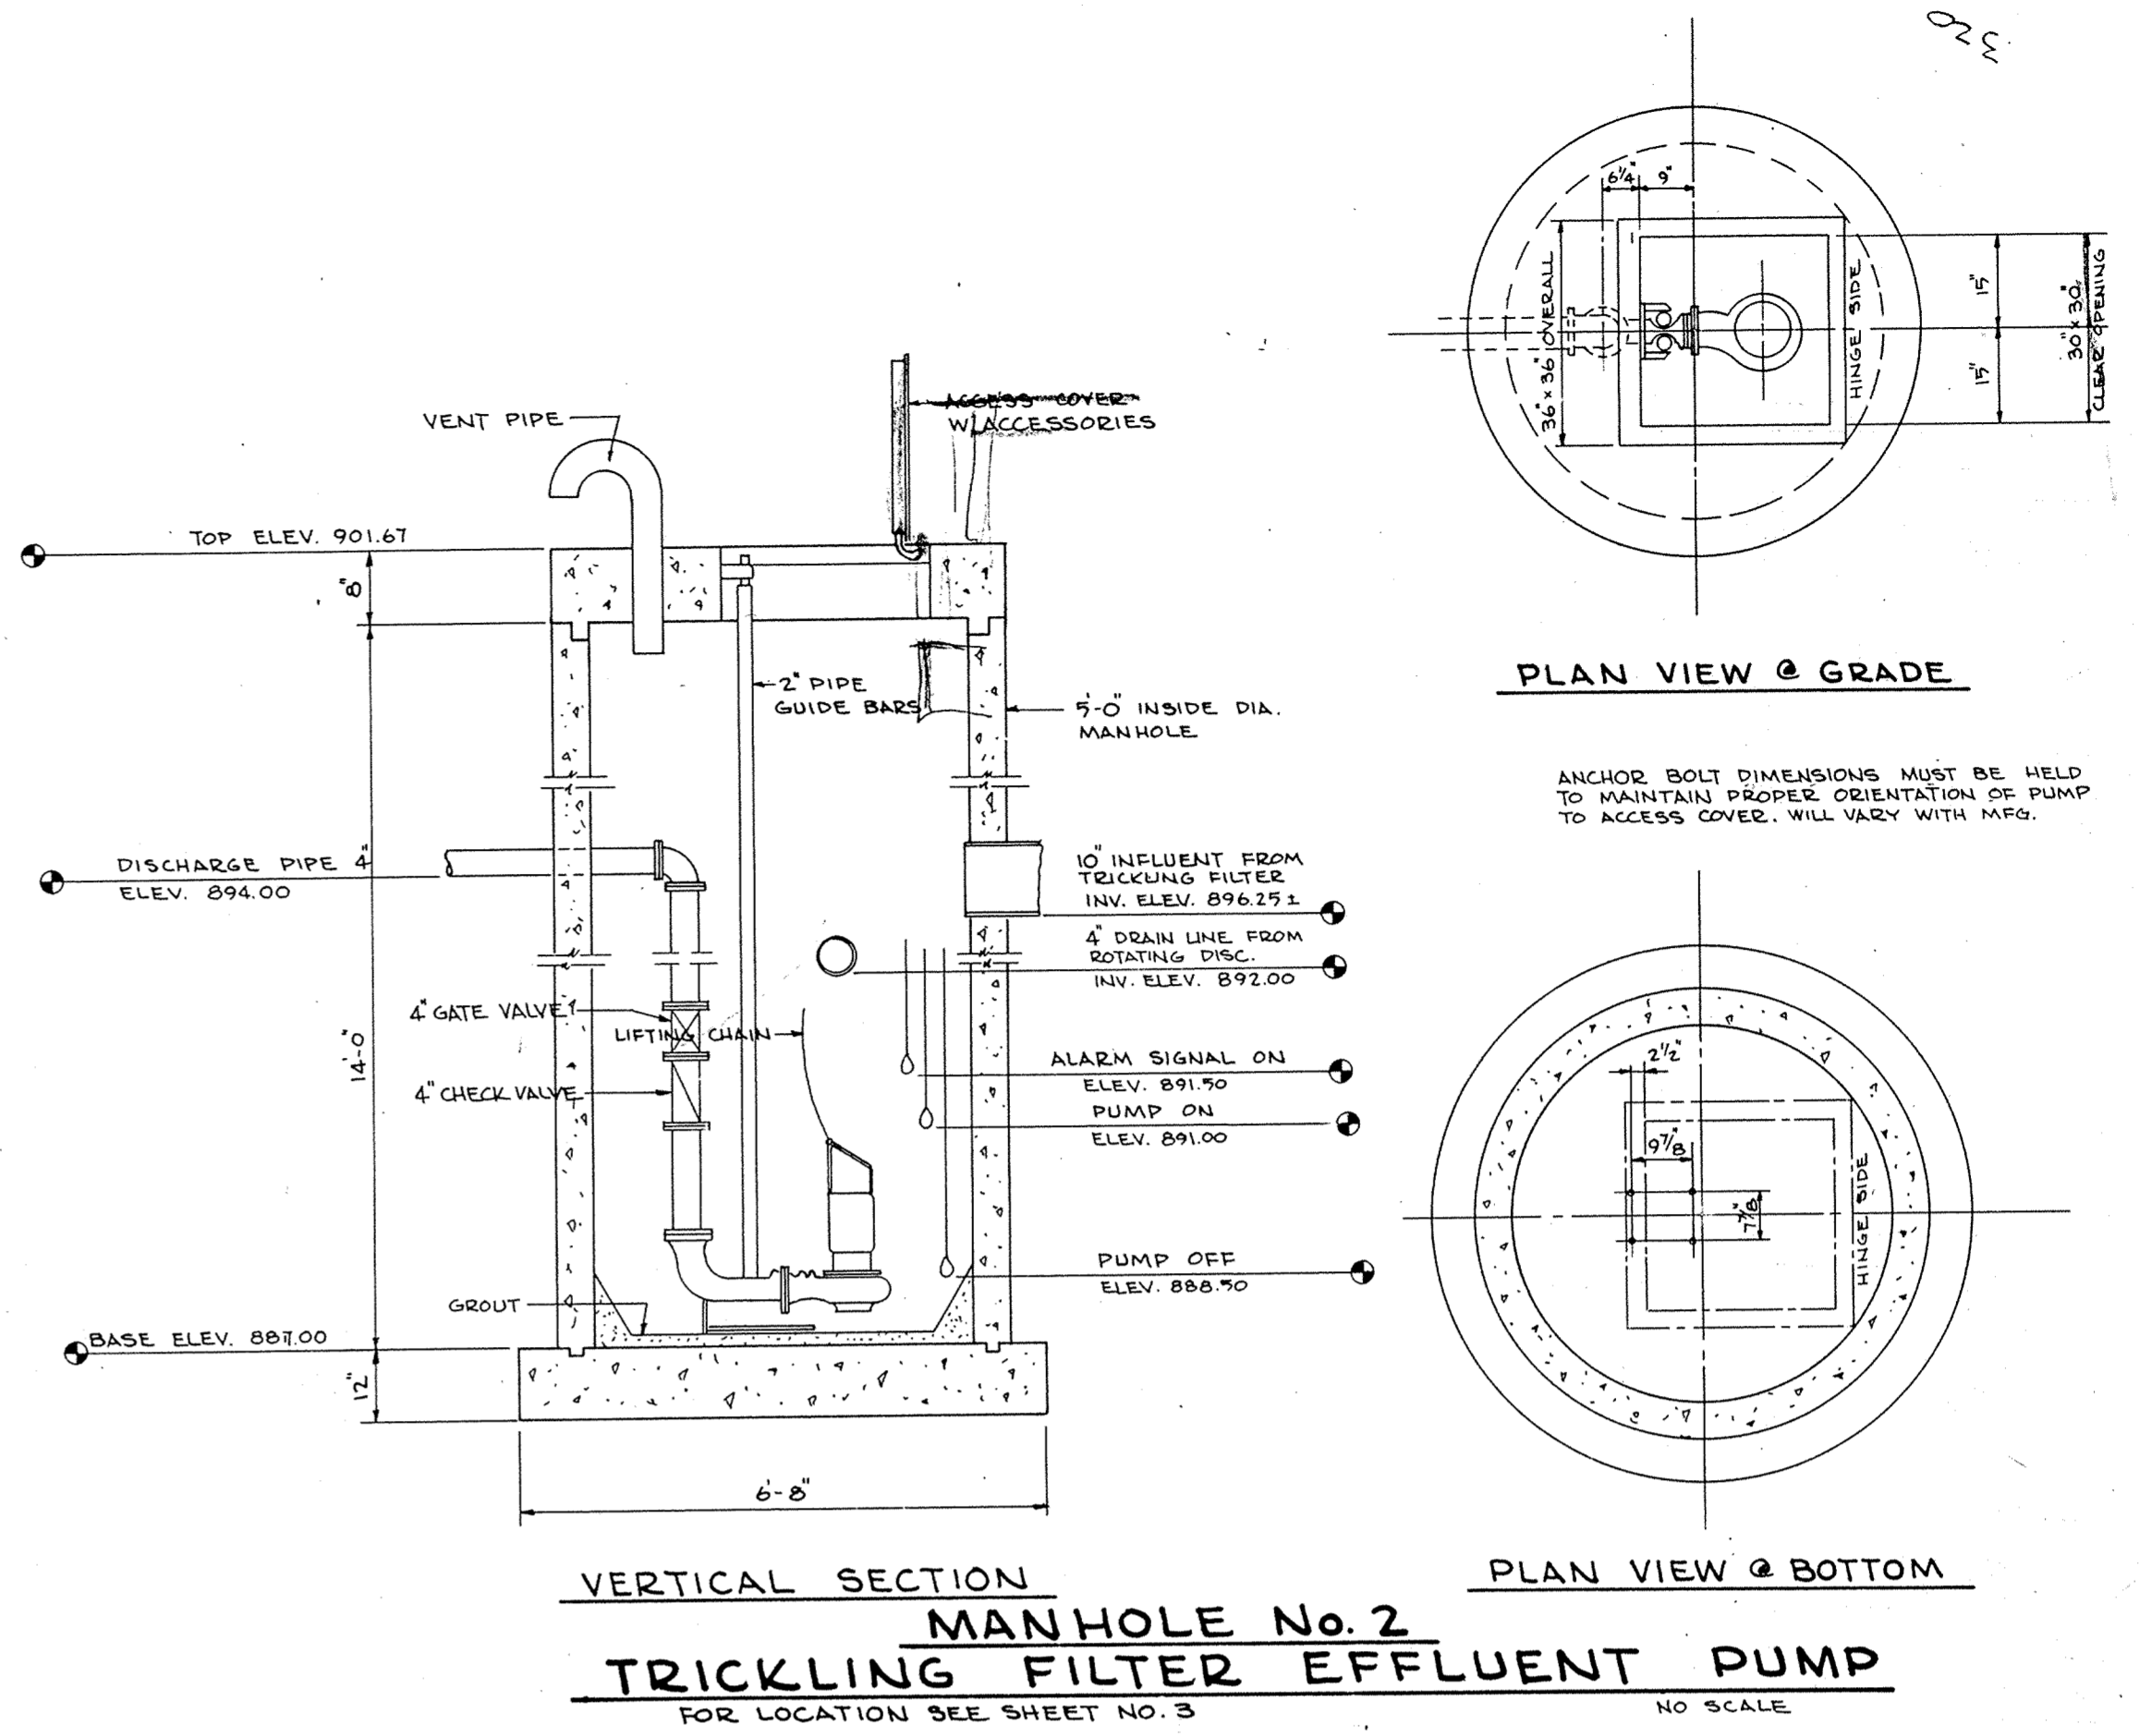
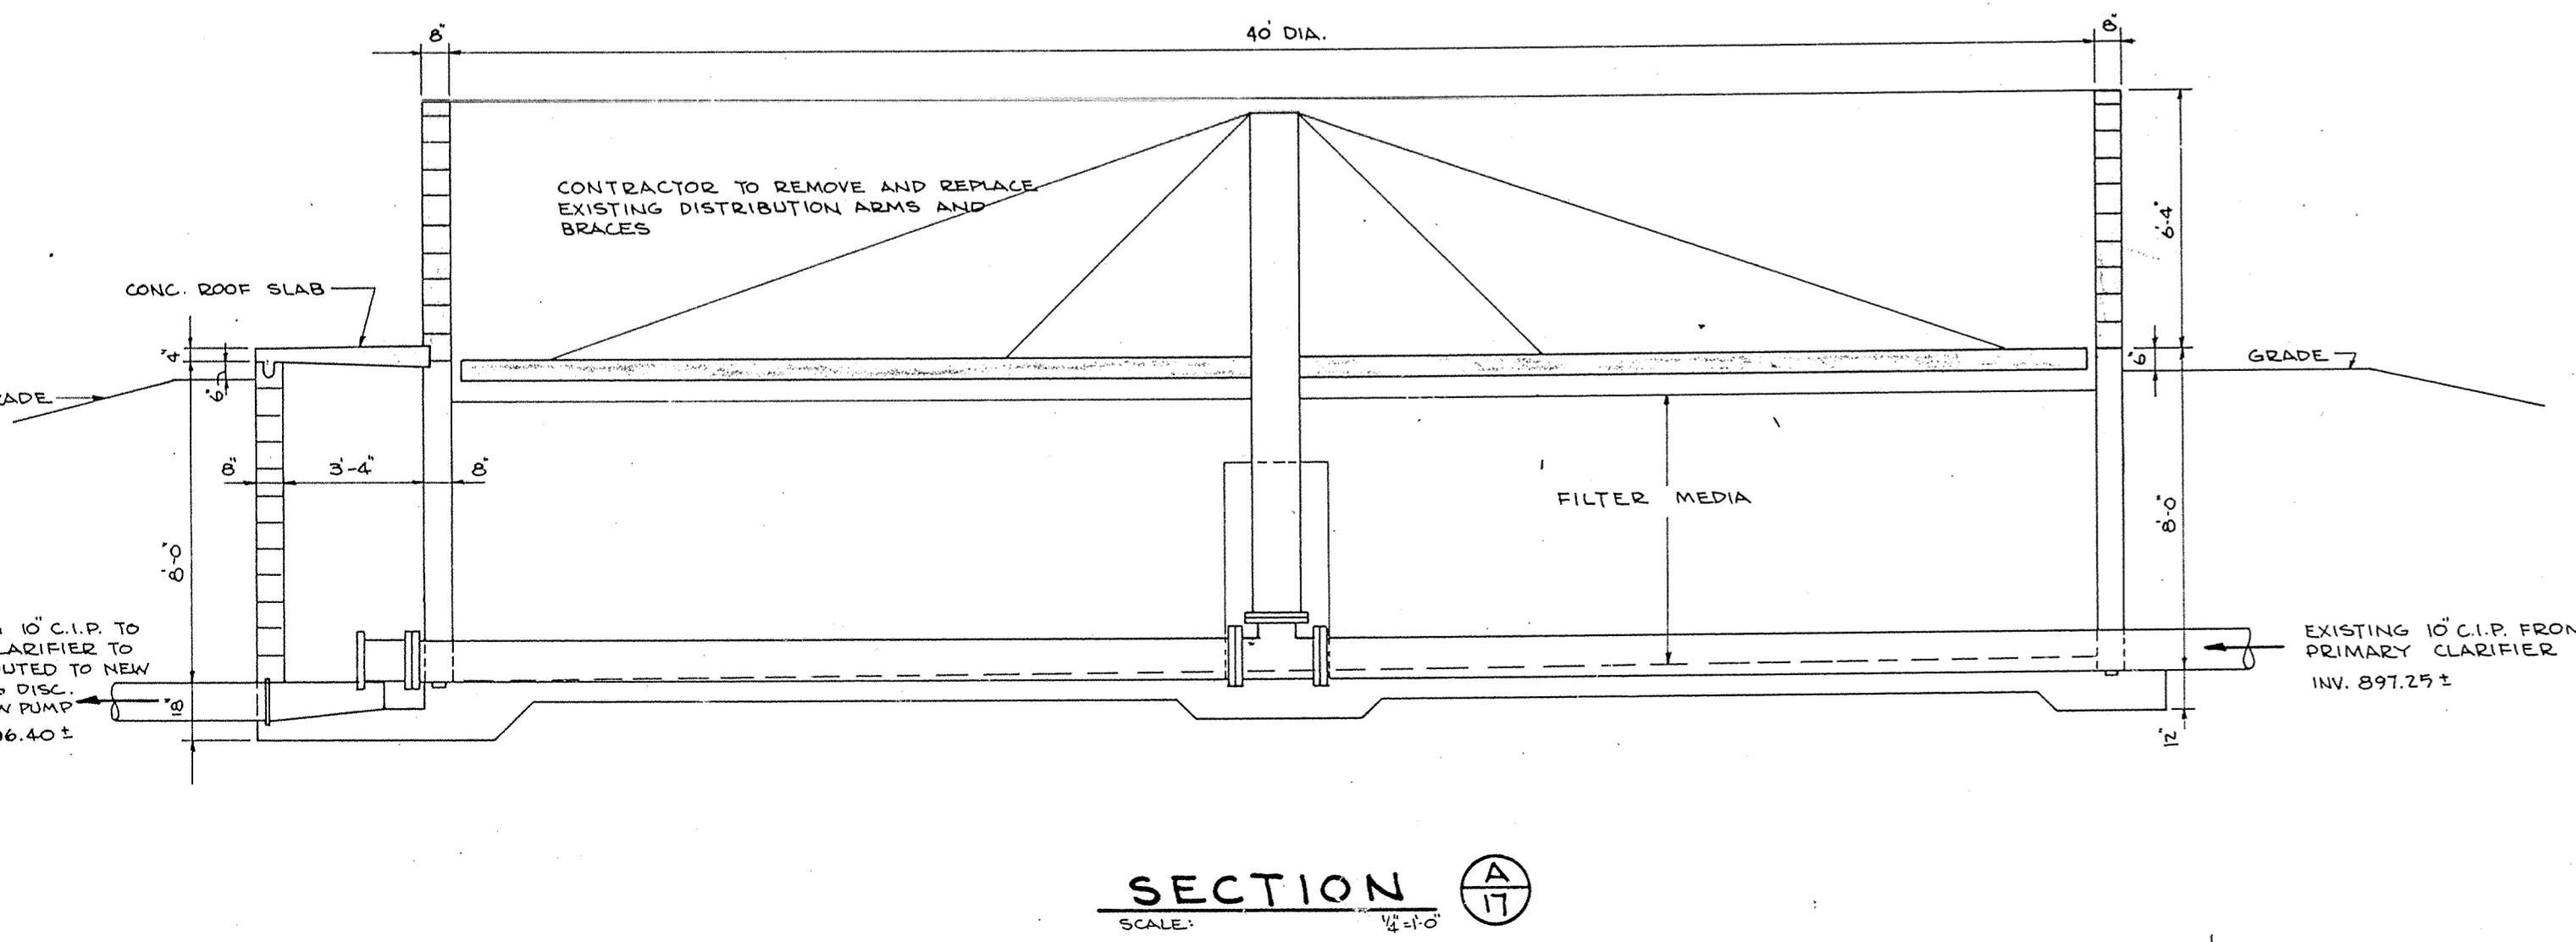


SABCO PRODUCTS • NEW HAVEN, CONNECTICUT
REGISTERED PROFESSIONAL ENGINEER
MINNESOTA
REGISTERED PROFESSIONAL ENGINEER
MINNESOTA
REGISTERED PROFESSIONAL ENGINEER
MINNESOTA
REGISTERED PROFESSIONAL ENGINEER
MINNESOTA

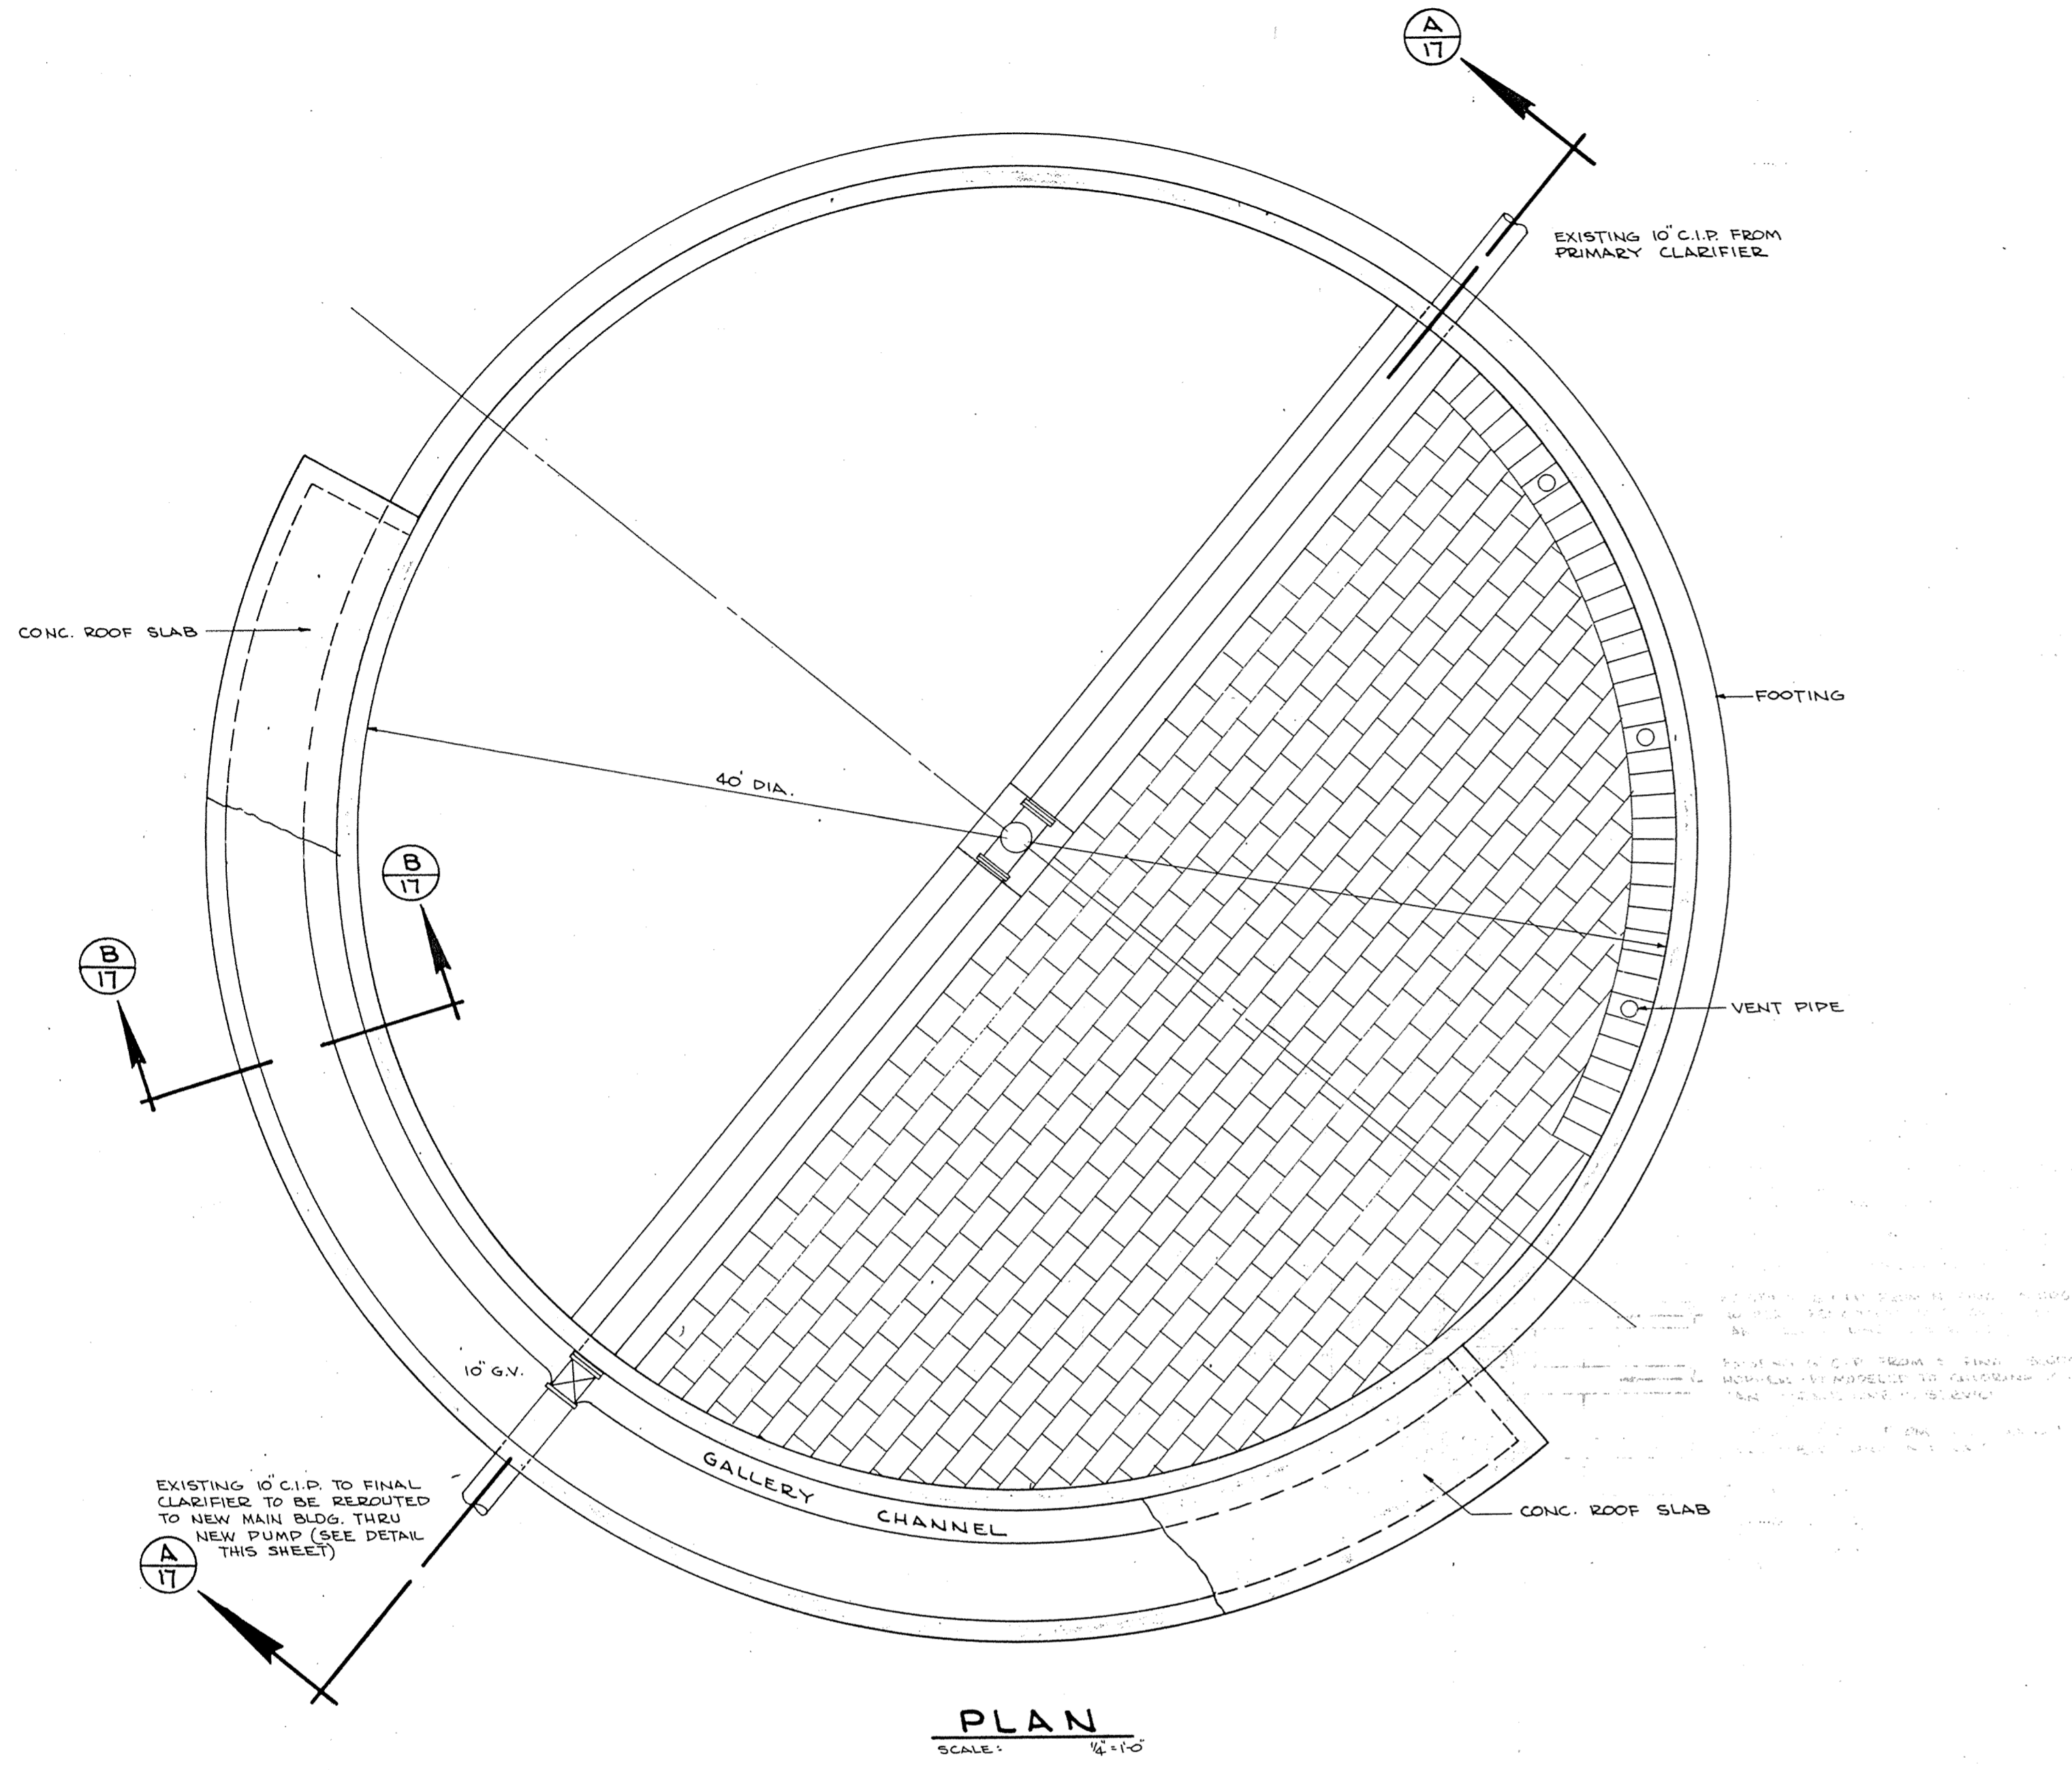

WASTE WATER TREATMENT FACILITIES
FOR
ELK RIVER, MINNESOTA

SCALE AS NOTED
BOOK PAGE
FILE NO. 2603

**TRICKLING FILTERS
MODIFICATIONS**

SHEET 17 OF 31
REV. A

NO.	DATE	BY	REMARKS
A	2-23-77	J.R.C.	ADDED GATE VALVE & CHECK VALVE TO LIFT STA.

DESIGNED **K.L.V.**
DRAWN **J.R.C.**
CHECKED **K.L.V.**
APPROVED **W.H.M.**
DATE **8/26/75**

I HEREBY CERTIFY THAT THIS PLAN WAS PREPARED BY ME OR UNDER MY DIRECT SUPERVISION AND THAT I AM A DULY REGISTERED PROFESSIONAL ENGINEER UNDER THE LAWS OF THE STATE OF MINNESOTA.
Karen L. Van Dack
DATE **Aug 29, 1975** REG. NO. **10159**

McCOMBS-KNUTSON ASSOCIATES, INC.
CONSULTING ENGINEERS • LAND SURVEYORS • SITE PLANNERS
MINNEAPOLIS, HUTCHINSON and MARSHALL, MINNESOTA