


# WASTE WATER TREATMENT FACILITIES

FOR

## ELK RIVER, MINNESOTA

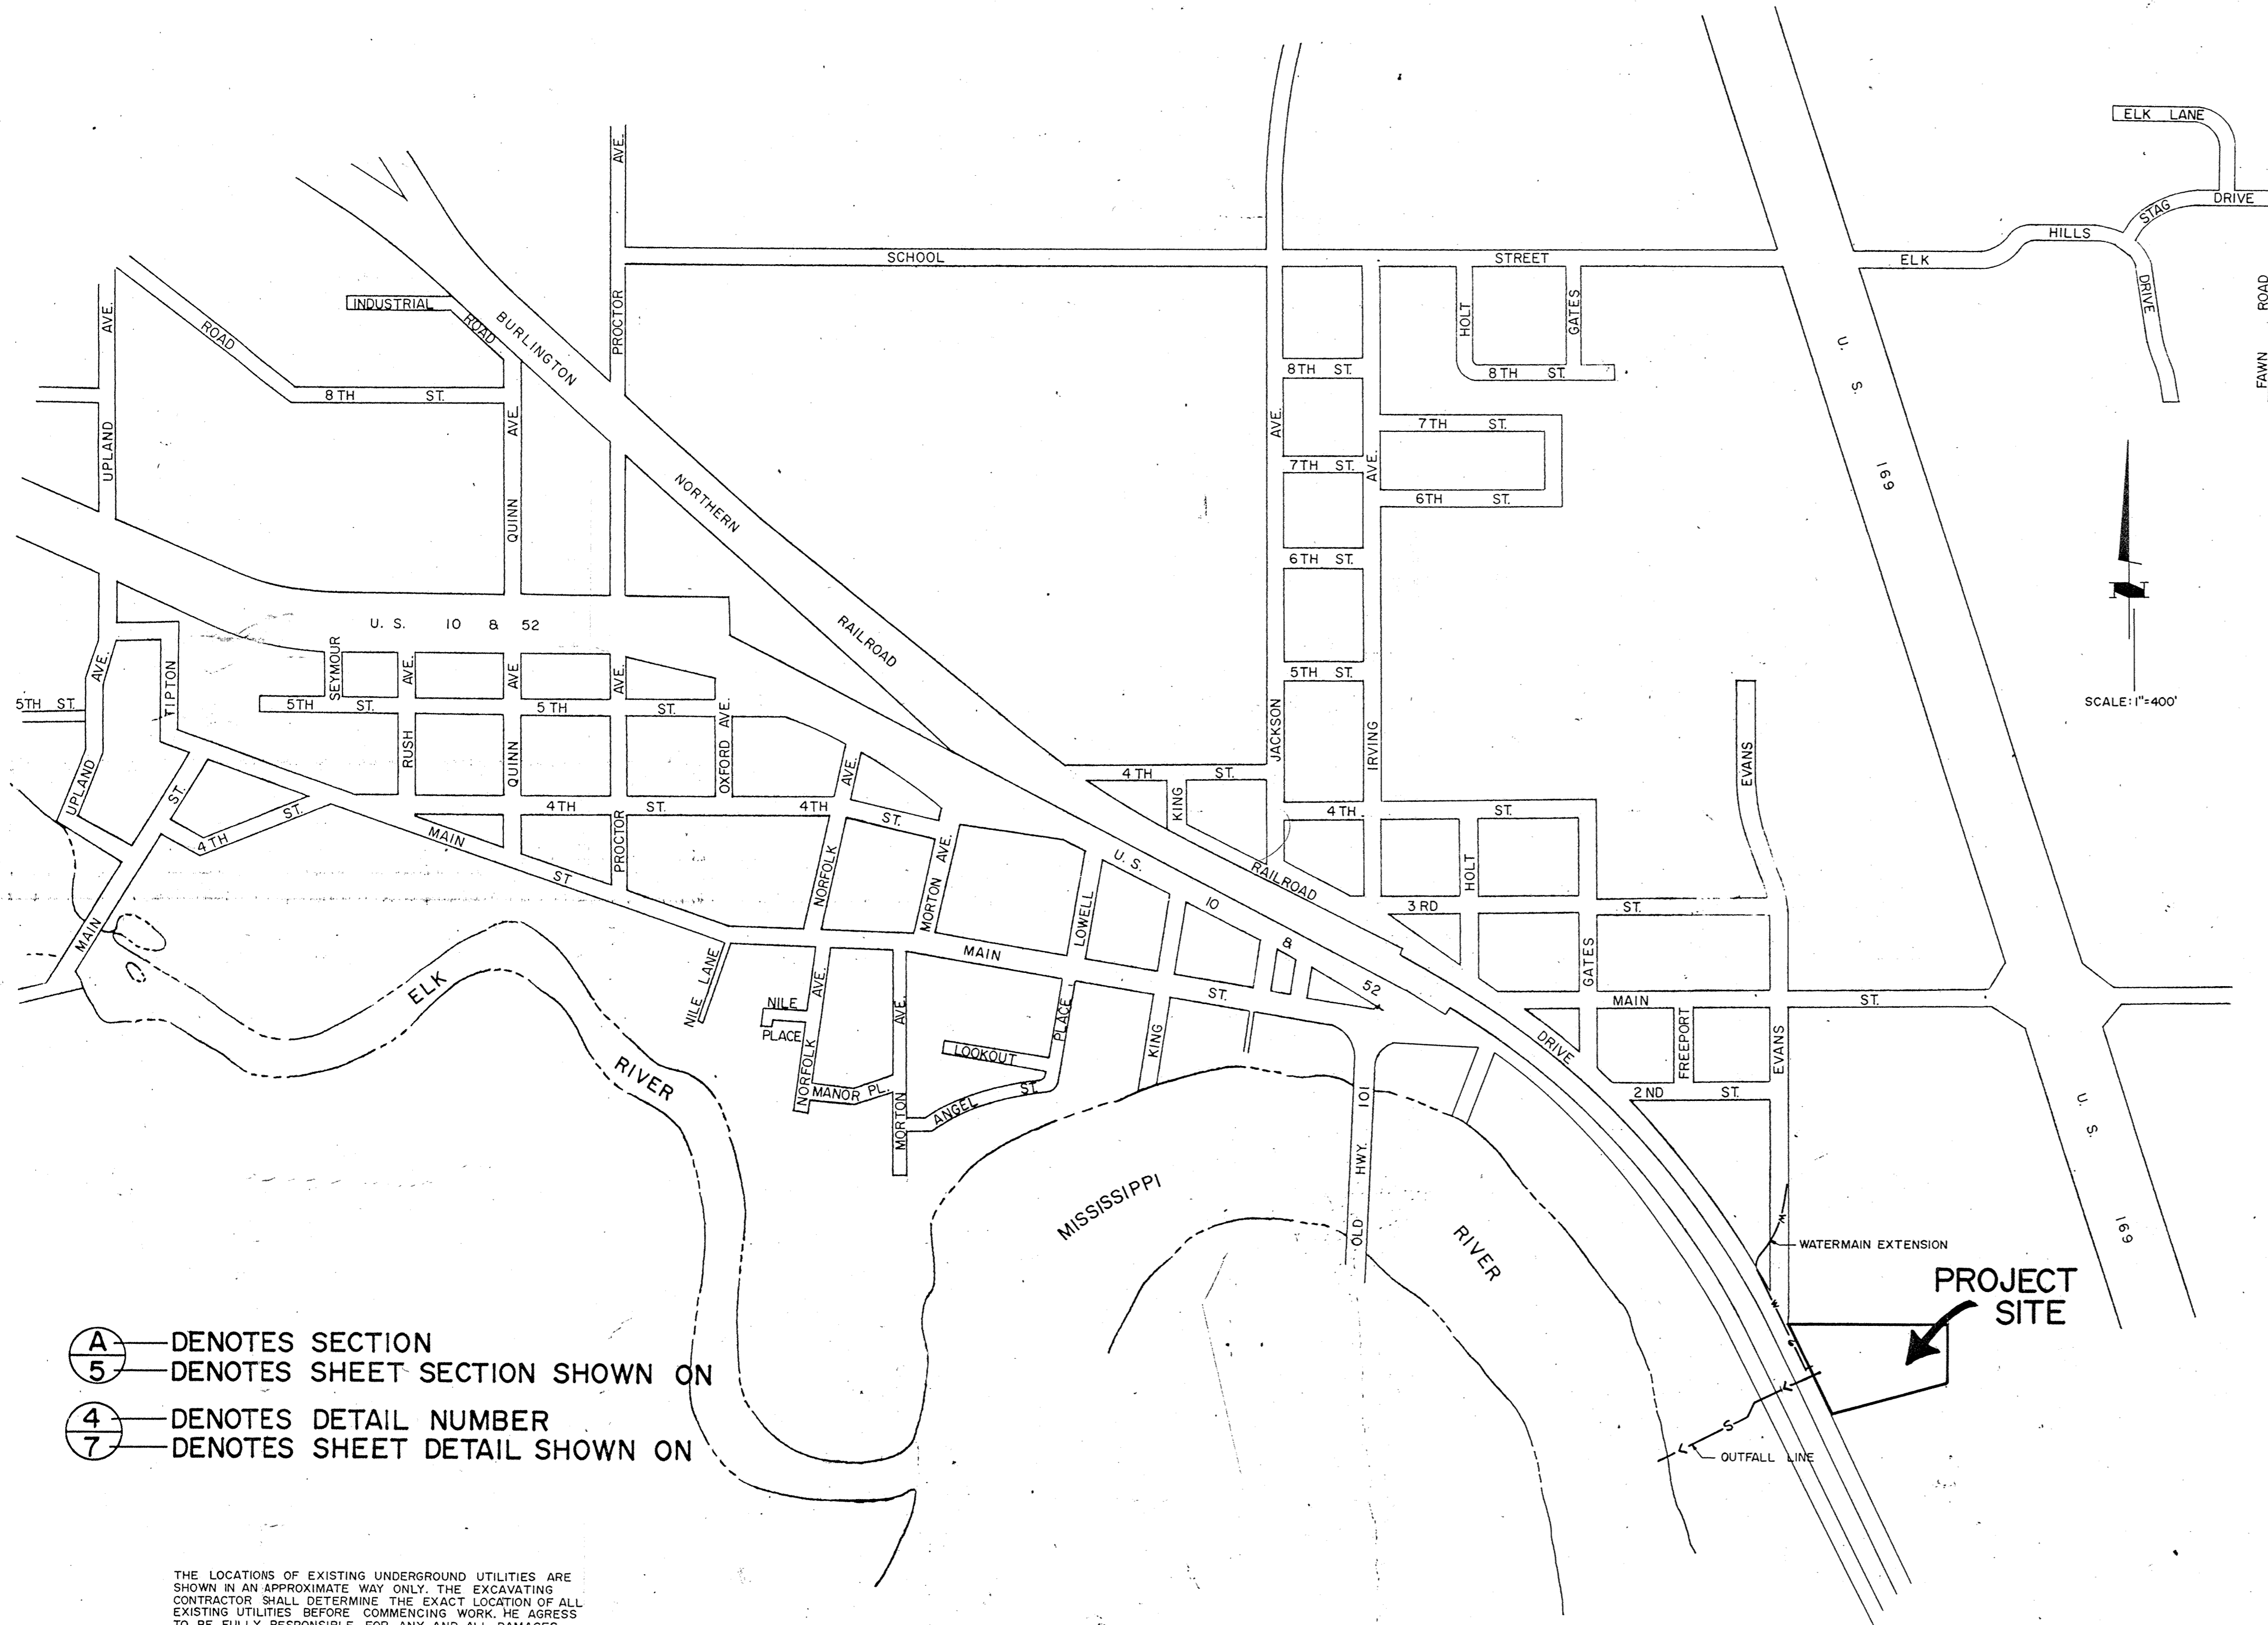

(A) DENOTES SECTION  
 (5) DENOTES SHEET SECTION SHOWN ON  
 (4) DENOTES DETAIL NUMBER  
 (7) DENOTES SHEET DETAIL SHOWN ON

THE LOCATIONS OF EXISTING UNDERGROUND UTILITIES ARE SHOWN IN AN APPROXIMATE WAY ONLY. THE EXCAVATING CONTRACTOR SHALL DETERMINE THE EXACT LOCATION OF ALL EXISTING UTILITIES BEFORE COMMENCING WORK. HE AGREES TO BE FULLY RESPONSIBLE FOR ANY AND ALL DAMAGES WHICH MIGHT BE OCCASIONED BY HIS FAILURE TO EXACTLY LOCATE AND PRESERVE ANY AND ALL UNDERGROUND UTILITIES.

COUNCIL

- MAYOR – CLIFFORD LUNDBERG  
 COUNCILMEN – LARRY TATE  
 – ROBERT OTTO  
 – WILLIAM KONOP  
 – ROBERT SYRING  
 CLERK-TREASURER  
 – CHARLES SAVELA  
 FORMER COUNCILMAN  
 – THOMAS HUDSON

### TABLE OF CONTENTS

PAGE	DESCRIPTION
1	TITLE SHEET
2	SCHEMATIC FLOW DIAGRAM
3	SITE GRADING PLAN
4	SITE PIPING PLAN
5	WATER EXTENSION
6	OUTFALL LINE
7	ARCHITECTURAL AND STRUCTURAL PRETREATMENT BLDG.
8	ARCHITECTURAL AND STRUCTURAL DETAILS PRETMT. BLDG.
9	STRUCTURAL PLANS PRIMARY CLARIFIER NO. 2
10	STRUCTURAL PLAN SECONDARY CLARIFIERS NO.1 AND NO.2
11	ARCHITECTURAL AND STRUCTURAL MAIN BUILDING
12	ARCHITECTURAL AND STRUCTURAL MAIN BUILDING
13	FOUNDATION PLAN DIGESTER AND DIGESTER CONTROL BLDG.
14	STRUCTURAL FRAMING PLAN DIGEST. AND DIGEST. CONT. BLDG.
15	STRUCTURAL SECTION DIGESTER AND DIGESTER CONTROL BLDG.
16	ARCHITECTURAL DIGESTER BUILDING
17	TRICKLING FILTERS MODIFICATIONS
18	CONTROL BUILDING MODIFICATIONS
19	MECHANICAL PLAN PRETREATMENT BUILDING
20	MECHANICAL PLAN PRETREATMENT BUILDING
21	MECHANICAL PLAN PRIMARY CLARIFIER NO. 2
22	MECHANICAL PLAN MAIN BUILDING
23	MECHANICAL PLAN FINAL CLARIFIERS NO. 1 AND NO. 2
24	MECHANICAL PLAN CHLORINATION TANK
25	MECHANICAL SECTION DIGESTER BUILDING
26	MECHANICAL PLAN DIGESTER BUILDING
27	MISCELLANEOUS DETAILS
28	ELECTRICAL SITE PLAN
29	ELECTRICAL PLAN BUILDING AND PUMPING STATION
30	ELECTRICAL PLAN DIGESTERS
31	ELECTRICAL PLAN CONTROL PANELS

NO.	DATE	BY	REMARKS

DESIGNED K.L.V.	CHECKED K.L.V.
DRAWN J.J.A.	APPROVED W.H.M.
DATE 8/26/75	COMM. 

I HEREBY CERTIFY THAT THIS PLAN WAS PREPARED BY ME OR UNDER MY DIRECT SUPERVISION AND THAT I AM A DULY REGISTERED PROFESSIONAL ENGINEER UNDER THE LAWS OF THE STATE OF MINNESOTA.  
*Karen L. Van Osbeke*  
 DATE *Aug 29, 1975* REG. NO. *10159*

**McCOMBS-KNUTSON ASSOCIATES, INC.**  
 CONSULTING ENGINEERS ■ LAND SURVEYORS ■ SITE PLANNERS  
 MINNEAPOLIS, HUTCHINSON and MARSHALL, MINNESOTA

**WASTE WATER TREATMENT FACILITIES**  
 FOR  
**ELK RIVER, MINNESOTA**

SCALE AS NOTED
BOOK PAGE
FILE NO. 2603

TITLE SHEET	SHEET 1	REV. 
	OF 31	

DRAWING NUMBER  
 WASTE 75  
 1