





KAI#94356VI--SHEET E26--PS: 26=12

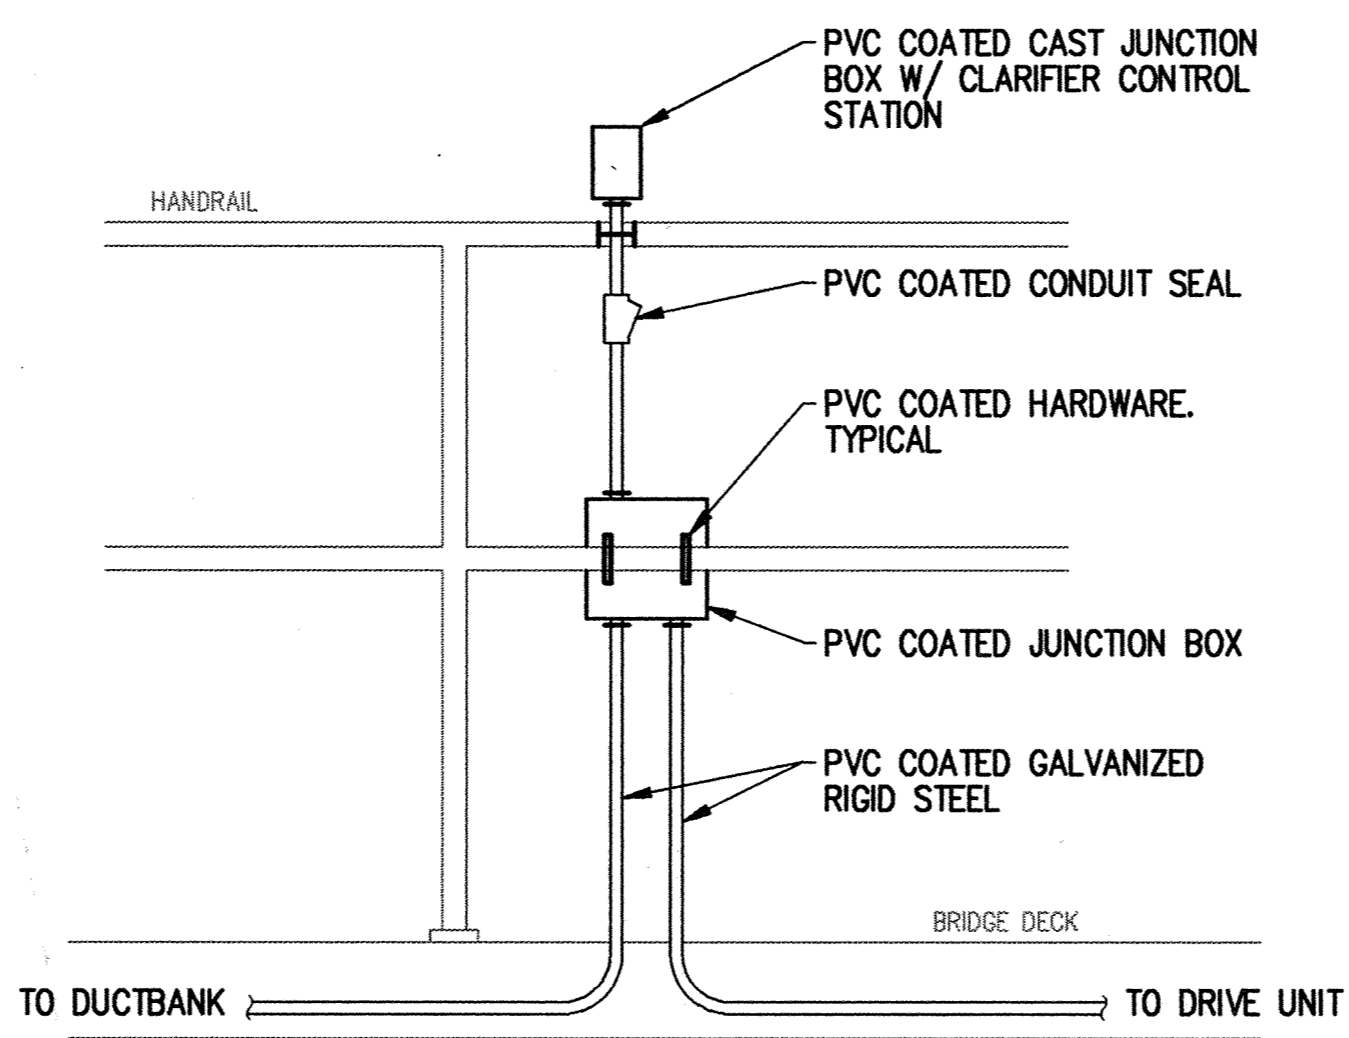


CLARIFIER CONTROL STATION DETAIL
NO SCALE

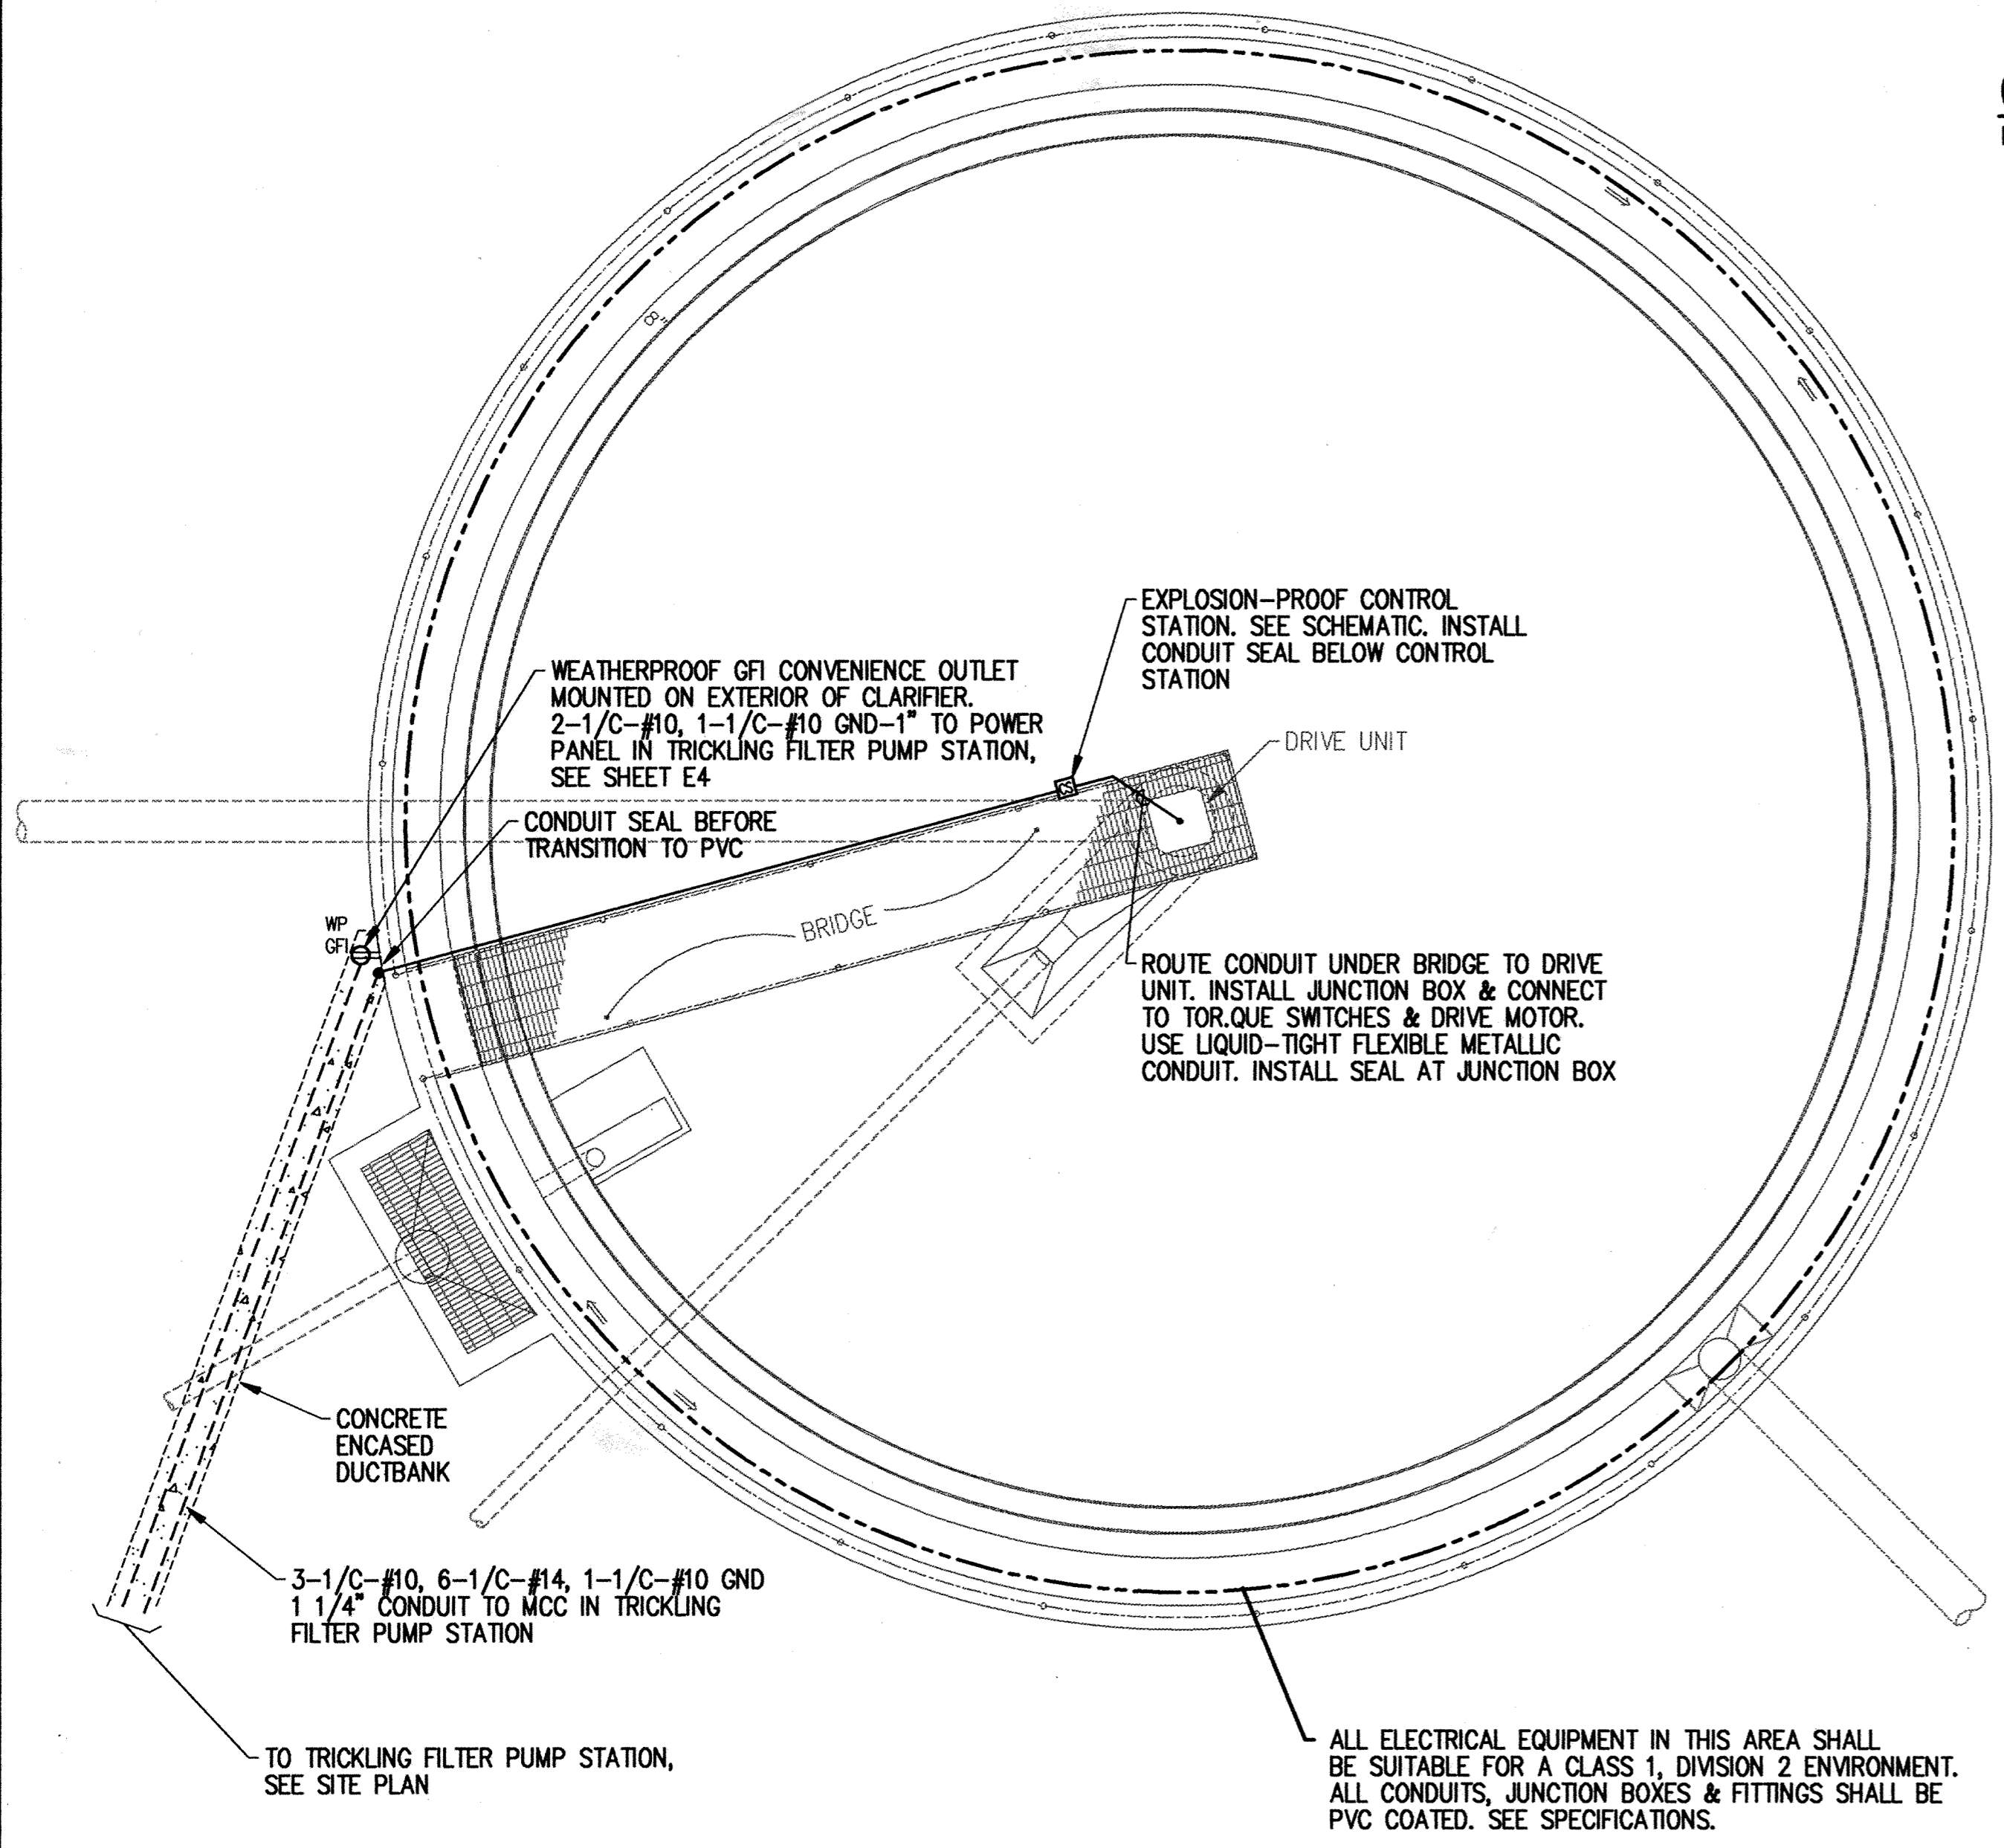

PRIMARY CLARIFIER ELECTRICAL PLAN
SCALE: 1/4"=1'-0"

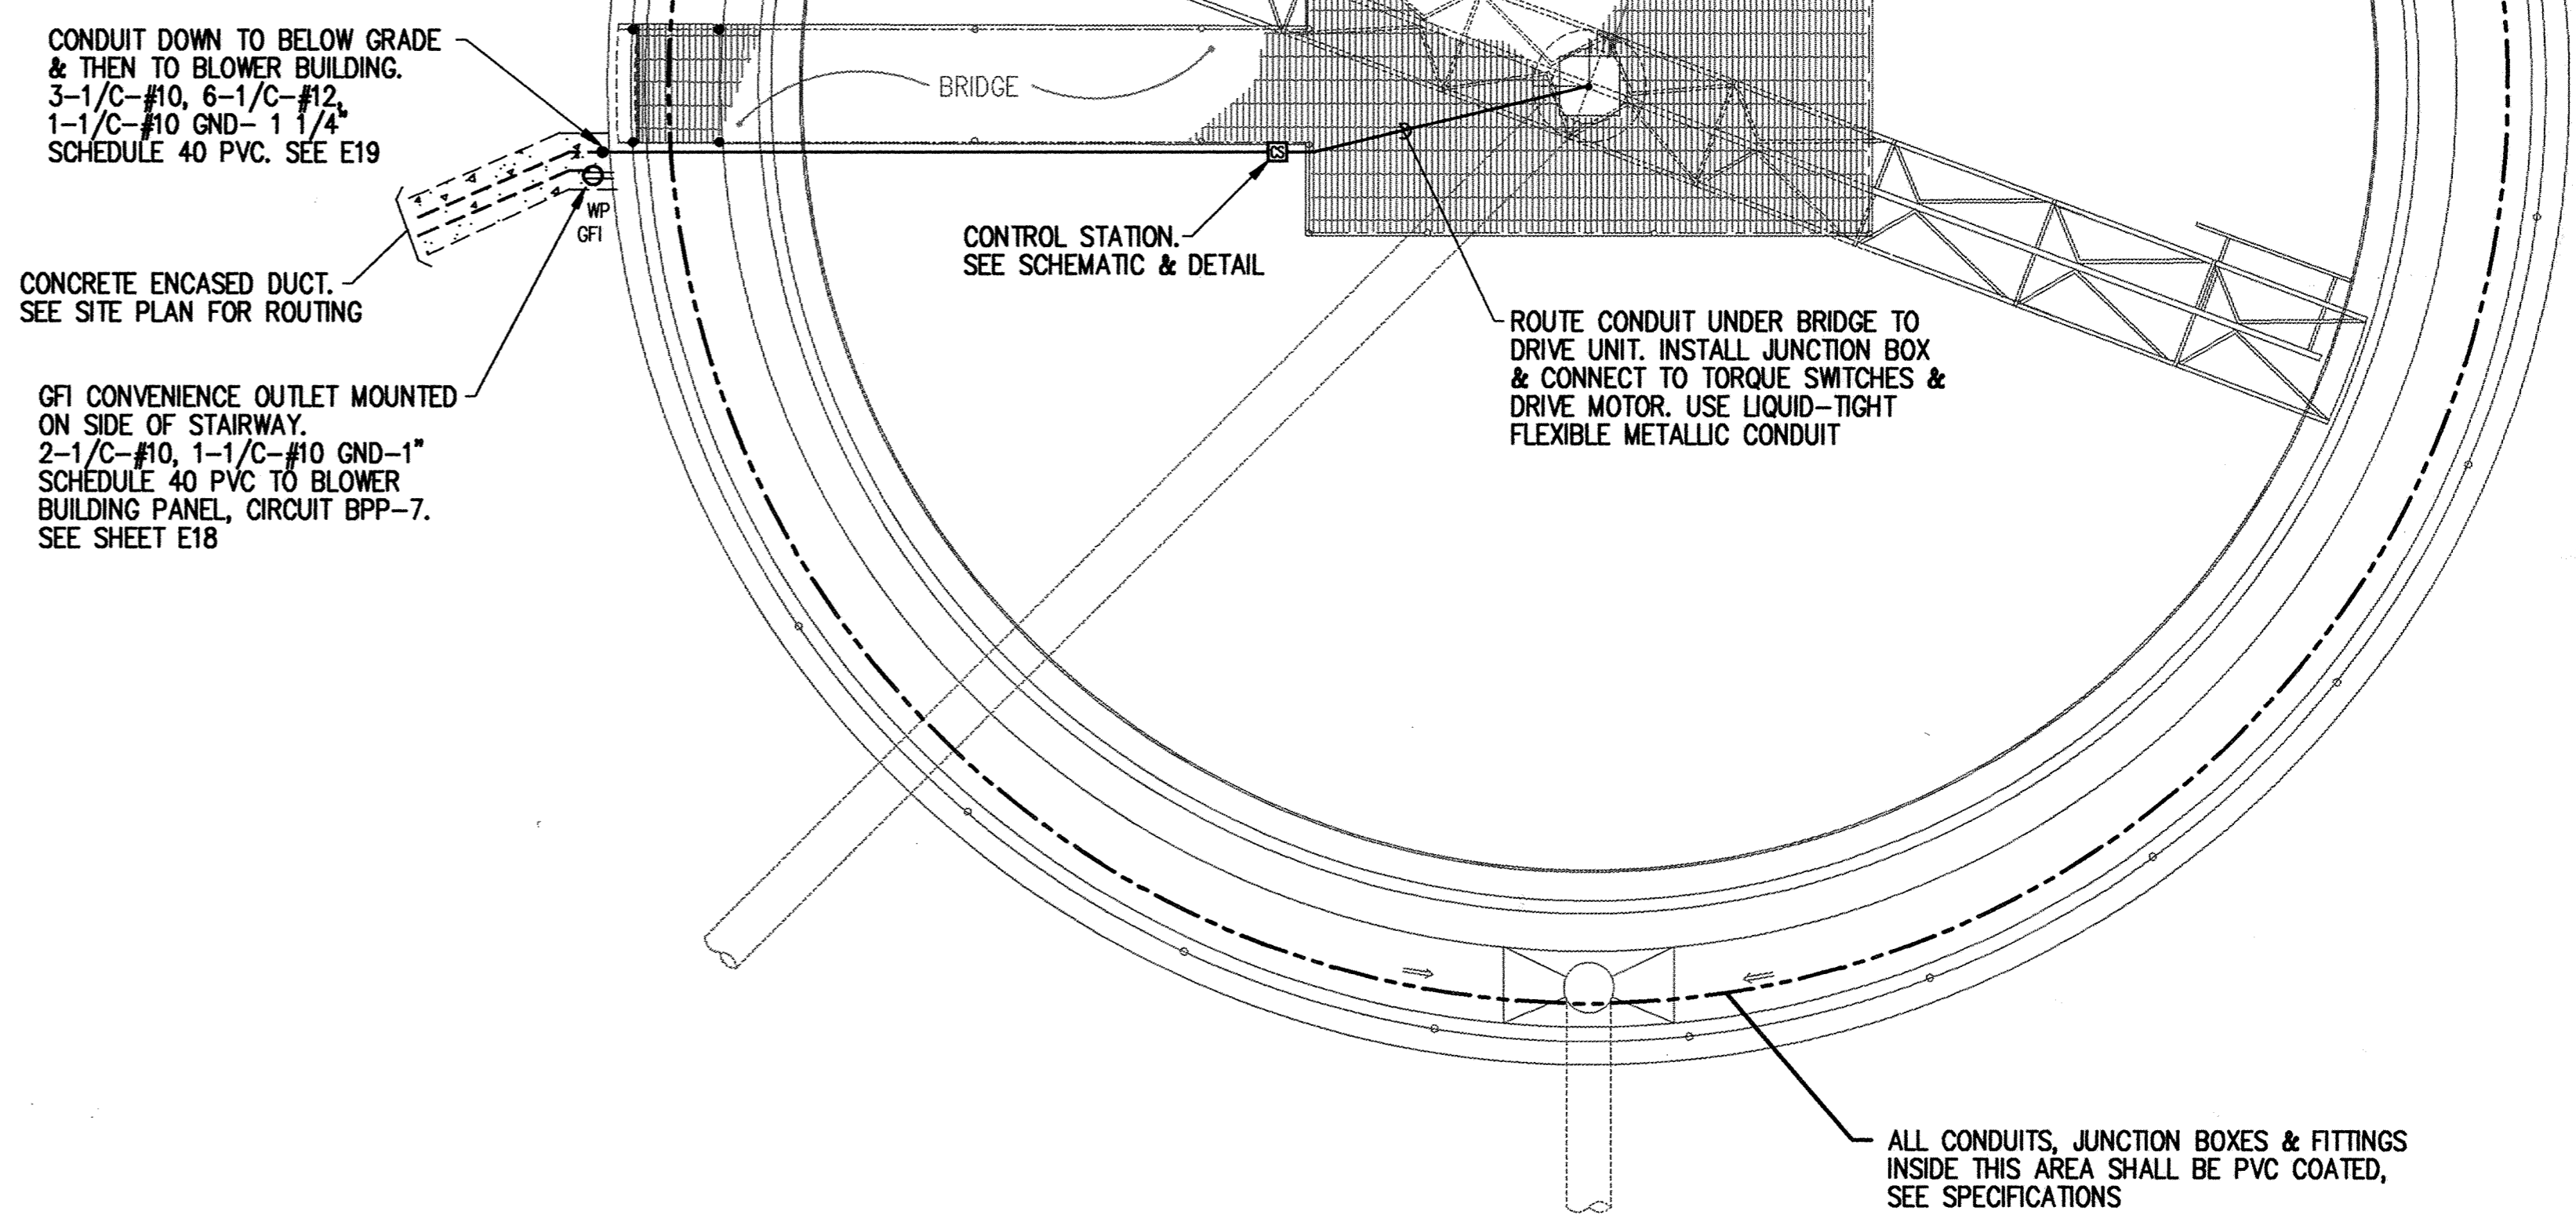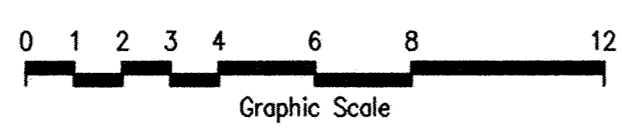

 FINAL CLARIFIER ELECTRICAL PLAN
SCALE: 1/4"=1'-0" TYPICAL



This drawing was prepared by:
Kaeding & Associates, Inc.
7300 France Avenue South
Suite 330
Minneapolis, MN 55435
Telephone: (612) 831-0317
Fax: (612) 831-2179

I HEREBY CERTIFY THAT THIS PLAN, SPECIFICATION, OR REPORT WAS PREPARED BY ME OR UNDER MY DIRECT SUPERVISION AND THAT I AM A DULY REGISTERED PROFESSIONAL ENGINEER UNDER THE LAWS OF THE STATE OF MINNESOTA.

[Signature]

DATE: 06 OCT 95 REG. NO.: 9955



1326 ENERGY PARK DRIVE
ST. PAUL, MINNESOTA 55108
(612) 644-4389

5075 WAYZATA BLVD. SUITE 225
MINNEAPOLIS, MINNESOTA 55441
(612) 546-0432

DATE	DESCRIPTION	DESIGNED	PKK
		CHECKED	PKK
		DRAWN	CPM
		GRAPHIC SCALE	
		0 HORIZ.	
		0 VERT.	

CITY OF ELK RIVER
WASTEWATER TREATMENT FACILITIES
PRIMARY & FINAL CLARIFIER ELECTRICAL PLANS

DATE: OCT 1995 SHEET 12 OF 12 SHEETS PROJECT NO. 230-151

E26