




**TYPICAL EXTERIOR FOUNDATION WALL SECTION** 5  
Scale: 3/4" = 1'-0" S9

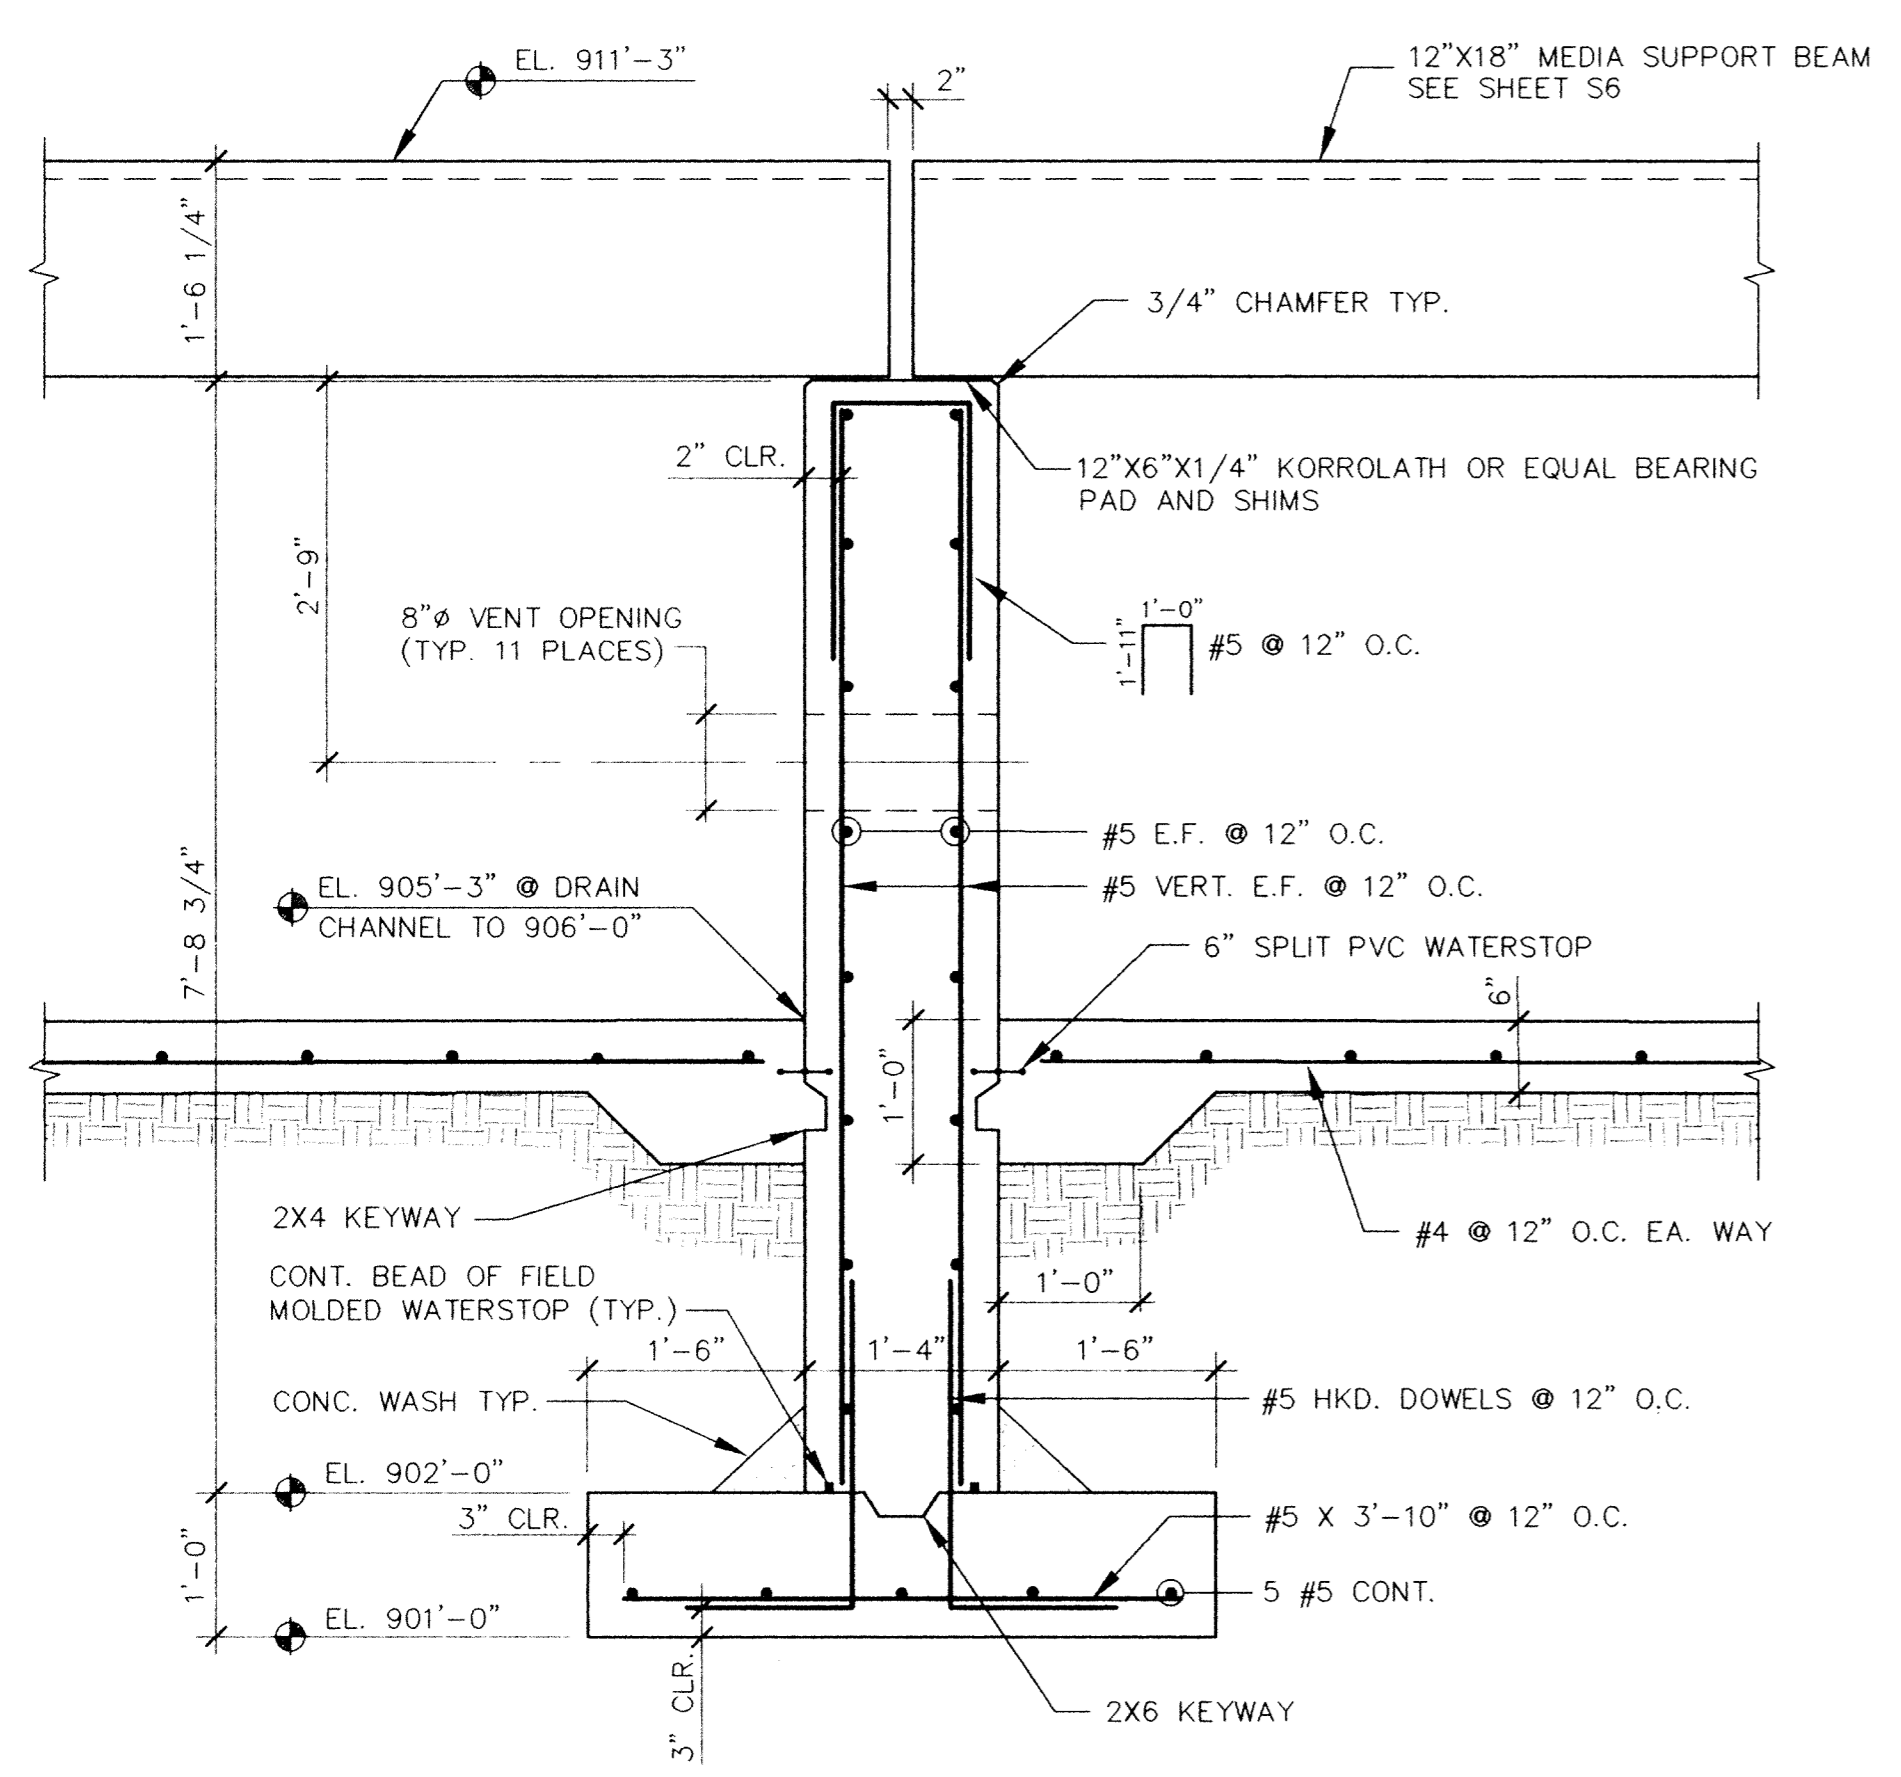


**TYPICAL INTERIOR FOUNDATION WALL SECTION** 6  
Scale: 3/4" = 1'-0" S9

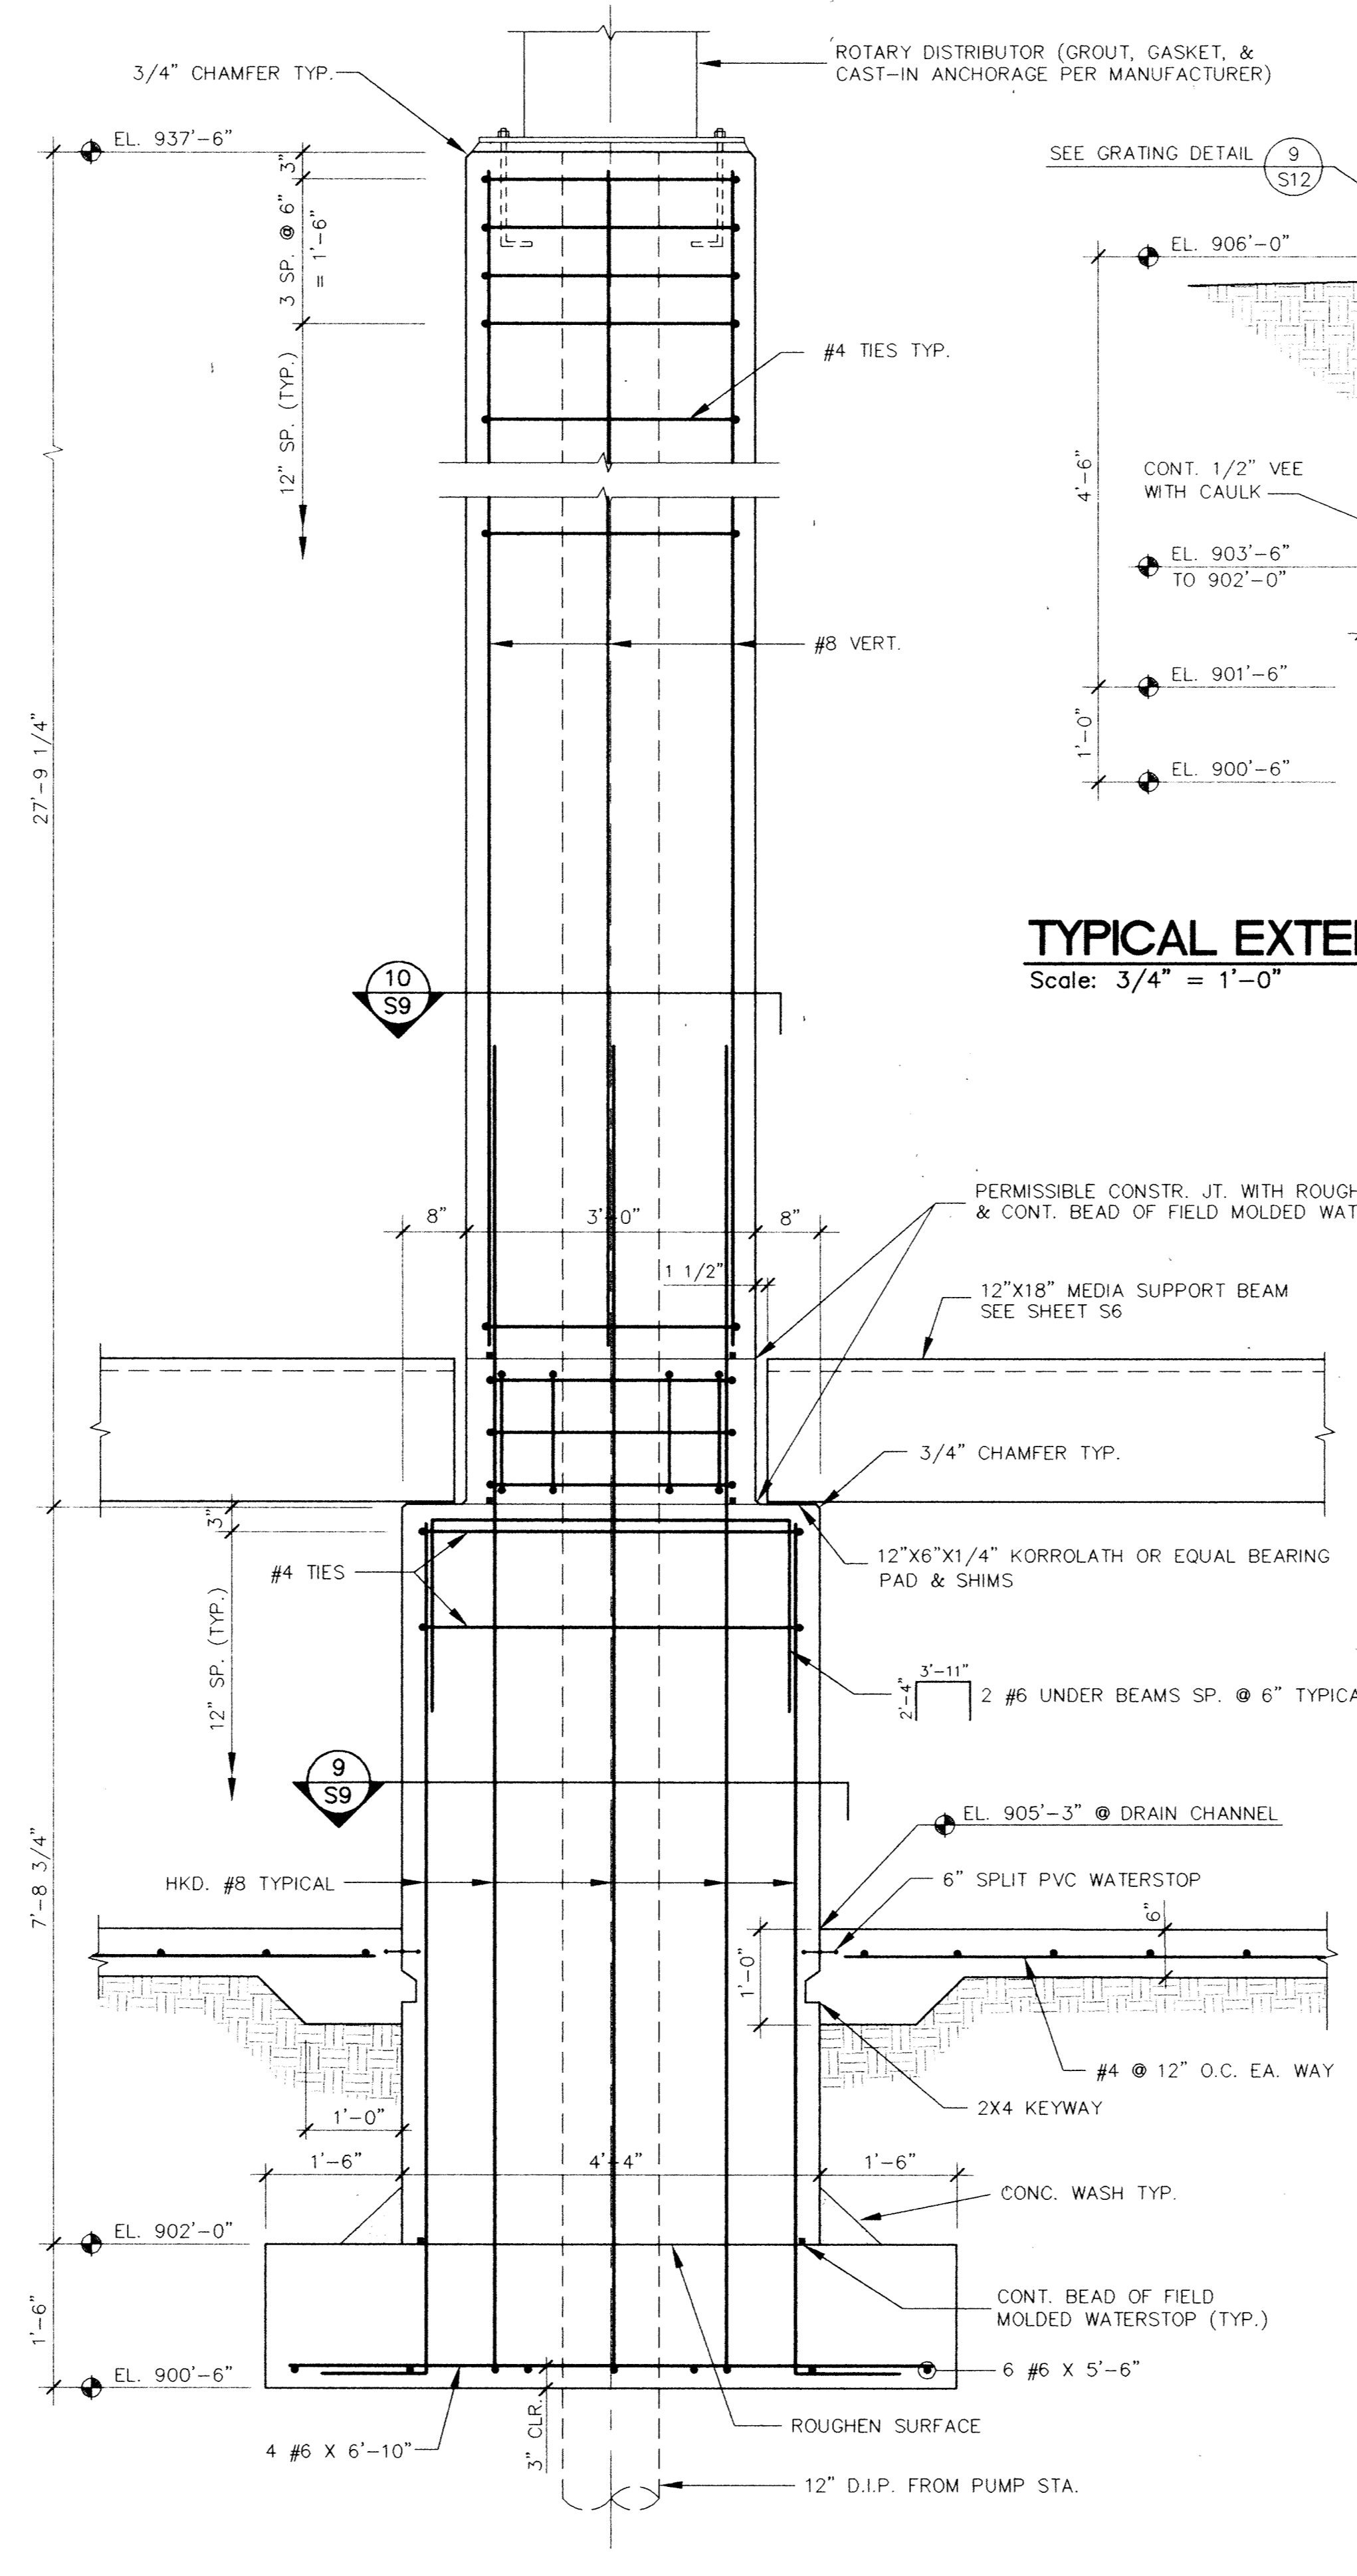


**CENTER COLUMN SECTION** 7  
Scale: 3/4" = 1'-0" S9

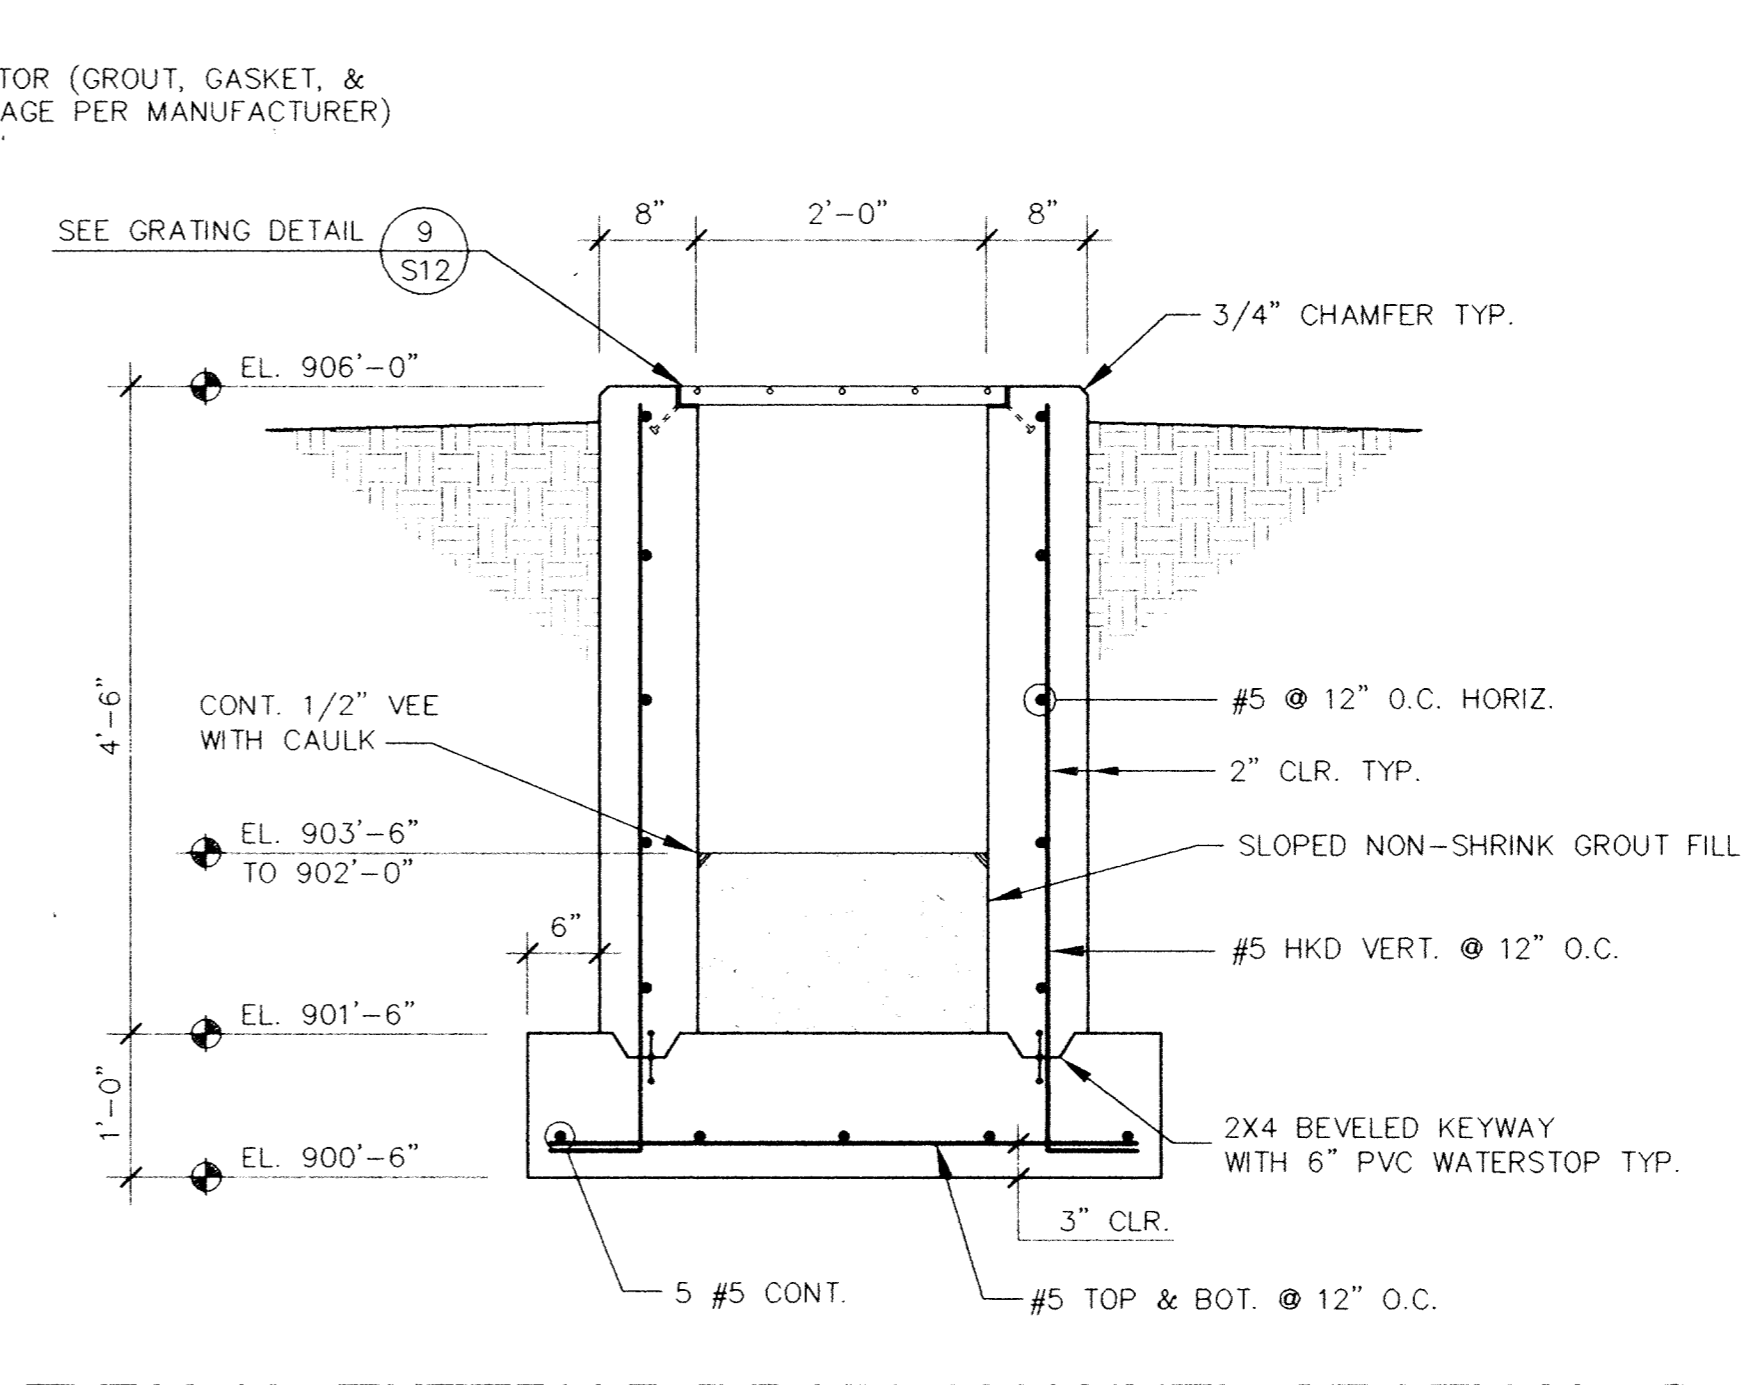


**TYPICAL EXTERIOR DRAIN CHANNEL SECTION** 11  
Scale: 3/4" = 1'-0" S9

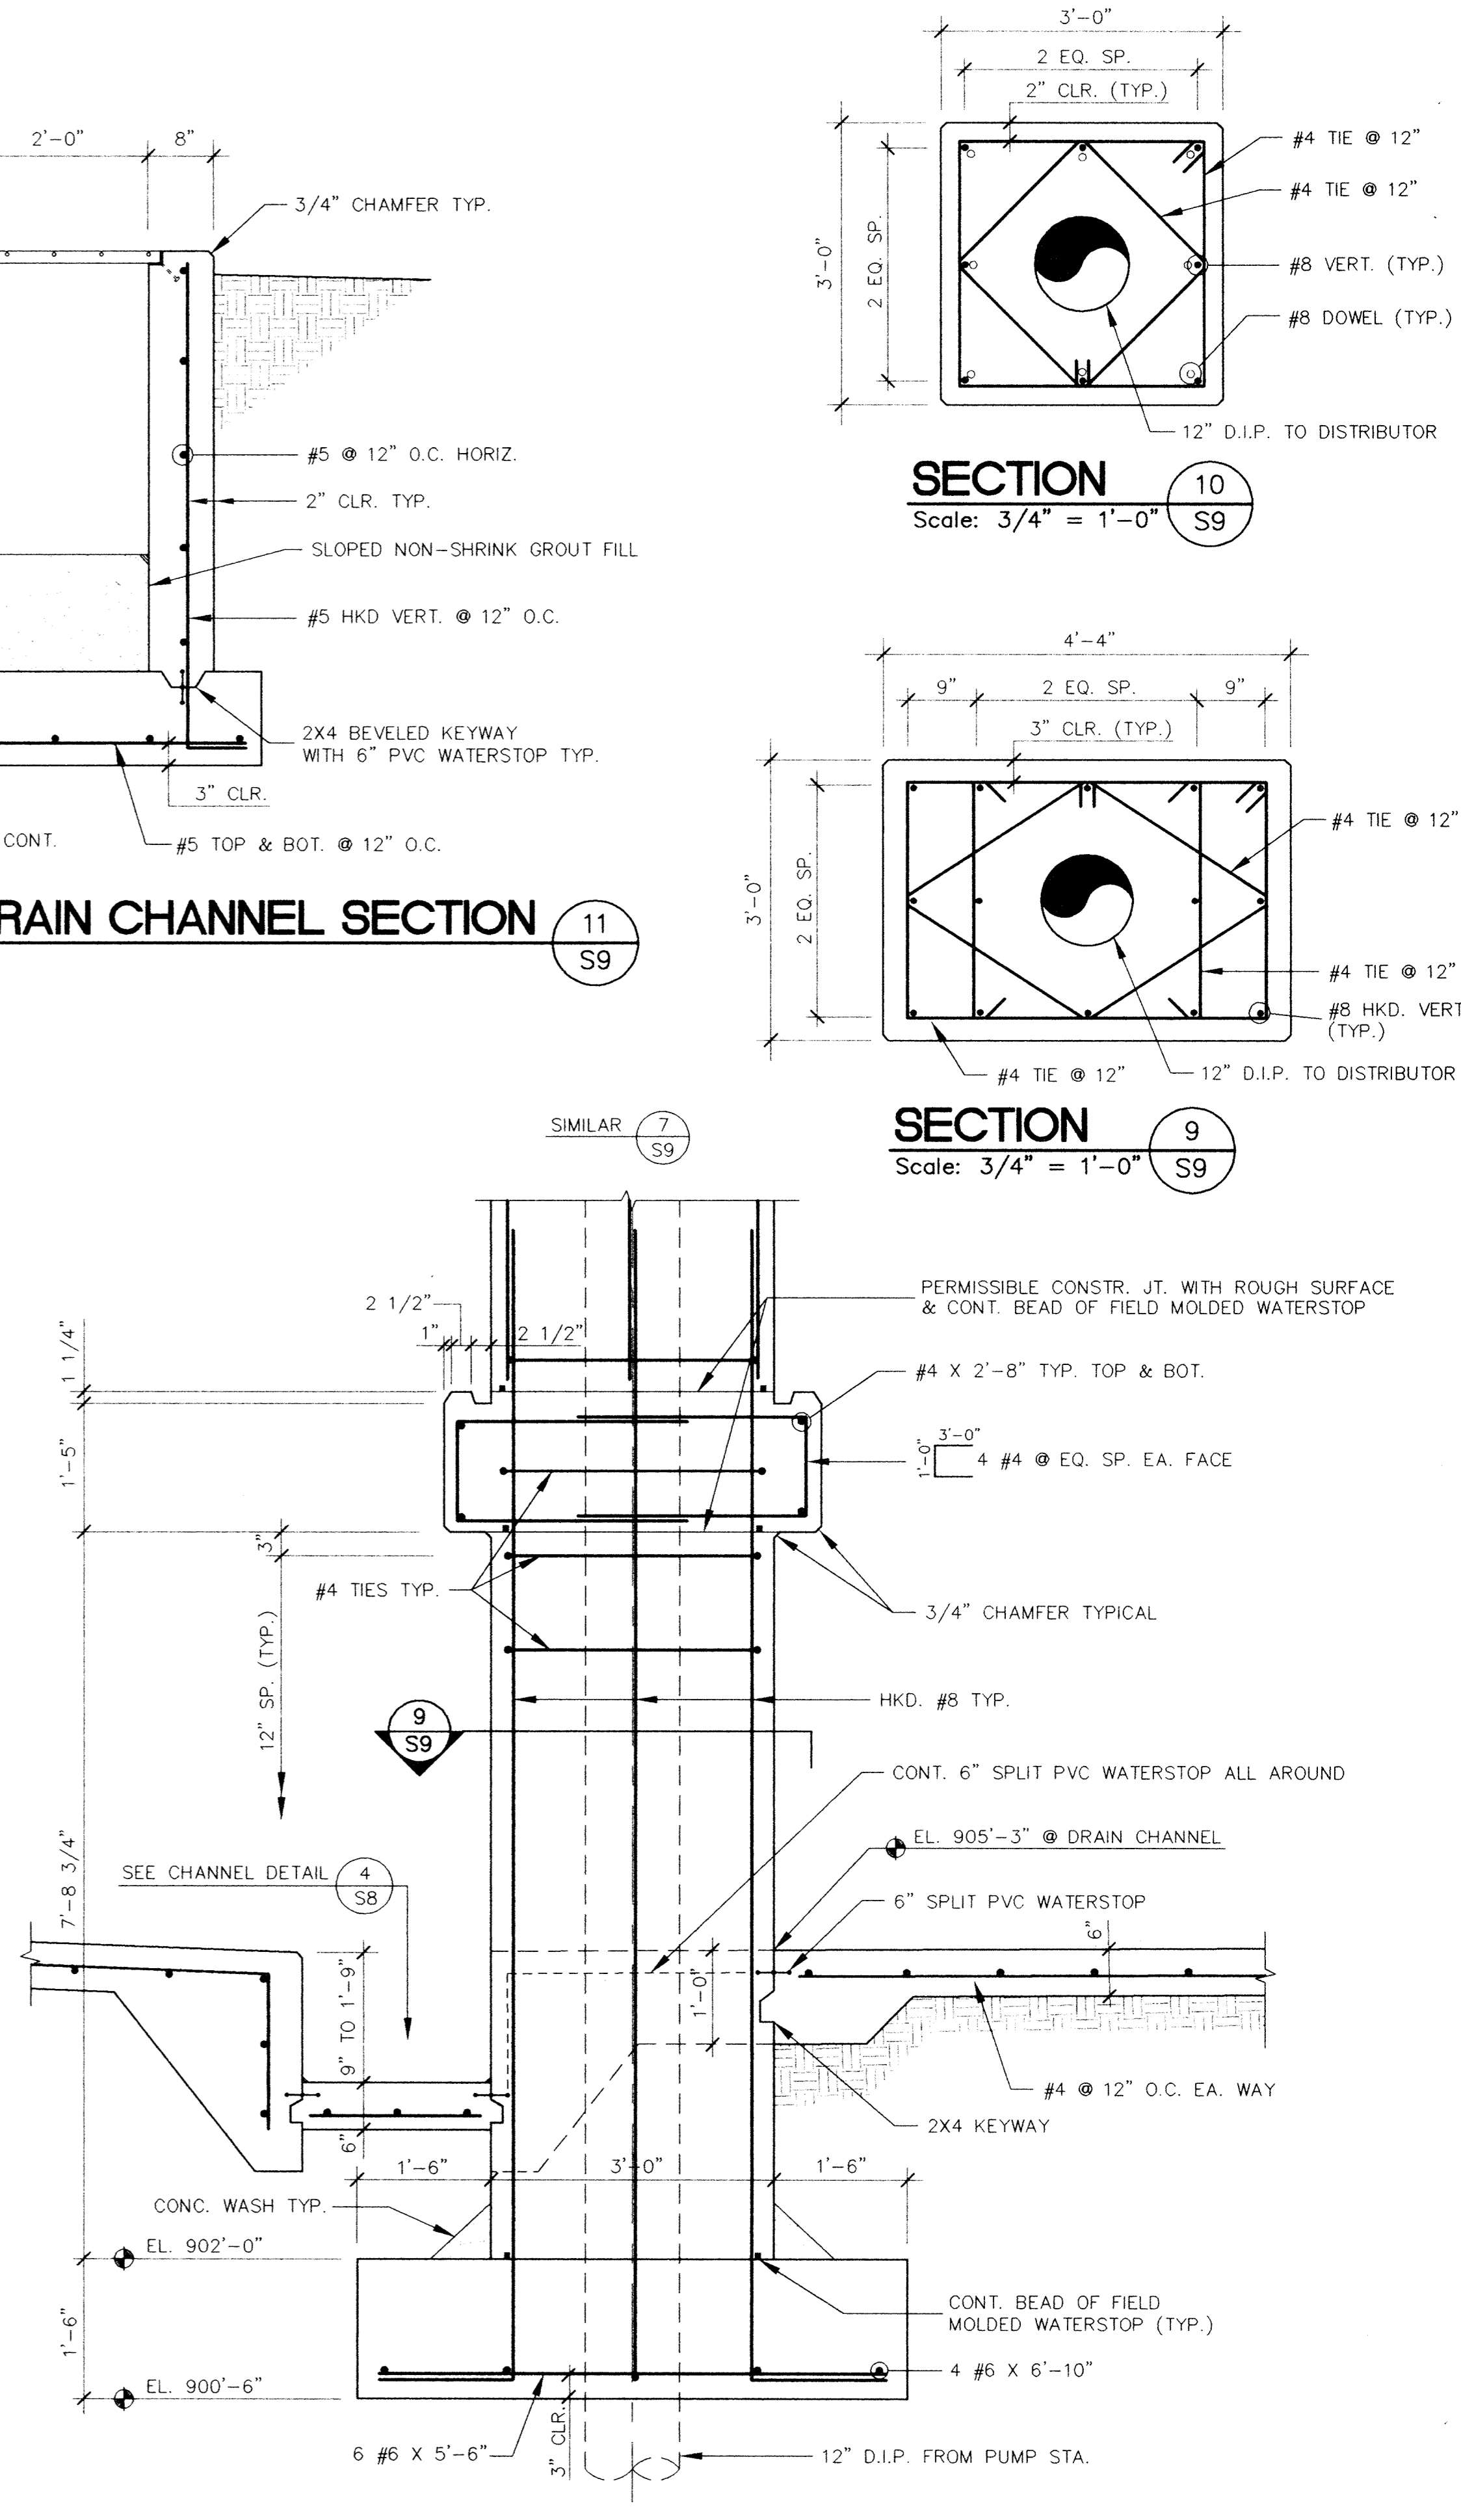

**CENTER COLUMN SECTION** 8  
Scale: 3/4" = 1'-0" S9

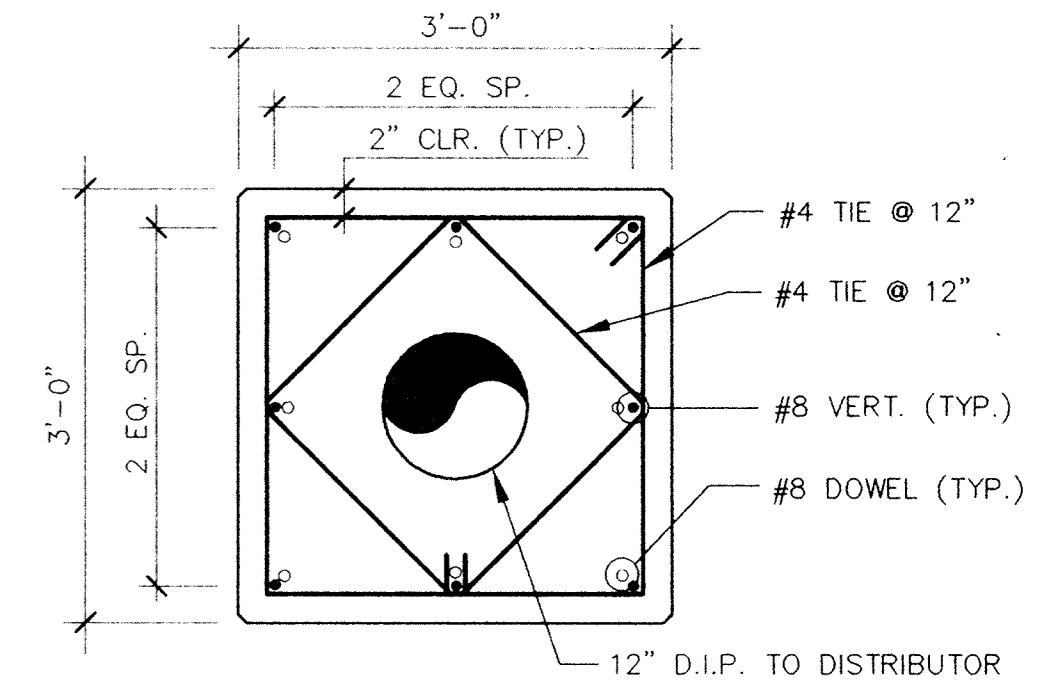

**SECTION** 10  
Scale: 3/4" = 1'-0" S9

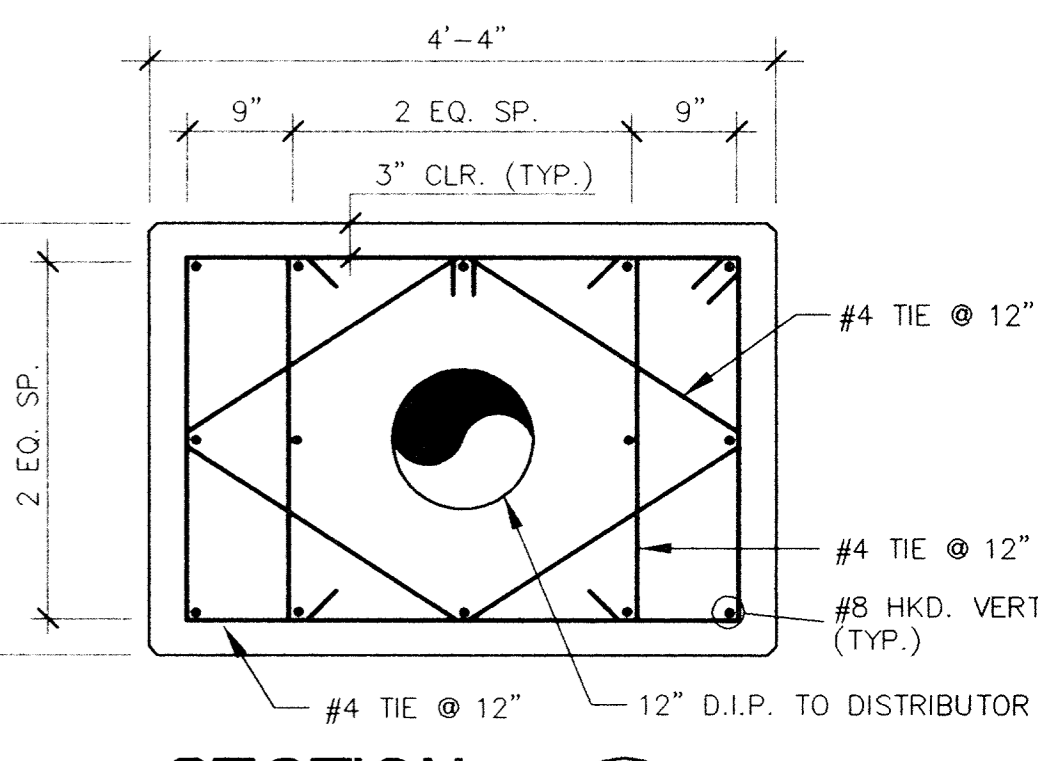

**SECTION** 9  
Scale: 3/4" = 1'-0" S9

S9, Feb. 26, 11:51:19 1994

ER151-16

I HEREBY CERTIFY THAT THIS PLAN, SPECIFICATION, OR REPORT WAS PREPARED BY ME OR UNDER MY DIRECT SUPERVISION AND THAT I AM A DULY REGISTERED PROFESSIONAL ENGINEER UNDER THE LAWS OF THE STATE OF MINNESOTA.  
*David L. Condit*  
DATE: 3/27/94 REG. NO. 22222

**MSA**  
CONSULTING ENGINEERS

1326 ENERGY PARK DRIVE  
ST. PAUL, MINNESOTA 55108  
(612) 644-4389  
  
9800 SHELARD PARKWAY  
MINNEAPOLIS, MINNESOTA 55441  
(612) 546-0432

DATE	DESCRIPTION	DESIGNED DLG/GG
		CHECKED L/L
		DRAWN GG
		GRAPHIC SCALE
		0 HORIZ. 1.33
		0 VERT. 1.33

CITY OF ELK RIVER  
WASTEWATER TREATMENT FACILITIES  
TRICKLING FILTER  
STRUCTURAL SECTIONS  
DATE: DEC. 1993 SHEET 16 OF 41 SHEETS PROJECT NO. 230-151

**S9**