




SECTION C-19
SCALE: 1/4" = 1'-0"

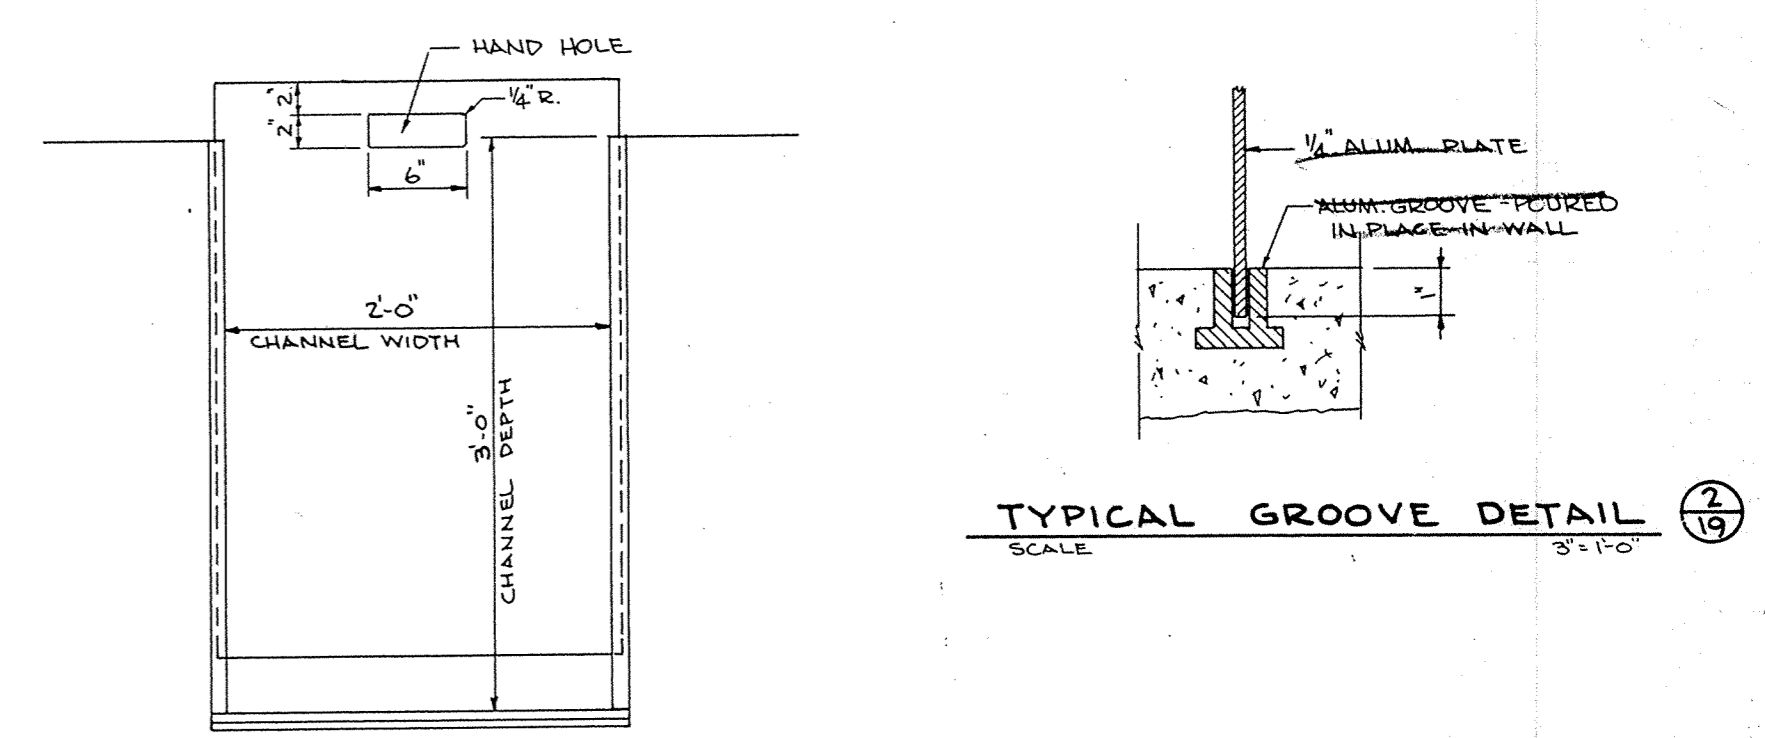

TYPICAL GROOVE DETAIL C-18
SCALE: 3/8" = 1'-0"

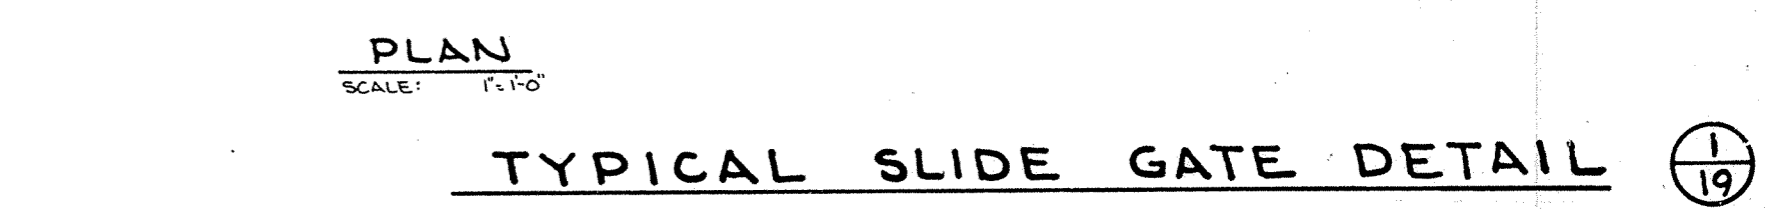

TYPICAL SLIDE GATE DETAIL C-19
SCALE: 1/4" = 1'-0"

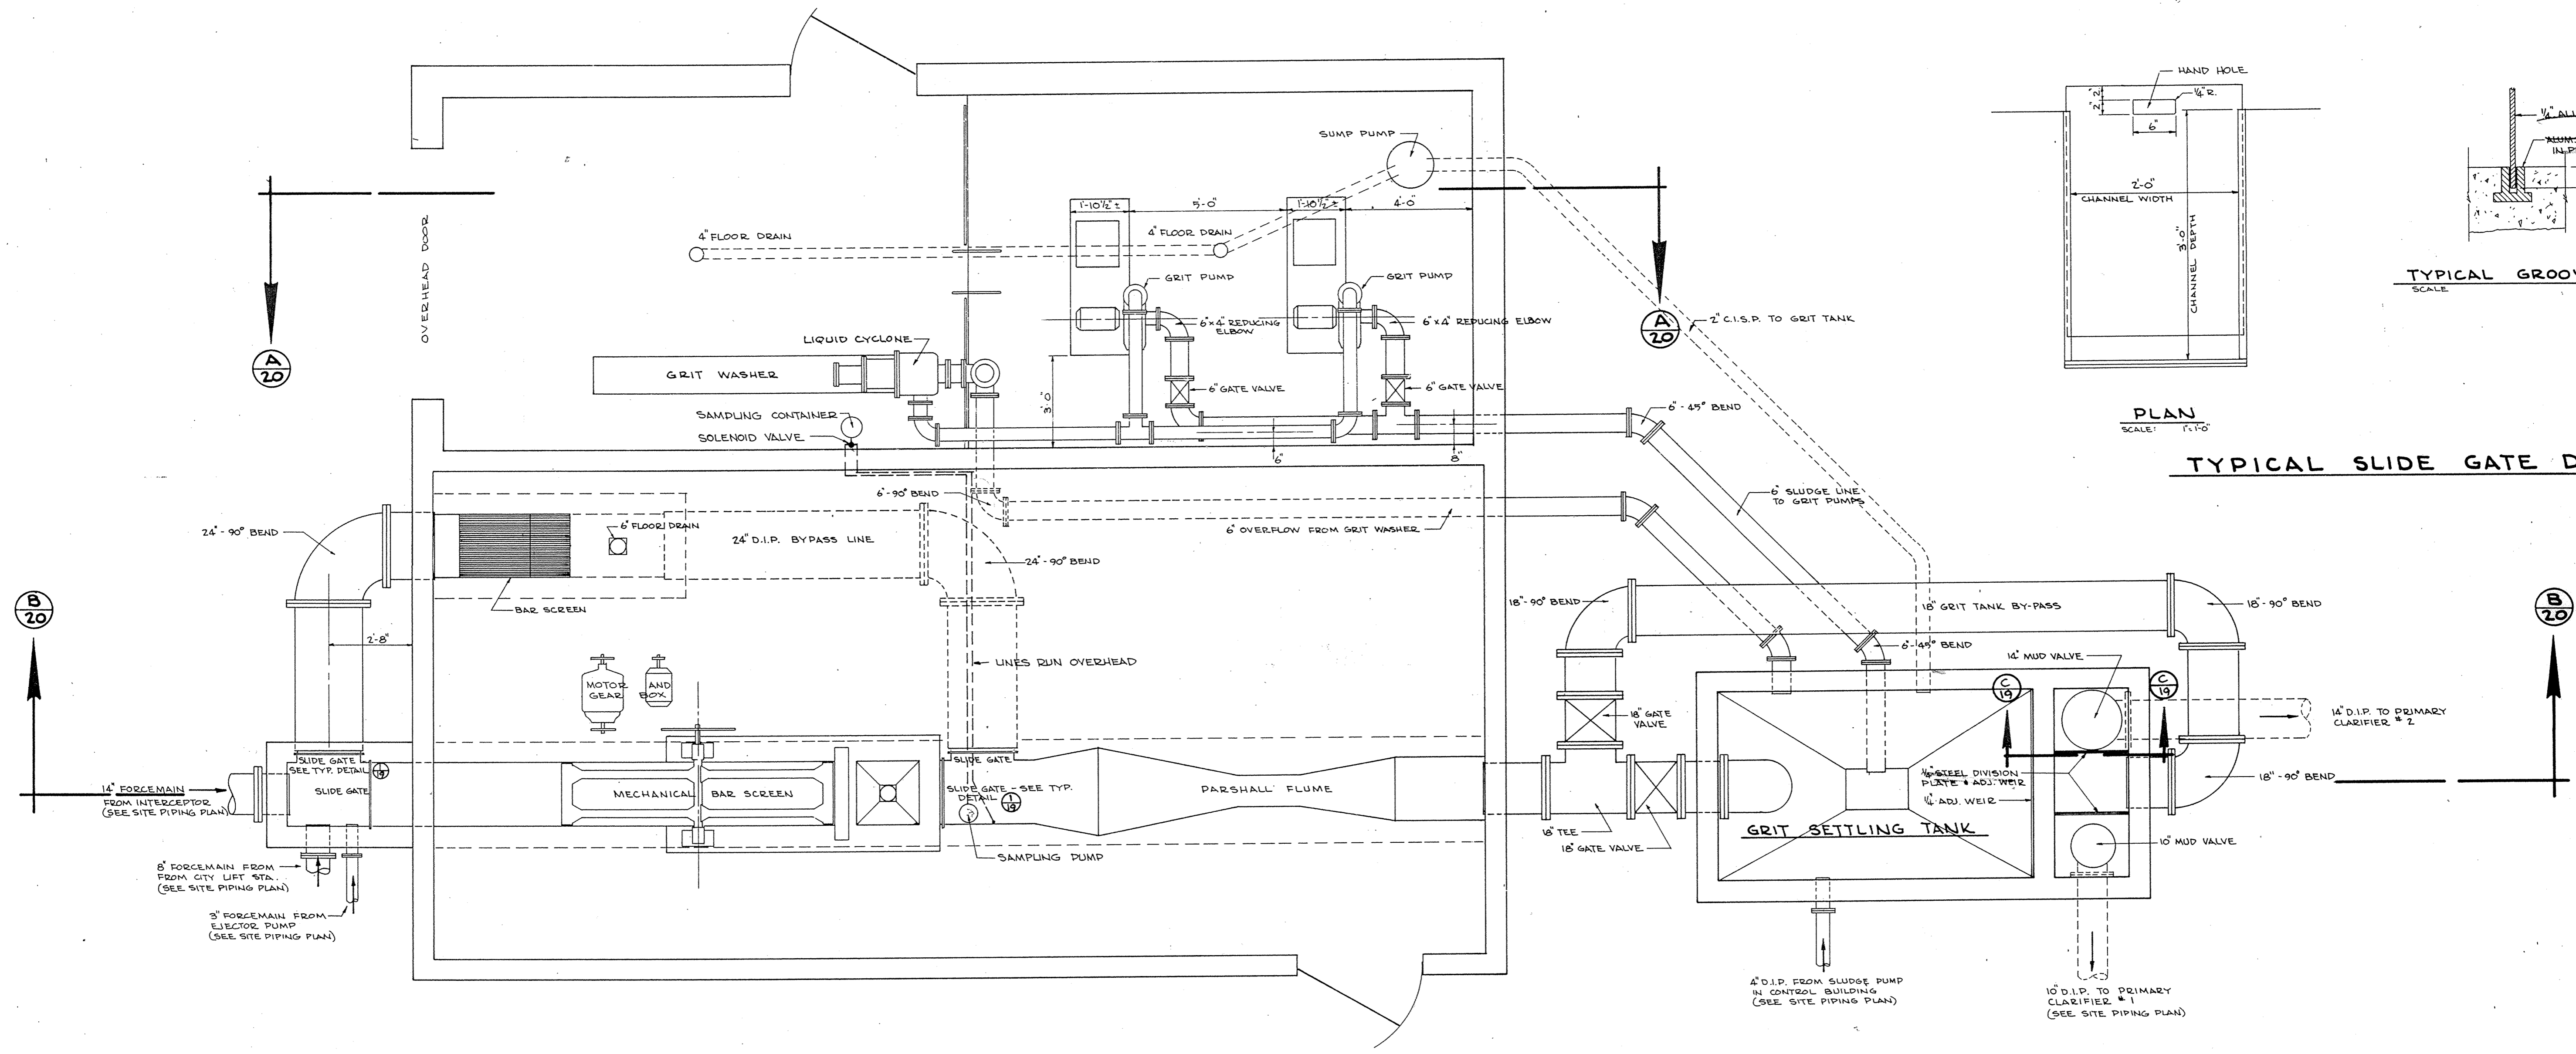

PLAN - PRETREATMENT BLDG.
SCALE: 3/8" = 1'-0"

NO.	DATE	BY	REVISIONS
B	2-23-77	J.R.C.	REVISED SLIDE GATE DETAIL
A	7-6-76	J.R.C.	MISC. REVISIONS

DESIGNED K.L.V.	CHECKED K.L.V.
DRAWN J.R.C.	APPROVED W.H.M.
DATE 8/26/75	COMM.

I HEREBY CERTIFY THAT THIS PLAN WAS PREPARED BY ME OR UNDER MY DIRECT SUPERVISION AND THAT I AM A DULY REGISTERED PROFESSIONAL ENGINEER UNDER THE LAWS OF THE STATE OF MINNESOTA.
Karen L. Van Oosten
DATE Aug 29, 1975 REG. NO. 10159

McCOMBS-KNUTSON ASSOCIATES, INC.
CONSULTING ENGINEERS ■ LAND SURVEYORS ■ SITE PLANNERS
MINNEAPOLIS, HUTCHINSON and MARSHALL, MINNESOTA

WASTE WATER TREATMENT FACILITIES
FOR
ELK RIVER, MINNESOTA

SCALE AS NOTED
BOOK PAGE
FILE NO. 2603
**MECHANICAL PLAN
PRETREATMENT
BUILDING**