


SECTION A
SCALE: 3/8"=1'-0"

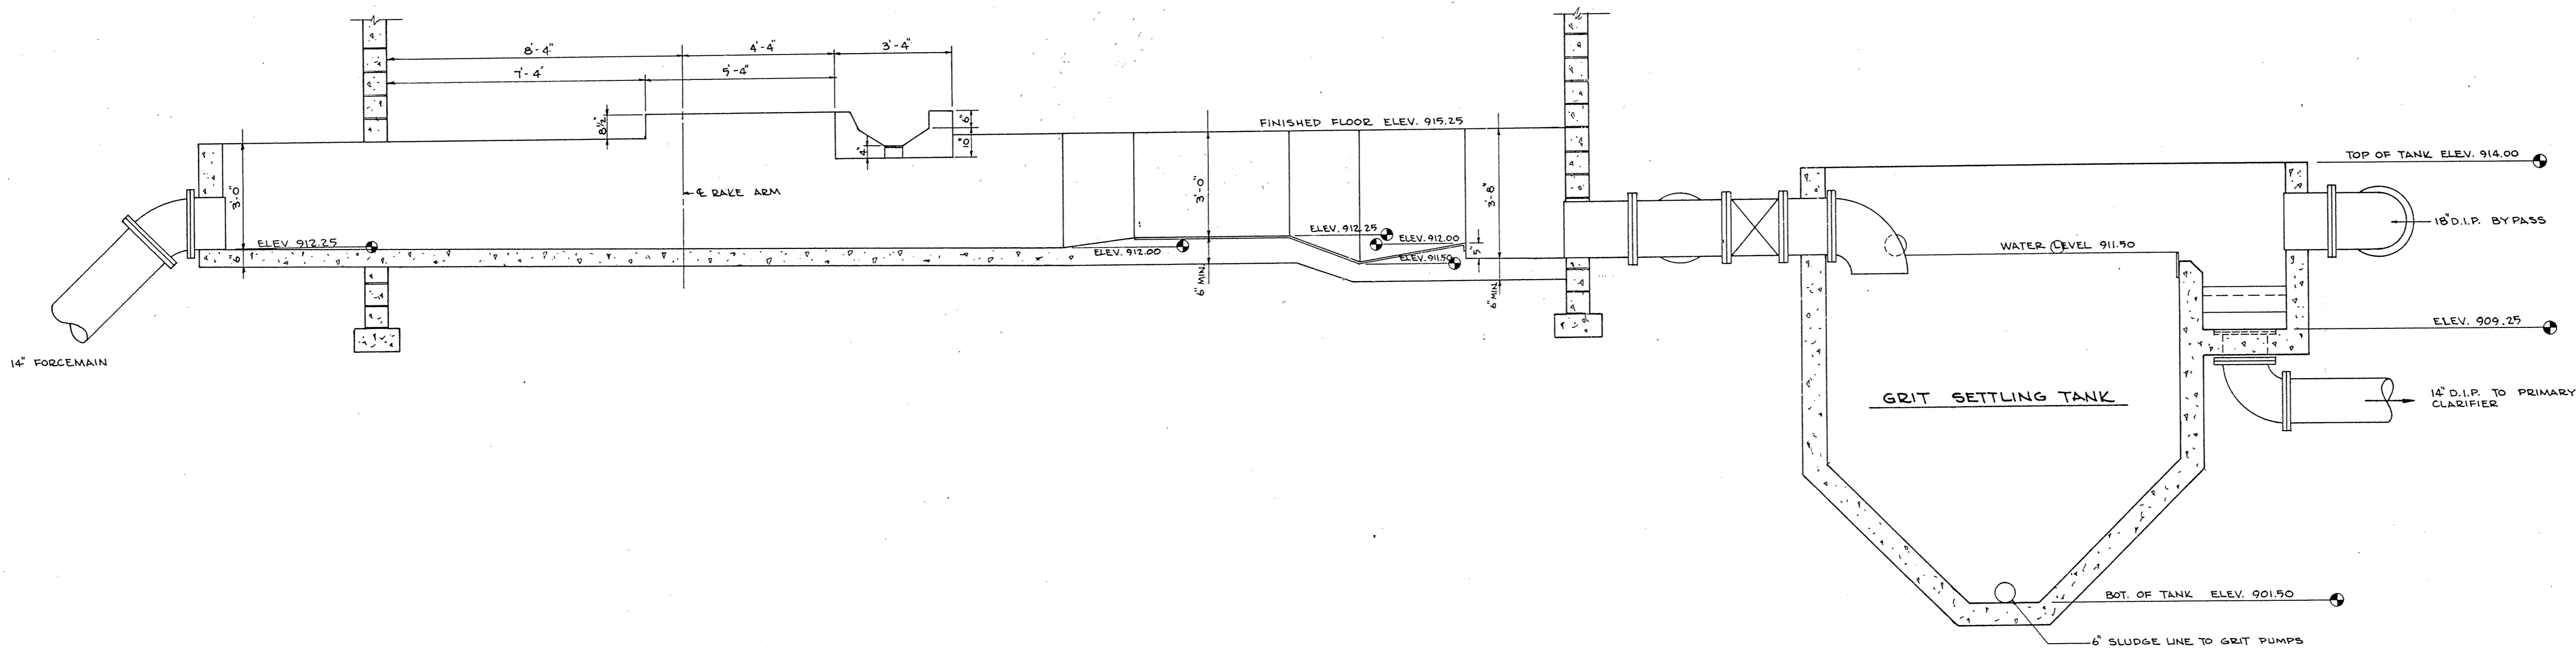

SECTION B
SCALE: 3/8"=1'-0"

NO.	DATE	BY	REVISIONS
B	2-23-77	J.R.C.	ADDED ELEV. TO CHANNEL
A	7-6-76	J.R.C.	MISC. REVISIONS

DESIGNED K.L.V.	CHECKED K.L.V.
DRAWN J.R.C.	APPROVED W.H.M.
DATE 8/26/75	COMM.

I HEREBY CERTIFY THAT THIS PLAN WAS PREPARED BY ME OR UNDER MY DIRECT SUPERVISION AND THAT I AM A DULY REGISTERED PROFESSIONAL ENGINEER UNDER THE LAWS OF THE STATE OF MINNESOTA.
Karen VanLaack
 DATE Aug 29, 1975 REG. NO. 10159

McCOMBS-KNUTSON ASSOCIATES, INC.
 CONSULTING ENGINEERS ■ LAND SURVEYORS ■ SITE PLANNERS
 MINNEAPOLIS, HUTCHINSON AND MARSHALL, MINNESOTA

WASTE WATER TREATMENT FACILITIES
 FOR
ELK RIVER, MINNESOTA

SCALE AS NOTED	BOOK	PAGE
FILE NO. 2603		

**MECHANICAL PLAN
 PRETREATMENT
 BUILDING**

SHEET 20	REV. B
OF 31	