



- NOTES:**
1. SEE STRUCTURAL/REMOVAL NOTES ON SHEET S1.
 2. SEE MECHANICAL PLANS FOR MECHANICAL RELATED DEMOLITIONS AND MODIFICATIONS.
 3. SEE ELECTRICAL PLANS FOR ELECTRICAL RELATED DEMOLITIONS AND MODIFICATIONS.
 4. SEE ARCHITECTURAL PLANS FOR ARCHITECTURAL RELATED DEMOLITIONS AND MODIFICATIONS.
 5. SEE STRUCTURAL PLANS FOR FOUNDATION, FLOOR, WALL AND MISCELLANEOUS STRUCTURAL MODIFICATIONS.
 6. THE CONTRACTOR SHALL COORDINATE WITH THE OWNER PRIOR TO ANY DEMOLITION WORK. THE OWNER WILL VERIFY ITEMS TO BE SALVAGED.

MAIN BUILDING DEMOLITION - PLAN
 Scale: 1/4" = 1'-0"

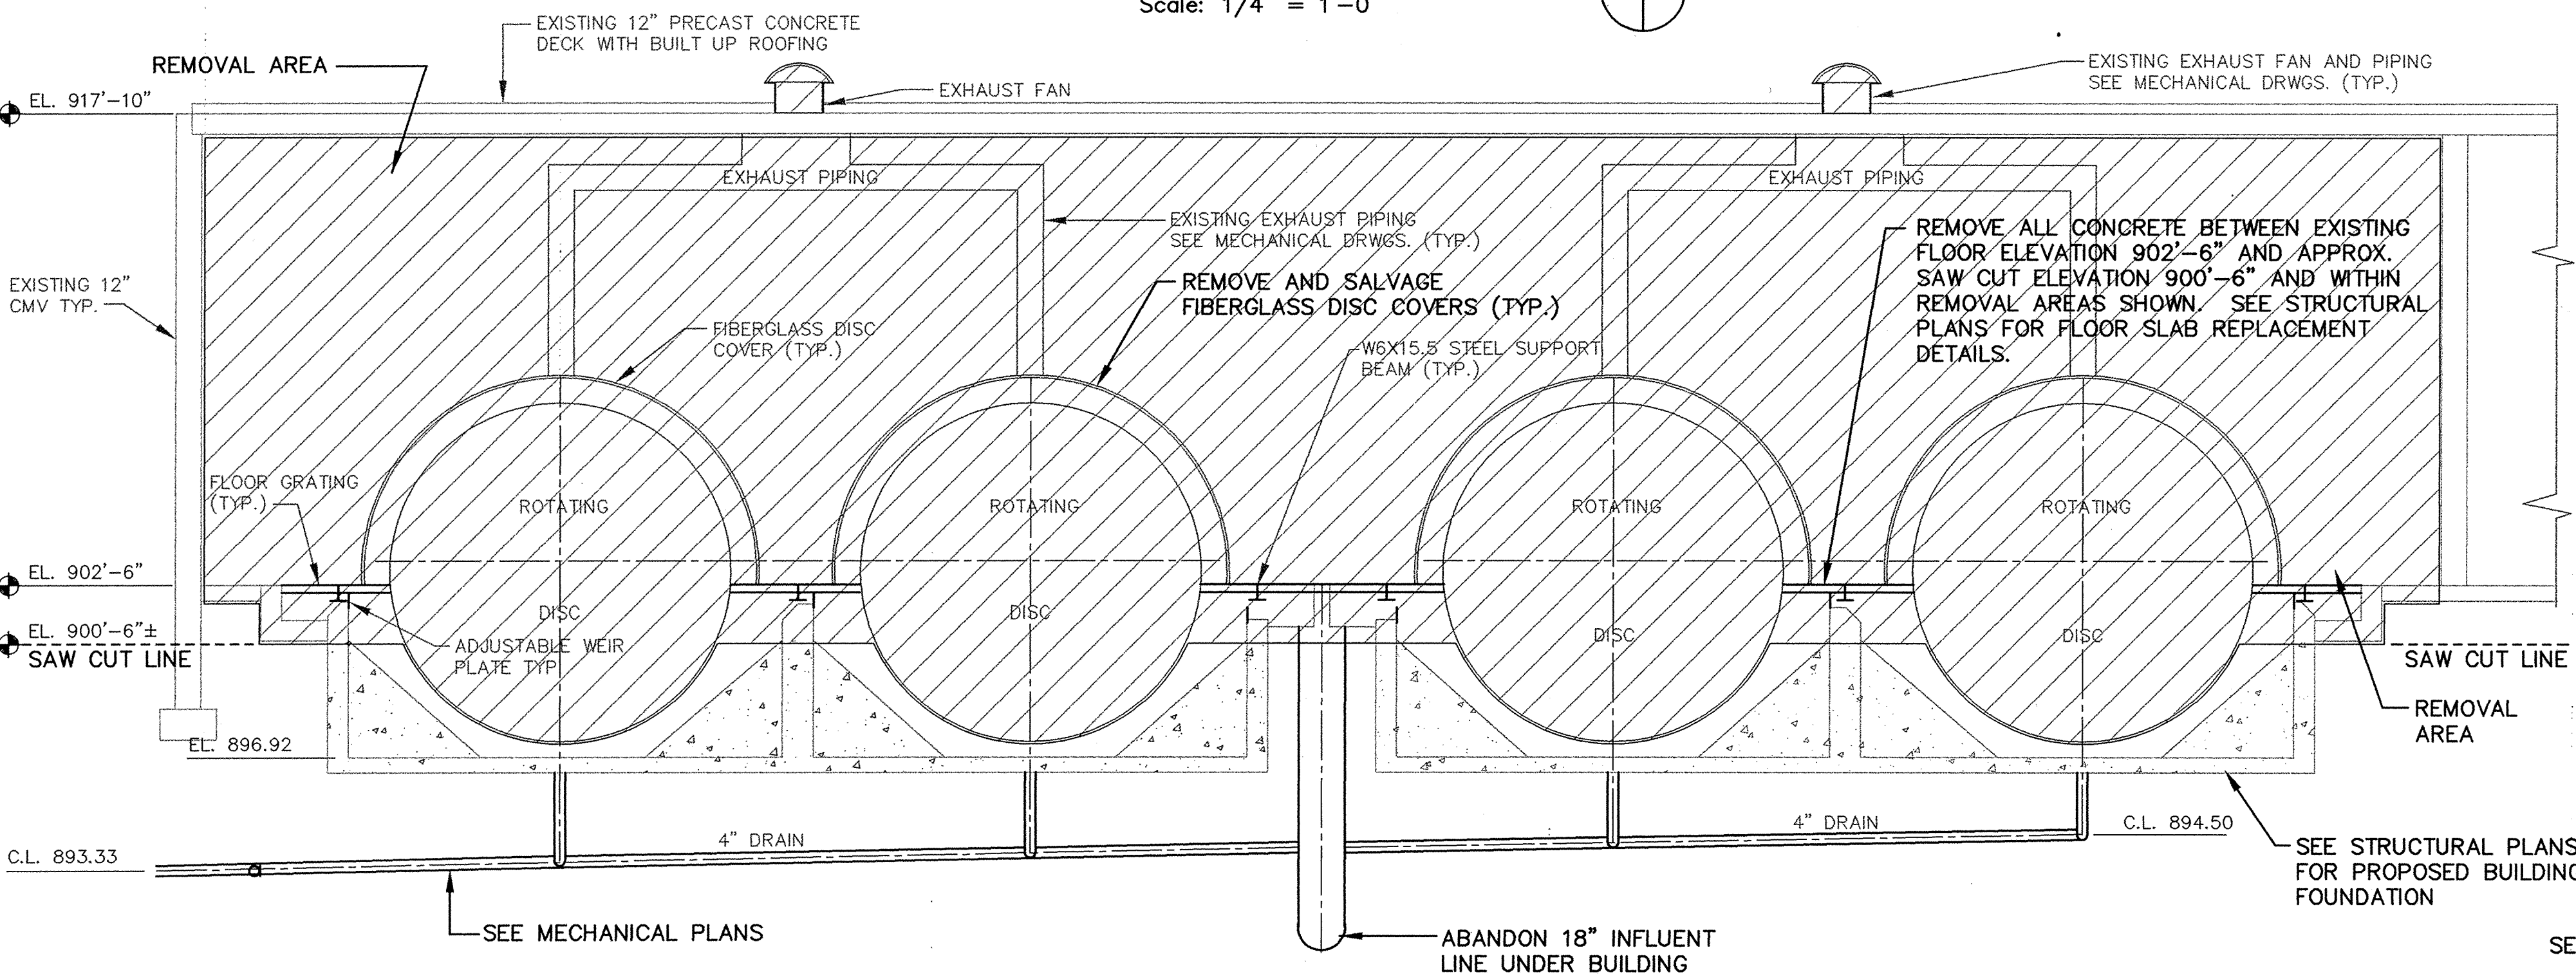

MAIN BUILDING DEMOLITION - SECTION 1
 Scale: 1/4" = 1'-0"

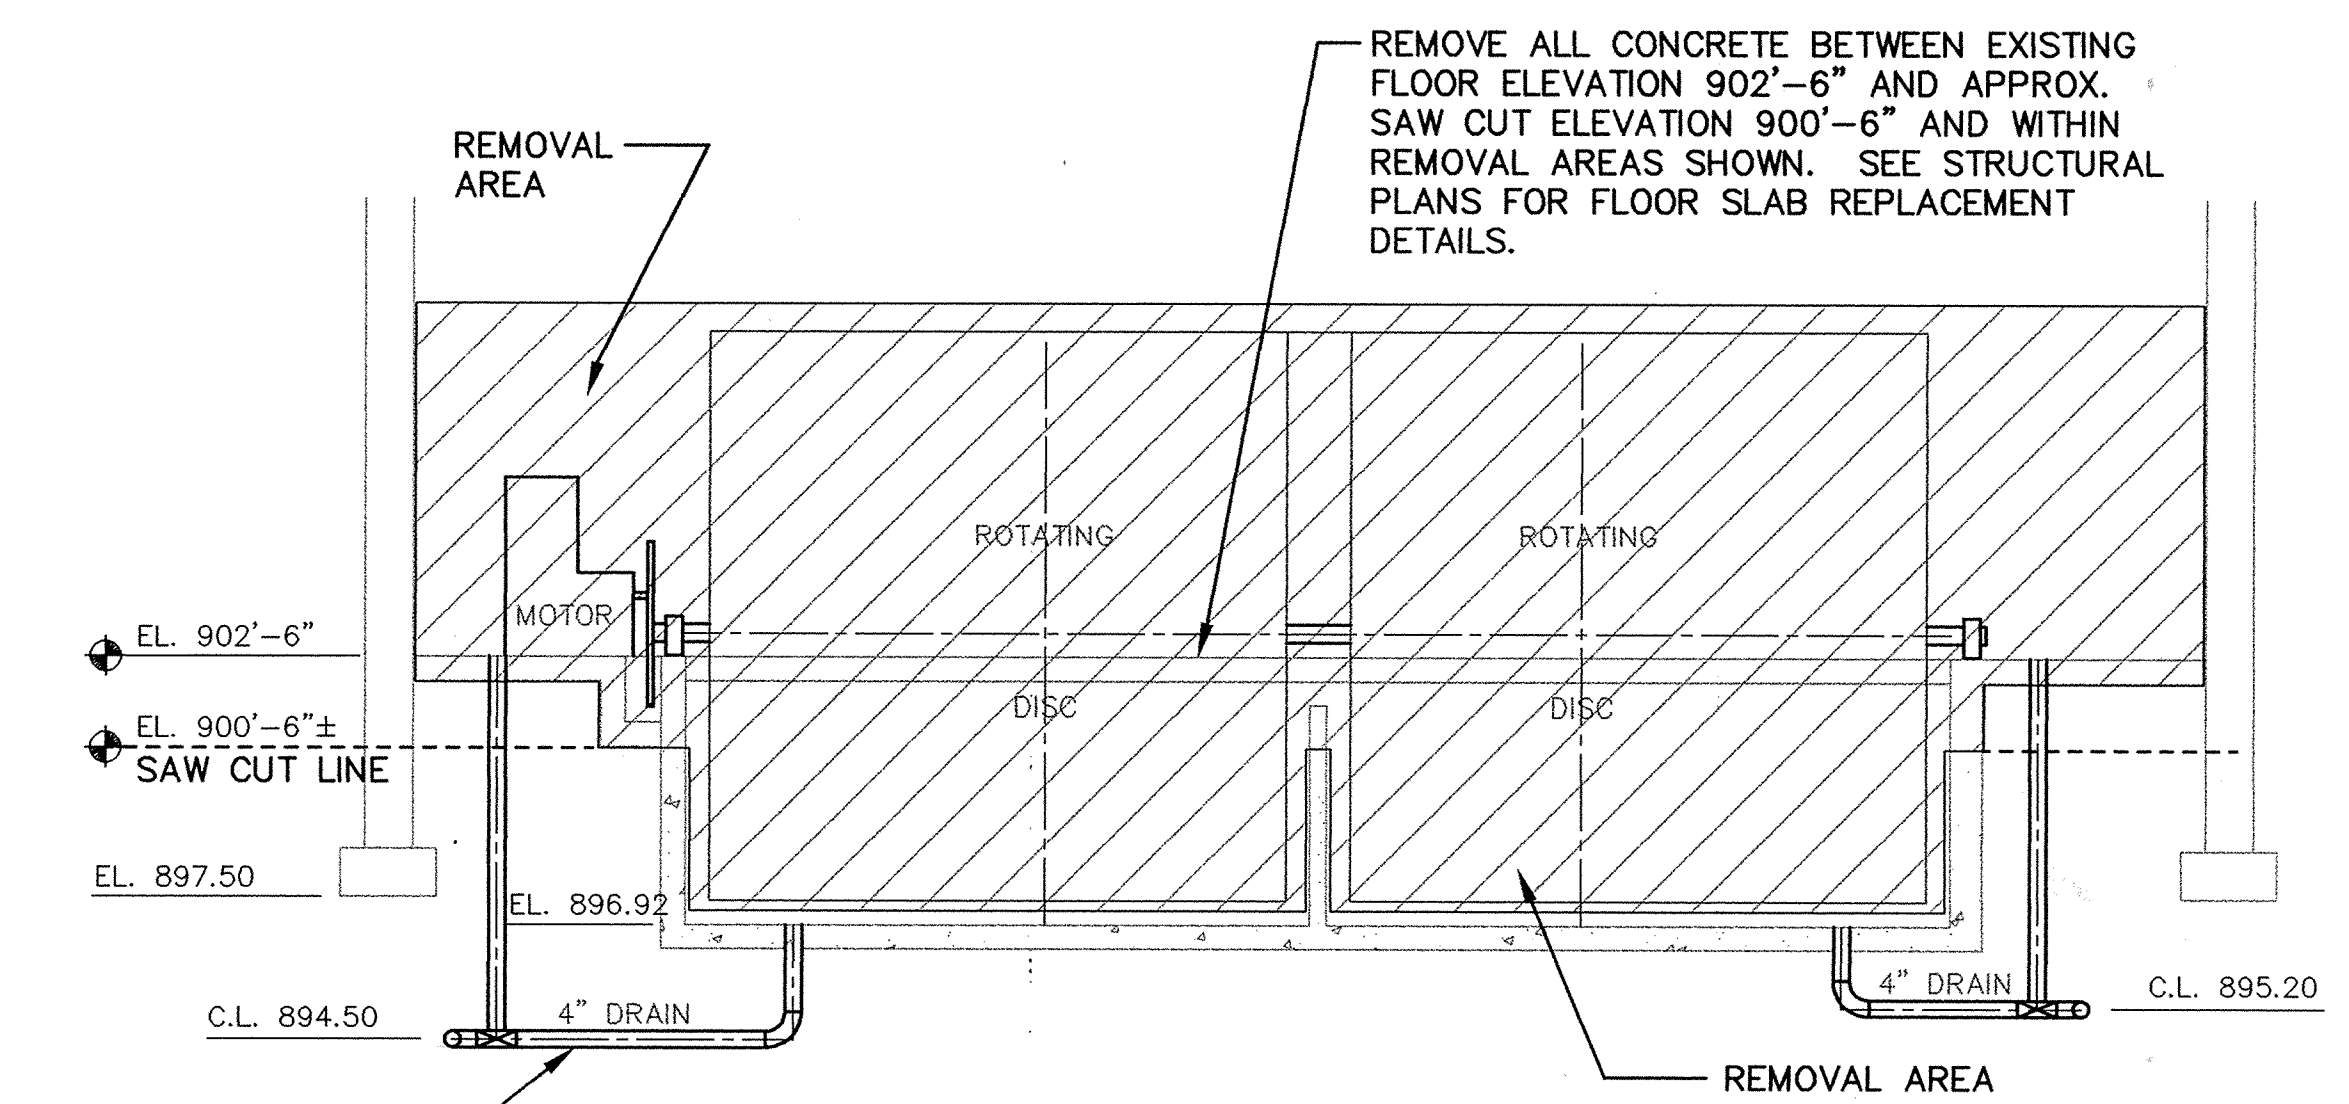

MAIN BUILDING DEMOLITION - SECTION 2
 Scale: 1/4" = 1'-0"

I HEREBY CERTIFY THAT THIS PLAN, SPECIFICATION, OR REPORT WAS PREPARED BY ME OR UNDER MY DIRECT SUPERVISION AND THAT I AM A DULY REGISTERED PROFESSIONAL ENGINEER UNDER THE LAWS OF THE STATE OF MINNESOTA.
David J. Cappel
 DATE 11/29/95 REG. NO. 2222



1326 ENERGY PARK DRIVE
 ST. PAUL, MINNESOTA 55108
 (612) 644-4389
 9800 SHELARD PARKWAY
 MINNEAPOLIS, MINNESOTA 55441
 (612) 546-0432

REVISIONS	DATE	DESCRIPTION	DESIGNED_DC	CHECKED_DC	DRAWN_CLS

CITY OF ELK RIVER
 WASTEWATER TREATMENT FACILITY UPGRADE
 MAIN BUILDING DEMOLITION PLAN AND SECTIONS

S2