


SECTION 1
 Scale: 3/8" = 1'-0" P5

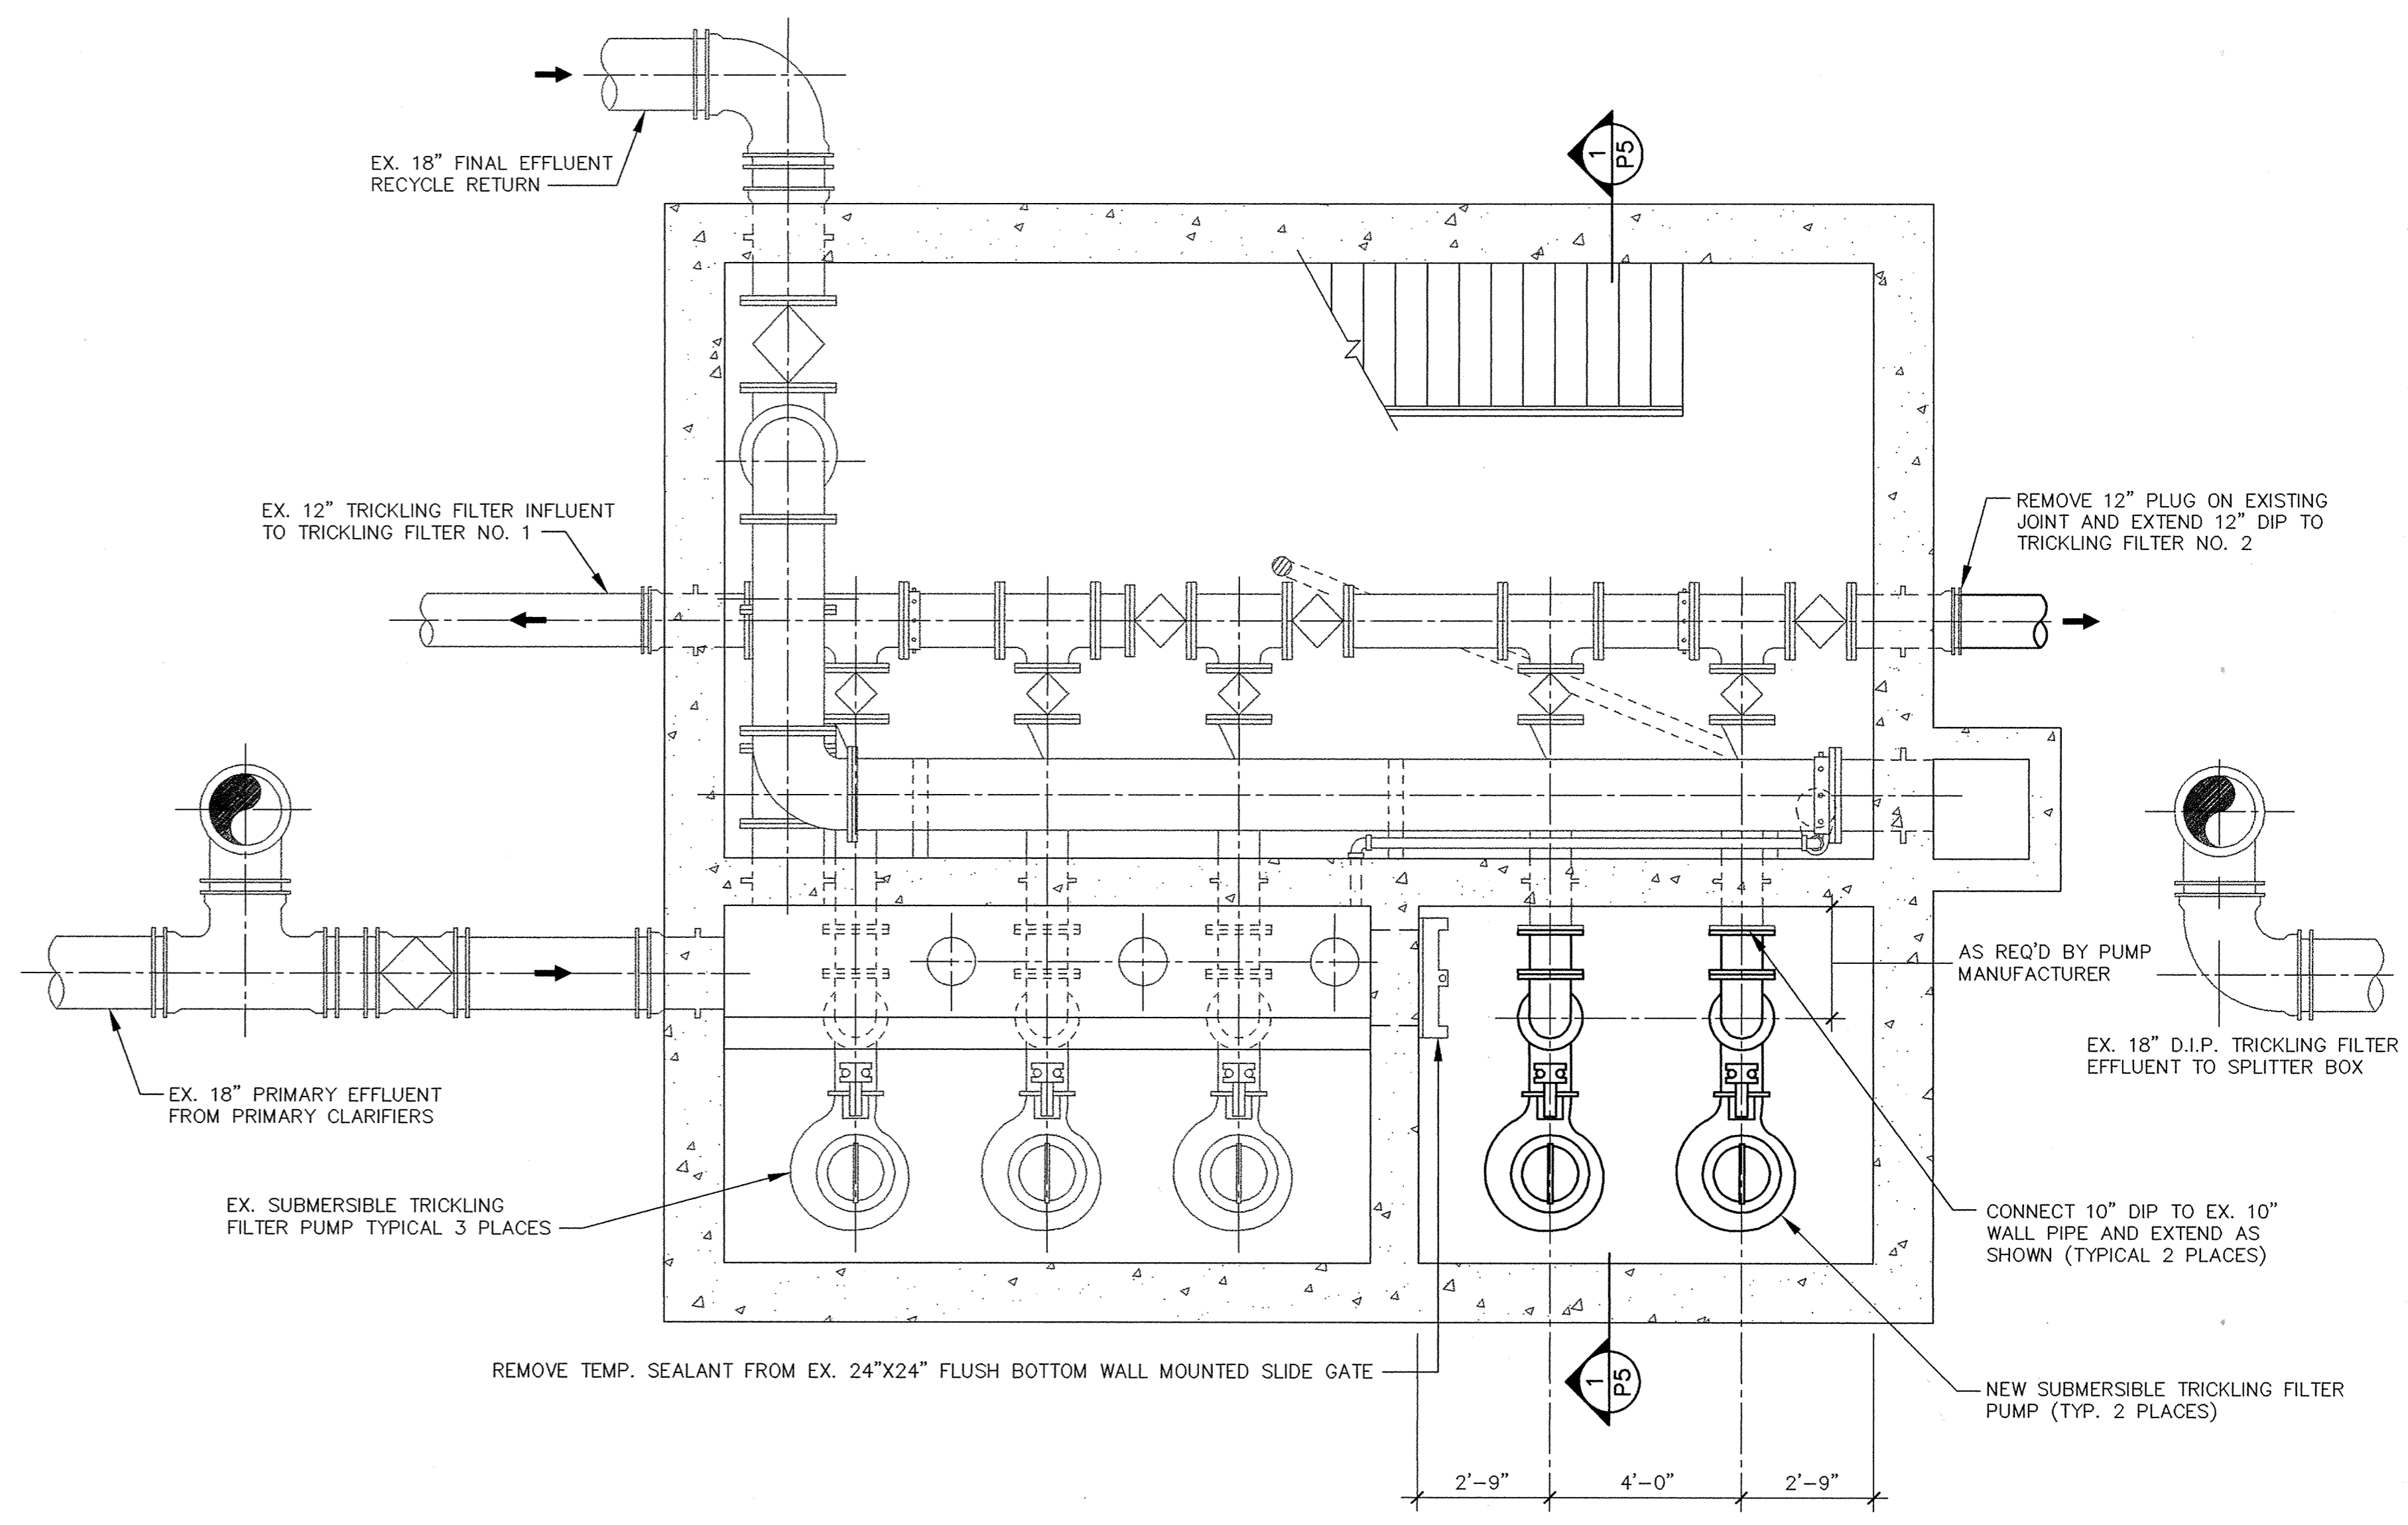

TRICKLING FILTER PUMP STATION PLAN @ EL. 900.00
 Scale: 3/8" = 1'-0"

I HEREBY CERTIFY THAT THIS PLAN, SPECIFICATION, OR REPORT WAS PREPARED BY ME OR UNDER MY DIRECT SUPERVISION AND THAT I AM A DULY REGISTERED PROFESSIONAL ENGINEER UNDER THE LAWS OF THE STATE OF MINNESOTA. <i>[Signature]</i> DATE 11/8/95 REG. NO. 22610		1326 ENERGY PARK DRIVE ST. PAUL, MINNESOTA 55108 (612) 644-4389		9800 SHELDON PARKWAY MINNEAPOLIS, MINNESOTA 55441 (612) 546-0432		DESIGNED BC GG CHECKED TAR DRAWN GG	CITY OF ELK RIVER WASTEWATER TREATMENT FACILITY UPGRADE TRICKLING FILTER PUMP STATION PIPING PLAN & SECTION	P5
		DATE OCT. 1995	SHEET 58 OF 112 SHEETS	PROJECT NO. 230-151				

Nov 10 10:29:43 1995