


EXISTING  
TRICKLING FILTER NO. 1

TRICKLING FILTER NO. 2

NOTE  
CONTRACTOR SHALL FURNISH & INSTALL FILTER  
MEDIA GRATING OVER ENTIRE MEDIA SURFACE  
ON EXISTING TRICKLING FILTER NO. 1.

NOTE:  
STAIRS & WALKWAY NOT SHOWN  
FOR CLARITY PURPOSES. SEE  
SHEET S10 FOR STAIR & ROOF  
PLAN.

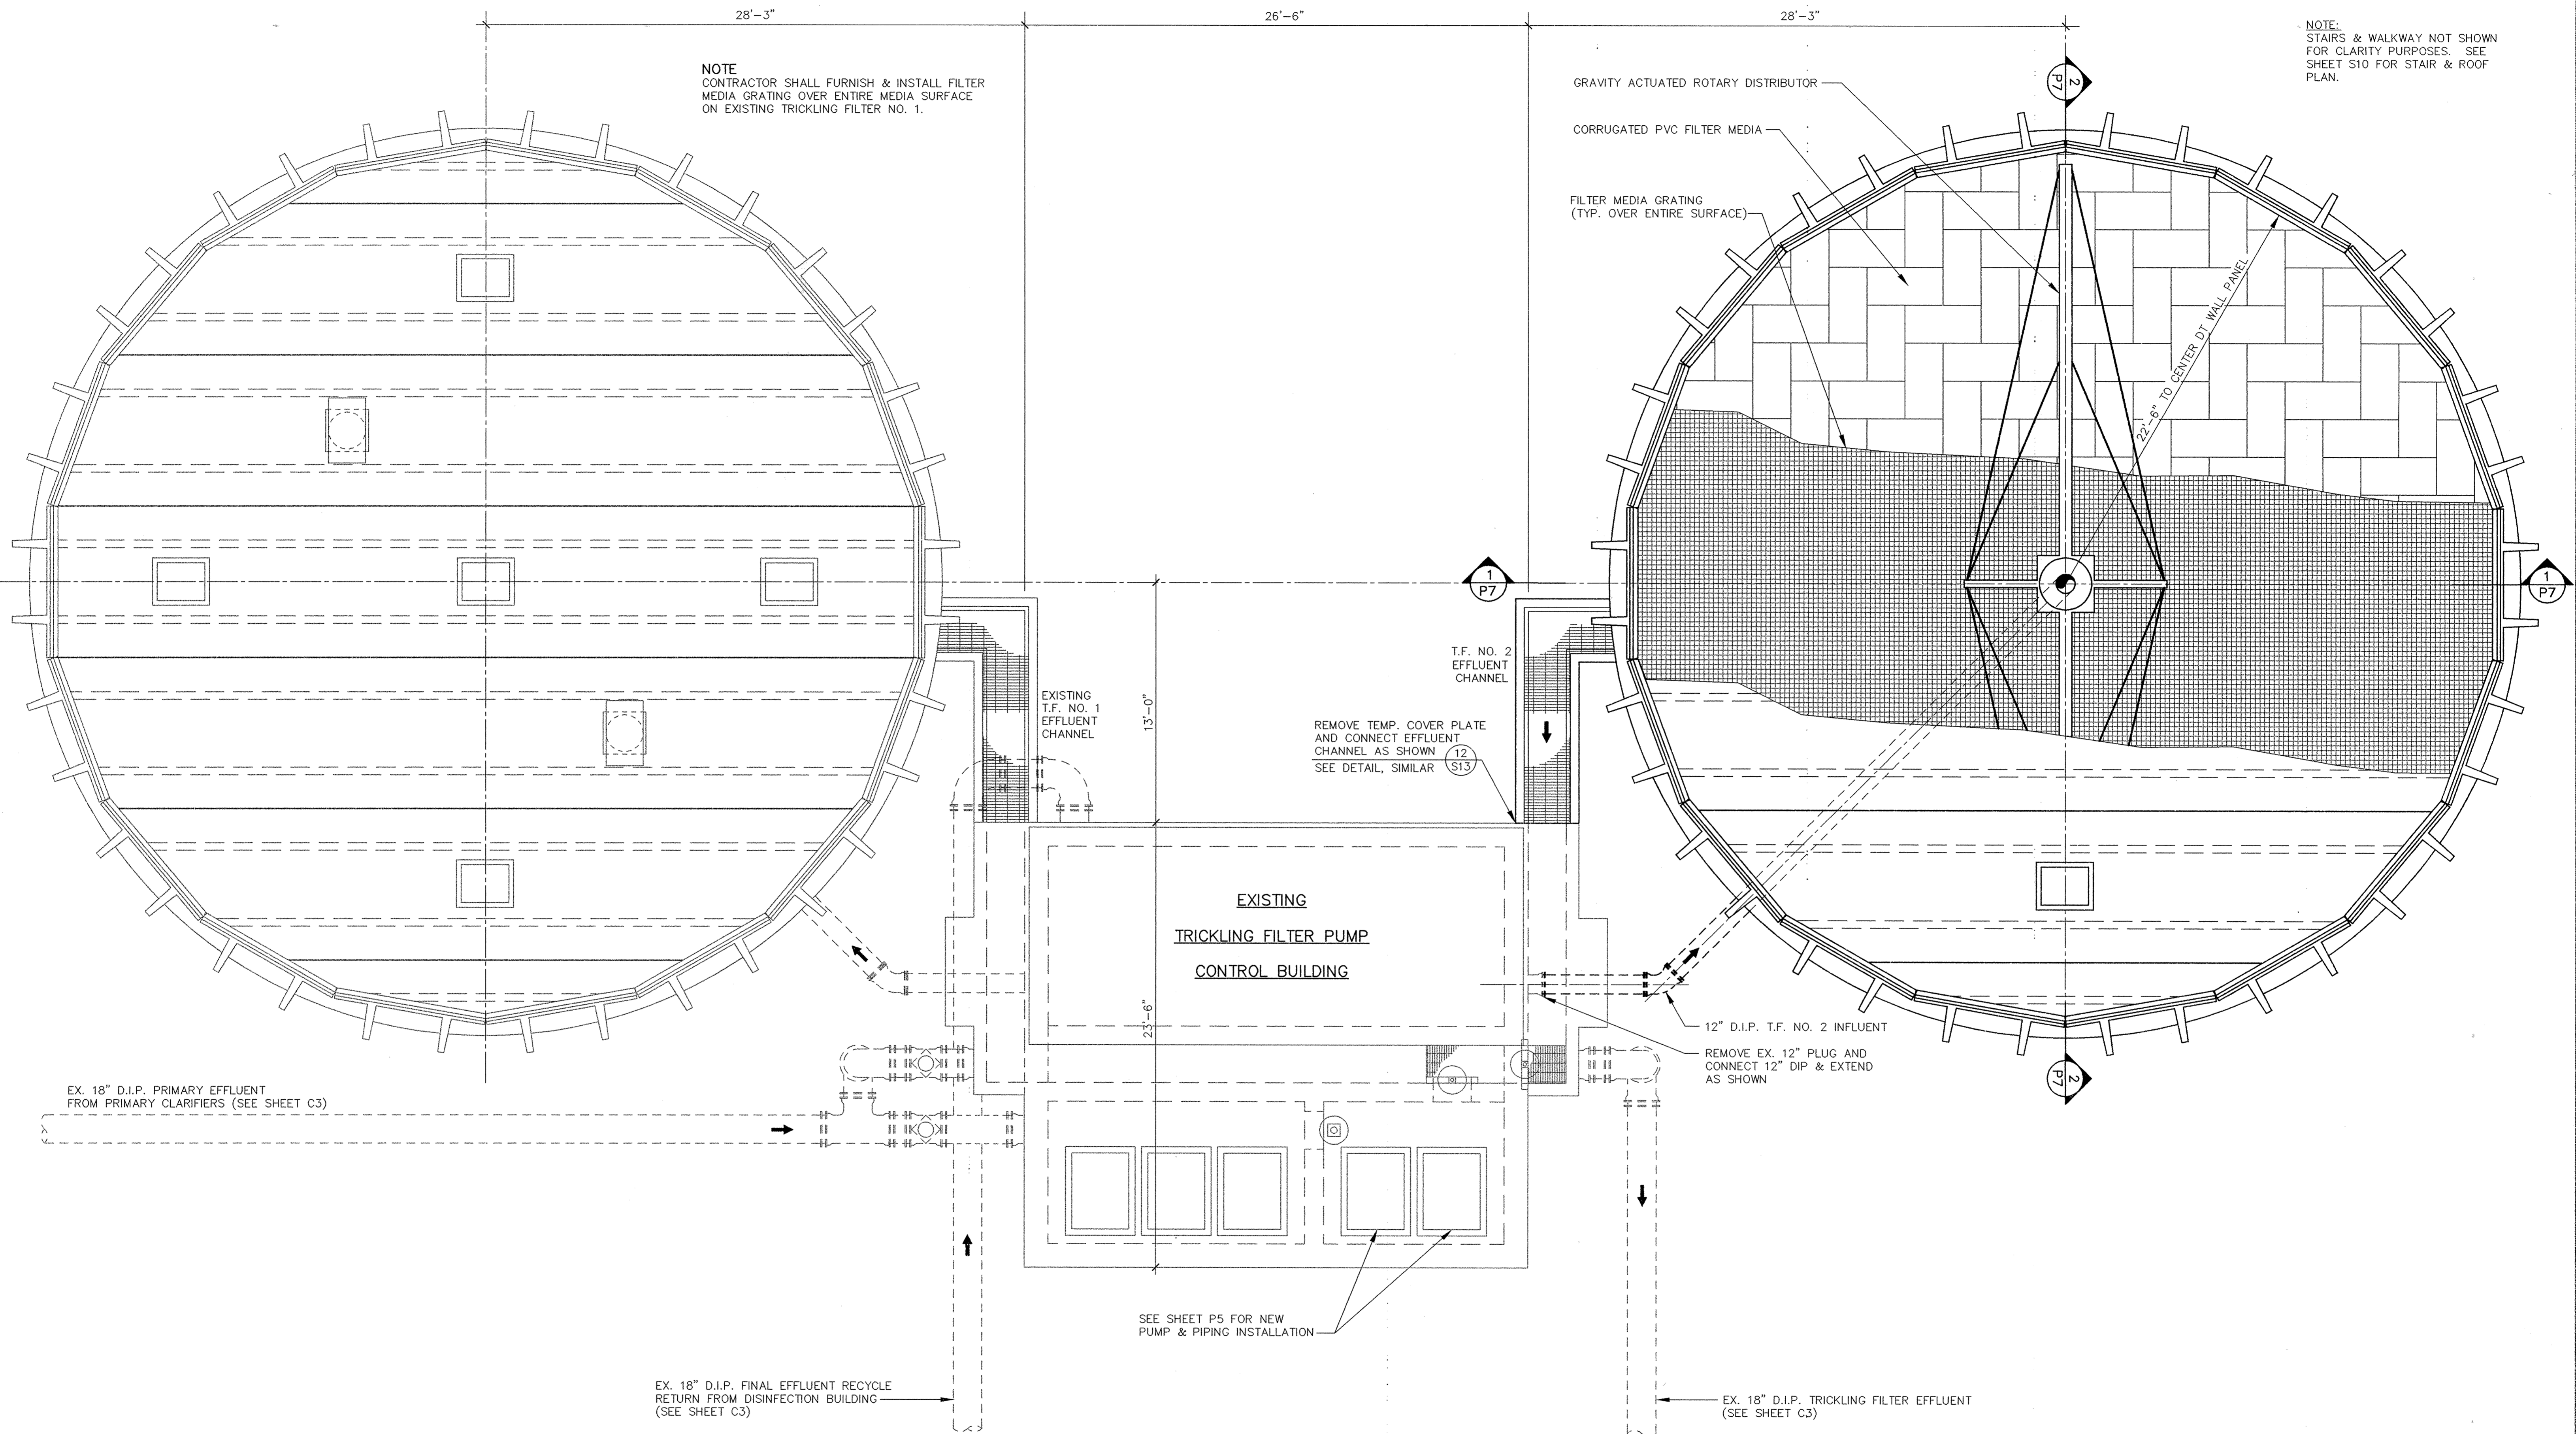

**TRICKLING FILTER PIPING PLAN**

Scale: 1/4" = 1'-0"

I HEREBY CERTIFY THAT THIS PLAN, SPECIFICATION,  
OR REPORT WAS PREPARED BY ME OR UNDER MY DIRECT  
SUPERVISION AND THAT I AM A DULY REGISTERED  
PROFESSIONAL ENGINEER UNDER THE LAWS OF THE  
STATE OF MINNESOTA.  
*[Signature]*  
DATE 11/8/95 REG. NO. 22610



1326 ENERGY PARK DRIVE  
ST. PAUL, MINNESOTA 55108  
(612) 644-4389  
  
9800 SHELARD PARKWAY  
MINNEAPOLIS, MINNESOTA 55441  
(612) 546-0432

DATE	DESCRIPTION

DESIGNED	BC GG
CHECKED	TAR
DRAWN	GG
GRAPHIC SCALE	
0	HORIZ. 4
0	VERT. 4

CITY OF ELK RIVER  
WASTEWATER TREATMENT FACILITY UPGRADE  
TRICKLING FILTER  
PIPING PLAN

P6

DATE OCT. 1995 SHEET 59 OF 112 SHEETS PROJECT NO. 230-151