



**FINAL CLARIFIER PLAN @ GRADE**  
Scale: 1/4" = 1'-0"

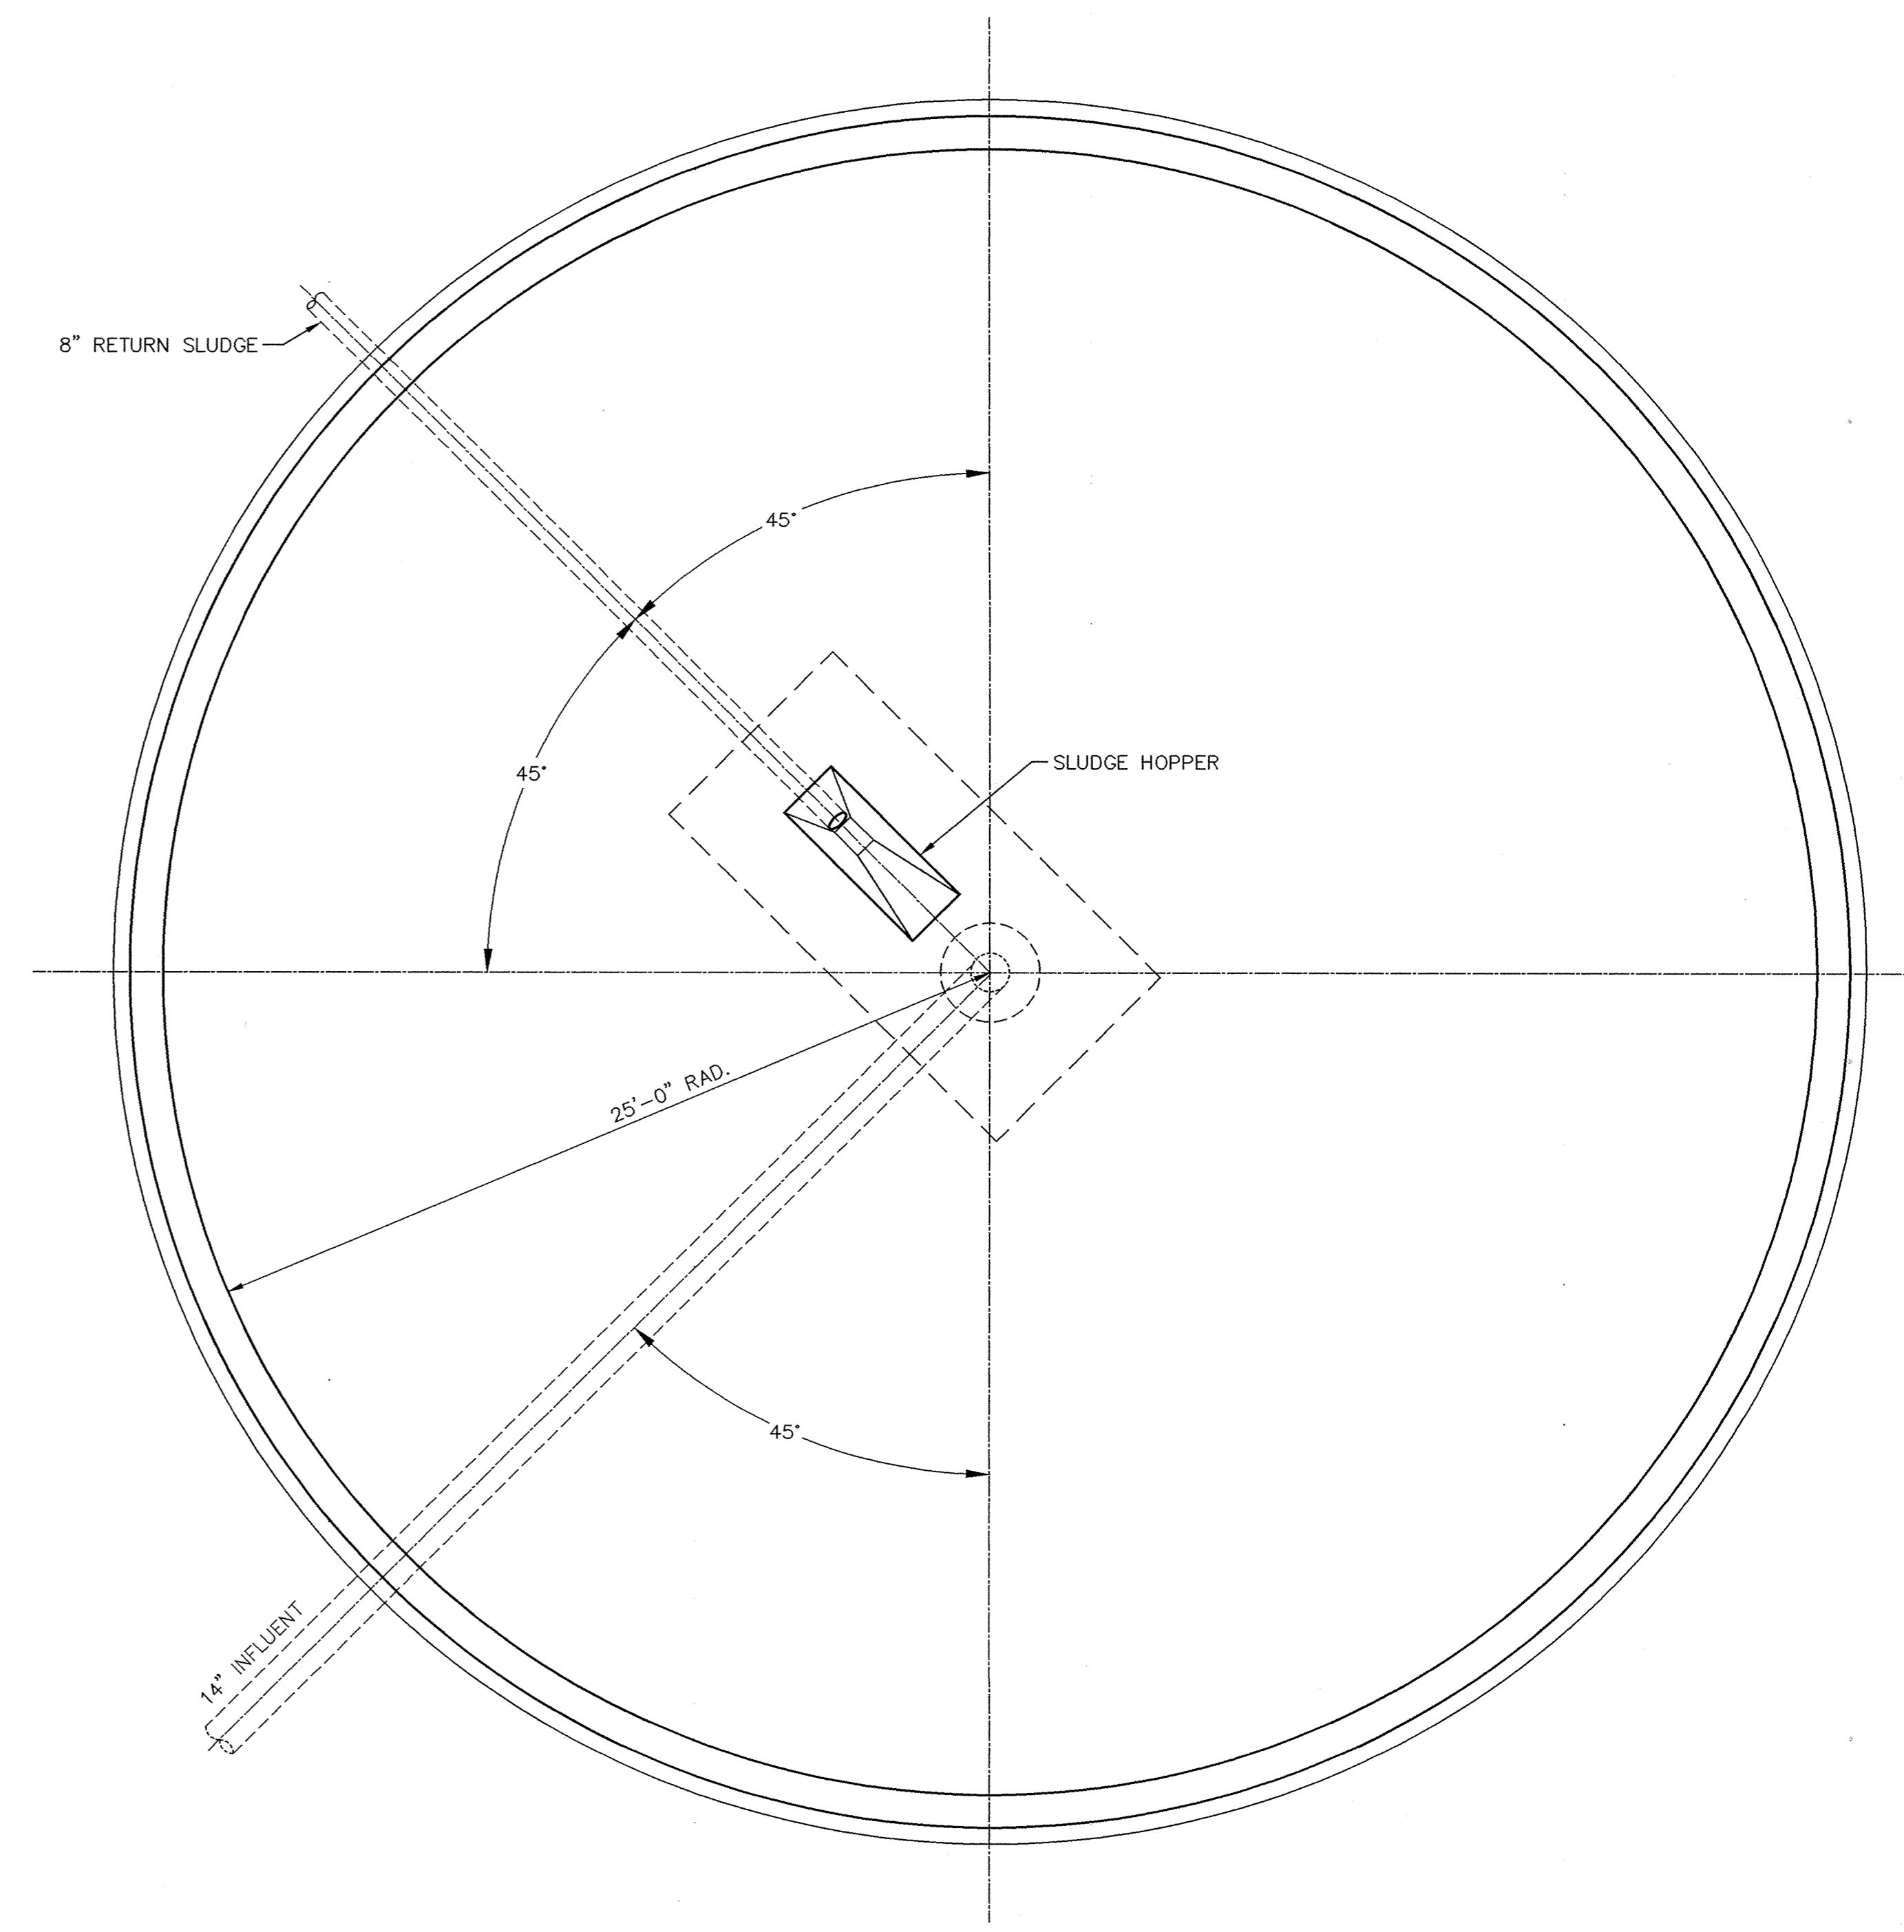

**FINAL CLARIFIER BASE SLAB PLAN**  
Scale: 1/4" = 1'-0"

**NOTES**  
PLAN VIEWS REPRESENT FINAL CLARIFIER NO. 2.  
SEE SITE PIPING PLAN, SHEET C3 FOR PIPE &  
BRIDGE ORIENTATION ON FINAL CLARIFIERS NO. 1 & 3.

I HEREBY CERTIFY THAT THIS PLAN, SPECIFICATION, OR REPORT WAS PREPARED BY ME OR UNDER MY DIRECT SUPERVISION AND THAT I AM A DULY REGISTERED PROFESSIONAL ENGINEER UNDER THE LAWS OF THE STATE OF MINNESOTA.  
*[Signature]*  
DATE 11/8/95 REG. NO. 22610

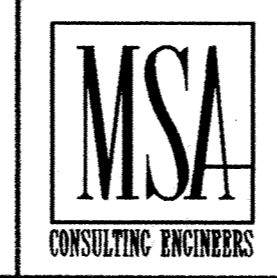

1326 ENERGY PARK DRIVE  
ST. PAUL, MINNESOTA 55108  
(612) 644-4389  
9800 SHELARD PARKWAY  
MINNEAPOLIS, MINNESOTA 55441  
(612) 546-0432

REVISIONS	DATE	DESCRIPTION	DESIGNED BC GG	CHECKED TAR	DRAWN GG TB

GRAPHIC SCALE  
0 HORIZ. 4  
0 VERT. 4

CITY OF ELK RIVER  
WASTEWATER TREATMENT FACILITY UPGRADE  
FINAL CLARIFIER NO. 1, NO. 2 AND NO. 3  
PROCESS PLAN & DETAILS

**P12**

NOV 01 4 09:11:24 1995